

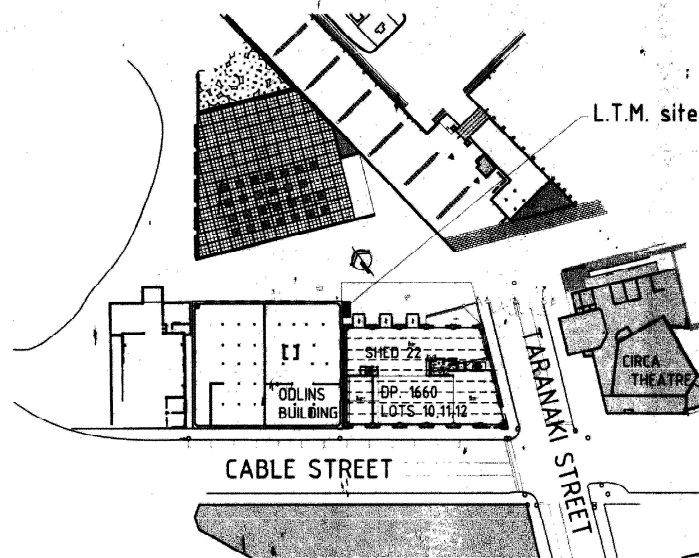


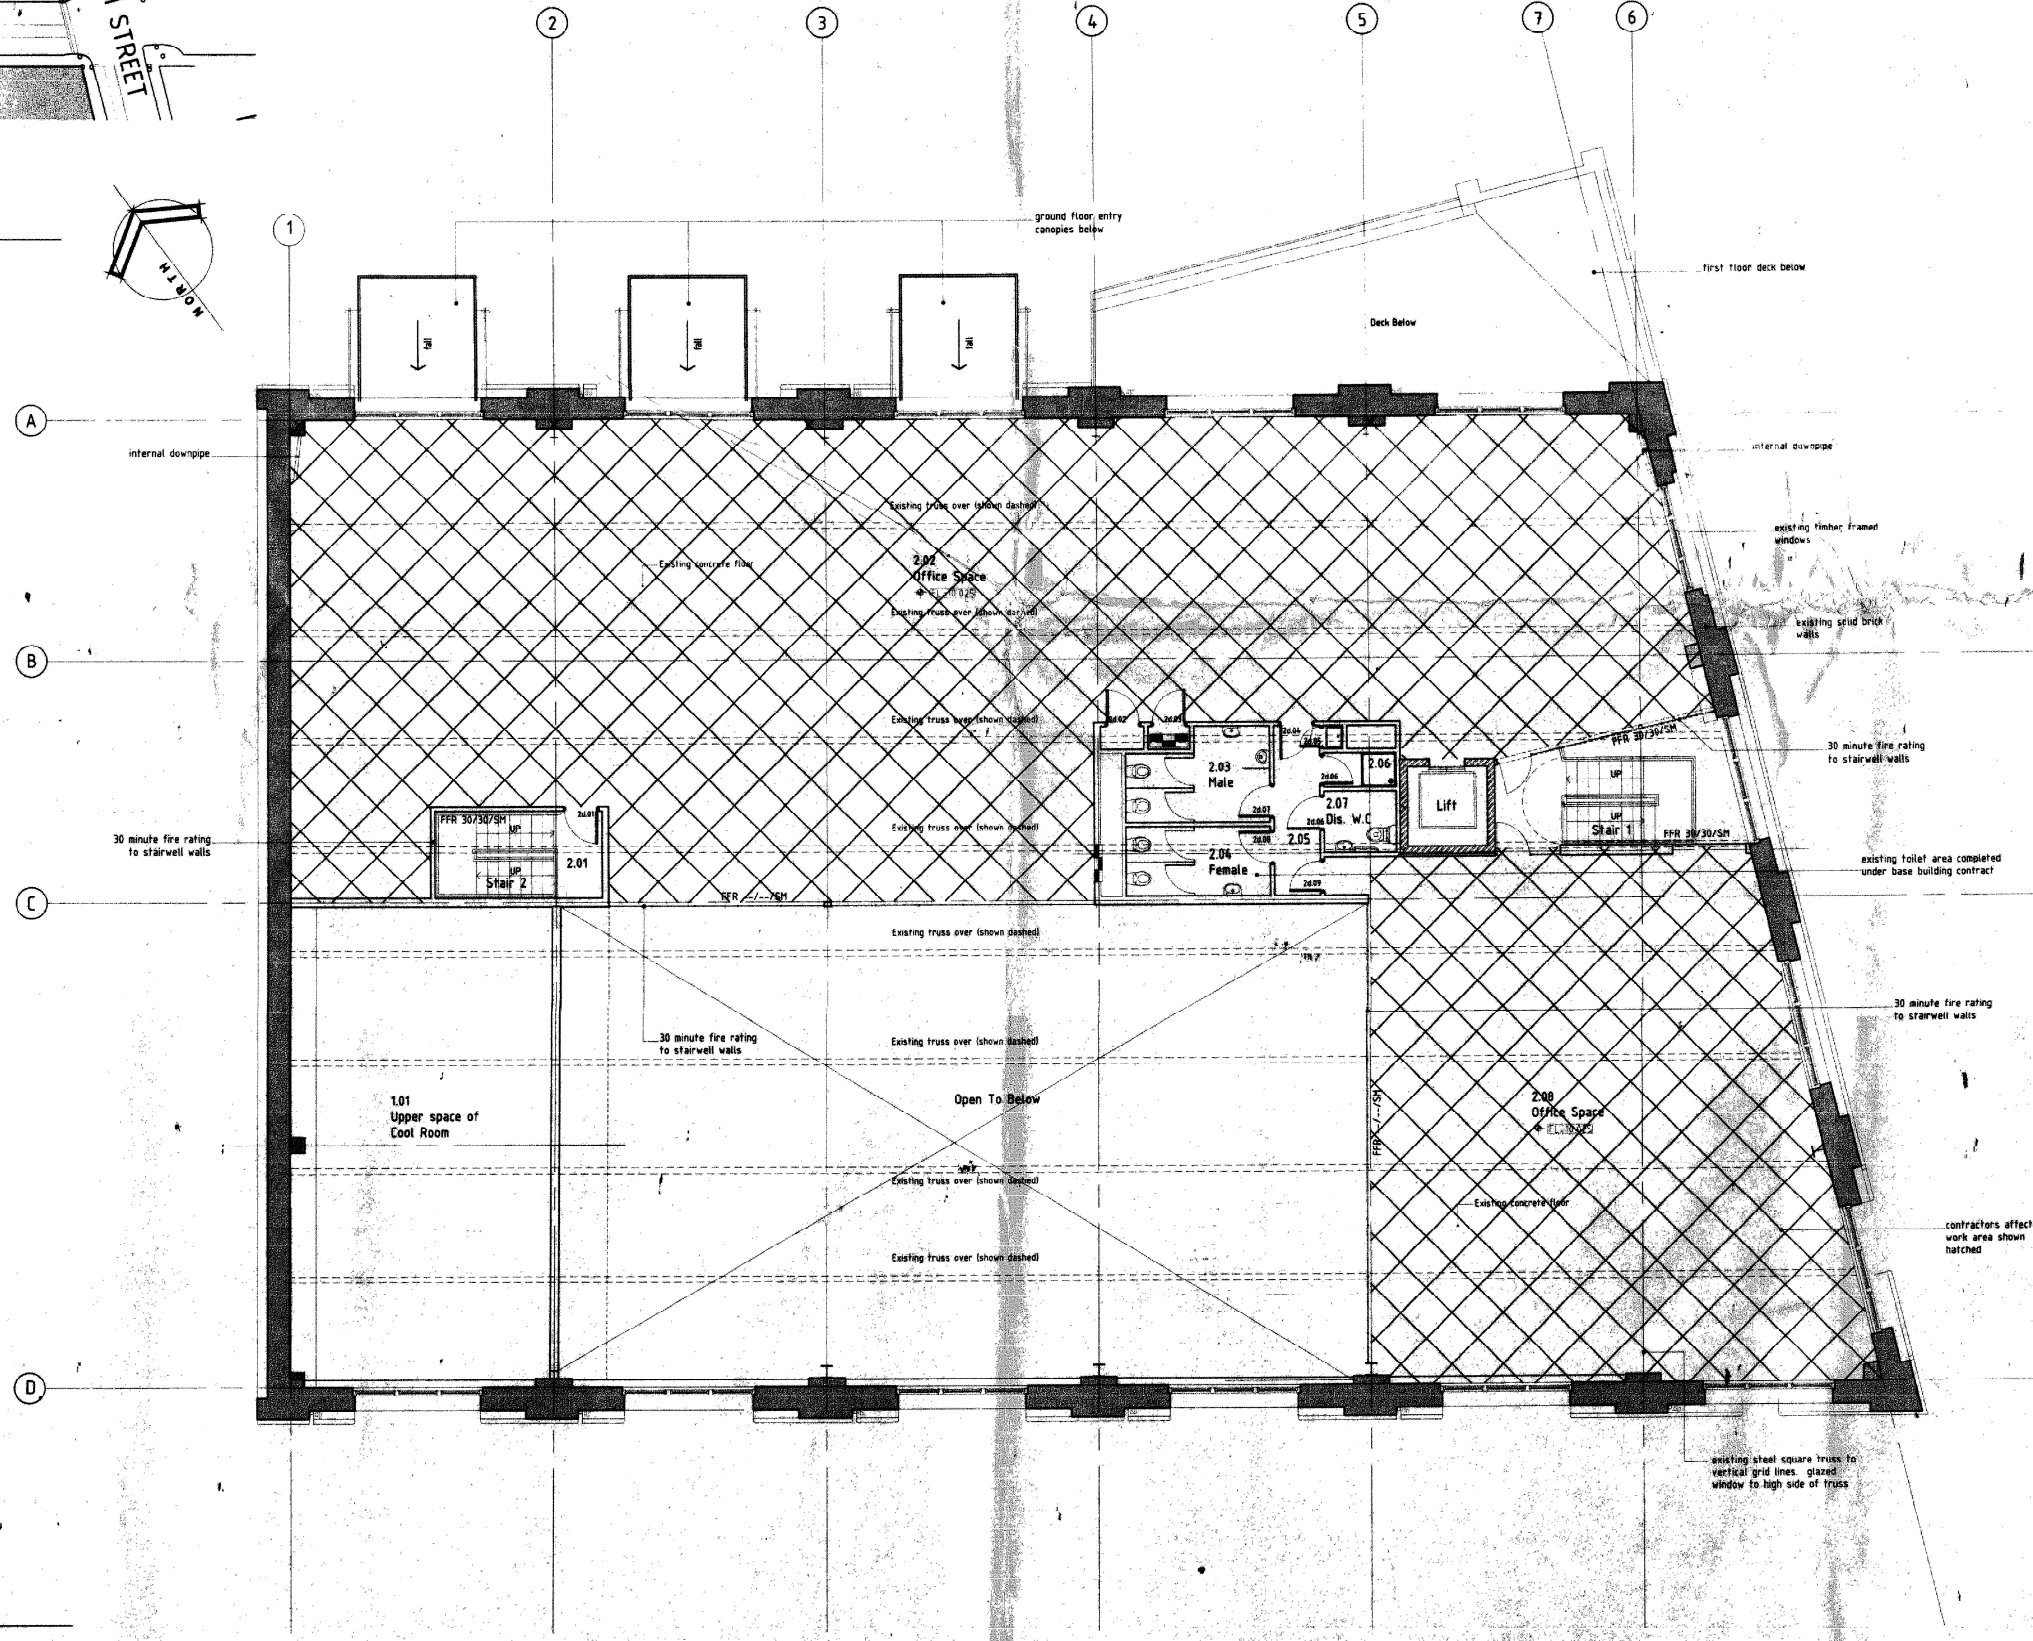

01 Site Plan
1:1000

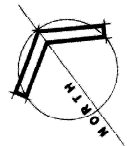

01 Existing Second Floor Plan
1:100

NOTES:

Location: Shed 22
corner of Taranaki & Cable Streets
DP 1660 lots 10,11,12

existing surfaces to be protected contractor or subcontractors to not fix to, damage or alter existing steel trusses, existing brick walls or existing windows unless specifically noted or with the architects prior permission.

WELLINGTON CITY COUNCIL
SERVICE REQUEST No
87445
APPROVED BUILDING
CONSENT DOCUMENTS

W.C.C.
RECORDS
WELLINGTON CITY COUNCIL
ENVIRONMENT
- 1 MAY 2002
RECEIVED
WAKEFIELD ST. WELLINGTON

Dunning Thornton Consultants Ltd
Consulting Engineers
Ph: (644) 385-0018
Fax: (644) 385-0312
PO Box 27-163, Wellington NZ
E-mail: dtd@dmtdunningthornton.co.nz


A Building Consent 22.04.2002

Existing 2nd Floor Plan
scale: 1:100@A1 1:200@A3

NZ Breweries Fitout 01-51
Second Floor Shed 22

athfield architects limited
po box 3364 Wellington
ph 04 480 1727
fax 04 480 1680
email: info@athfield.co.nz

A1.1

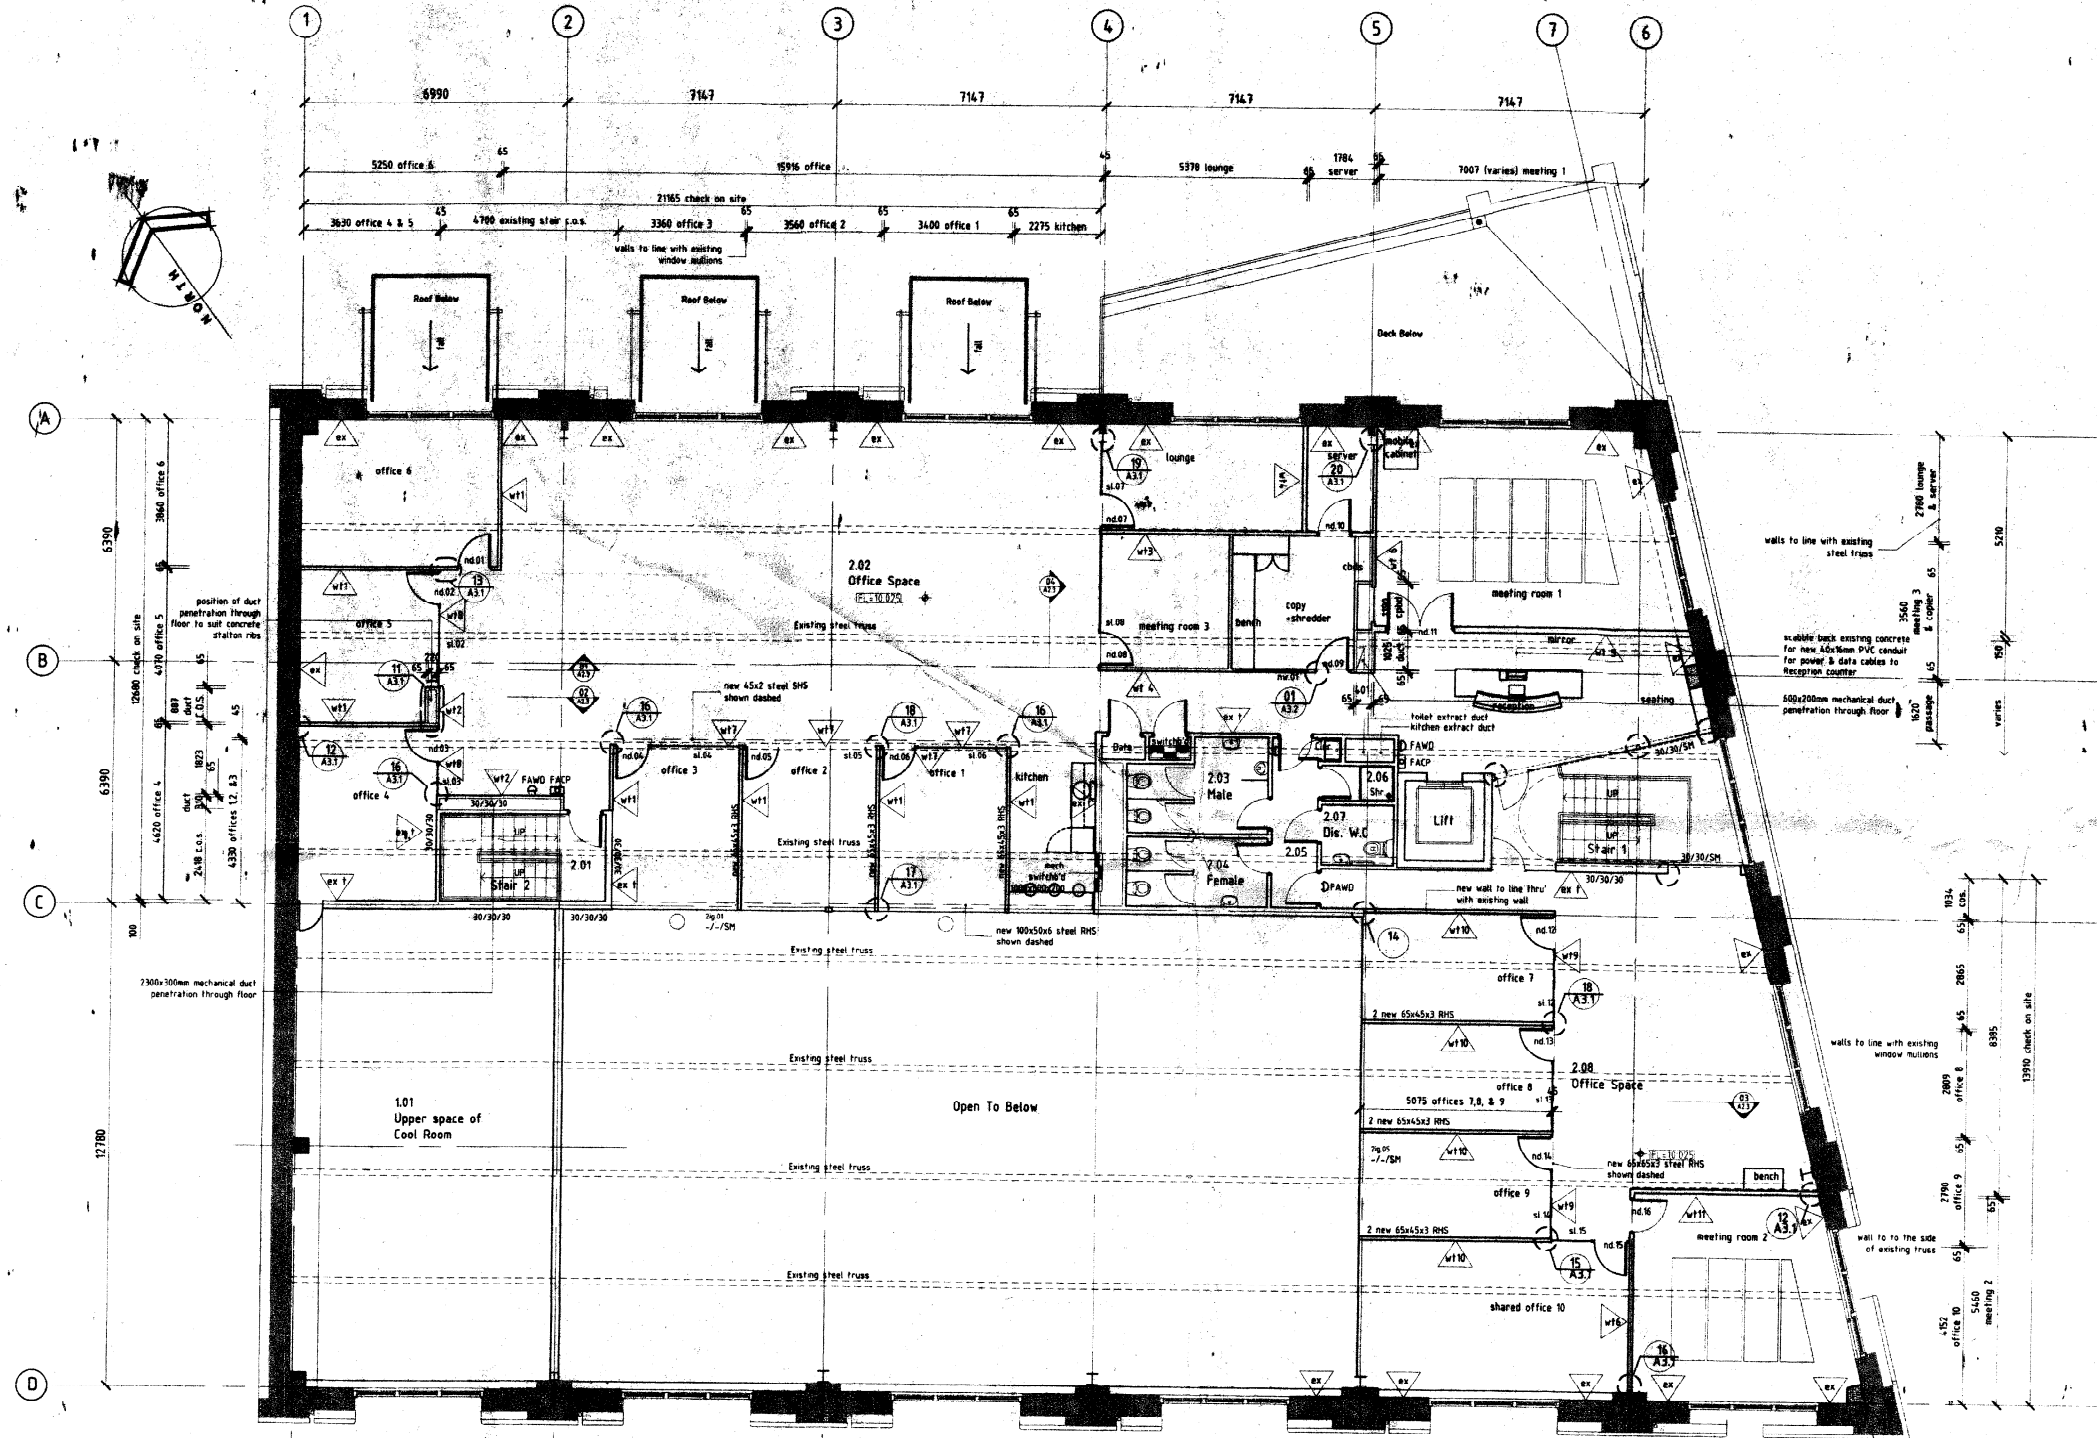

- KEY:**
- Wall type marker - Refer to drawing A3.1 for construction details
 - Existing brick wall, cleaned back and made good under base building contract
 - Existing timber wall & gip linings
- Fire system legend**
- Fire alarm sounder
 - Fire alarm manual call point

NOTES:

01 Altered Second Floor Plan
2.1 1:100

WELLINGTON CITY COUNCIL
SERVICE REQUEST No
87443
APPROVED BUILDING
CONSENT DOCUMENTS

WELLINGTON CITY COUNCIL
ENVIRONMENT
- 1 MAY 2002
RECEIVED
WAKEFIELD ST, WELLINGTON


Altered Fitout Plan
scale: 1:100@A1 1:200@A3

NZ Breweries Fitout
Second Floor, Shed 22

W.C.C.
RECORDS


athfield architects limited

PO Box 3304 Wellington
ph 04 499 1727
fax 04 499 1500
email info@athfield.co.nz

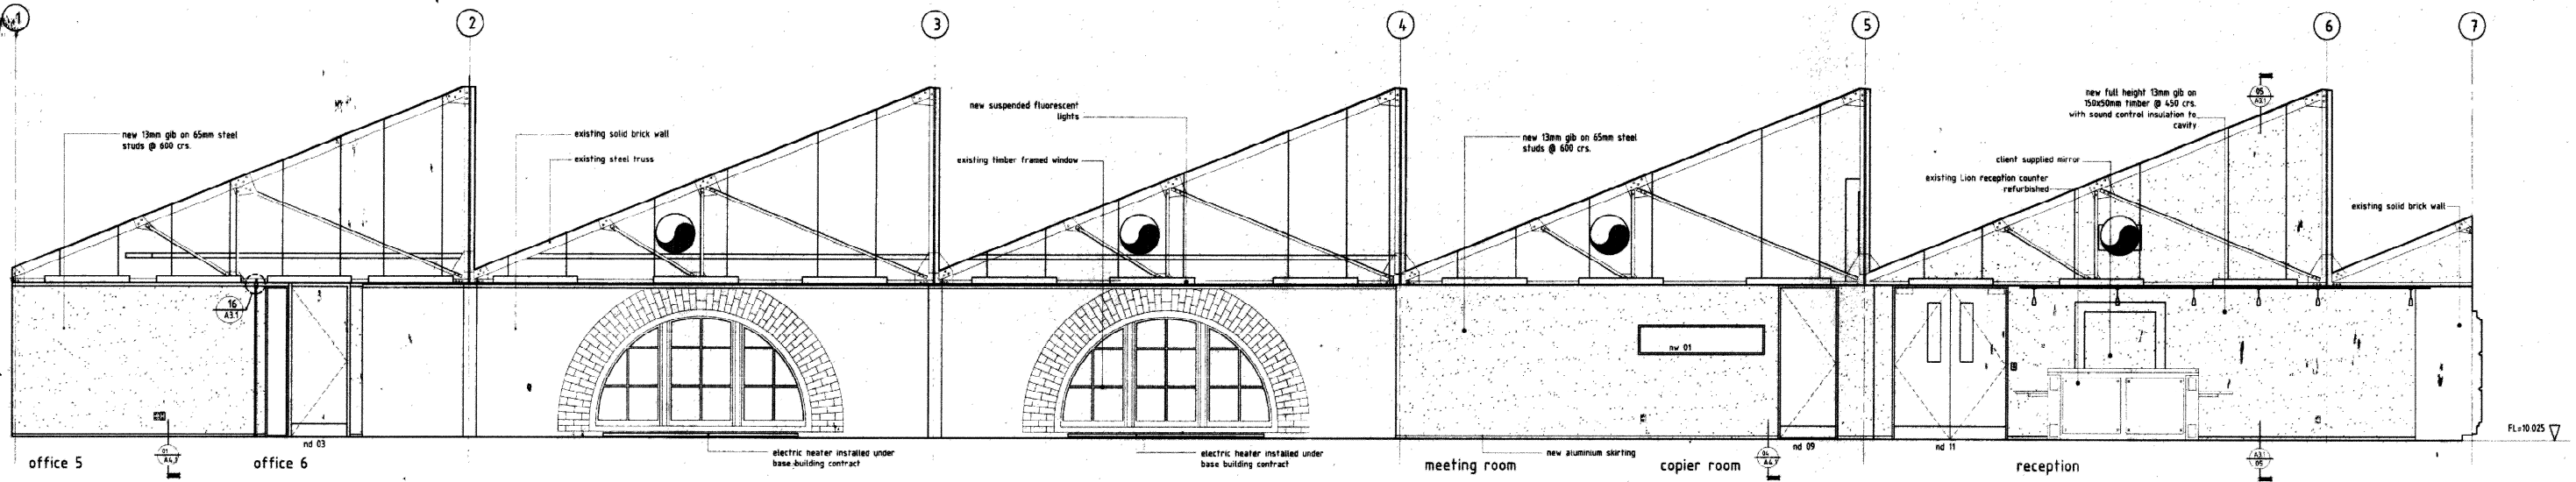


01 Interior Elevation
2.2 1:50


scale 1:50

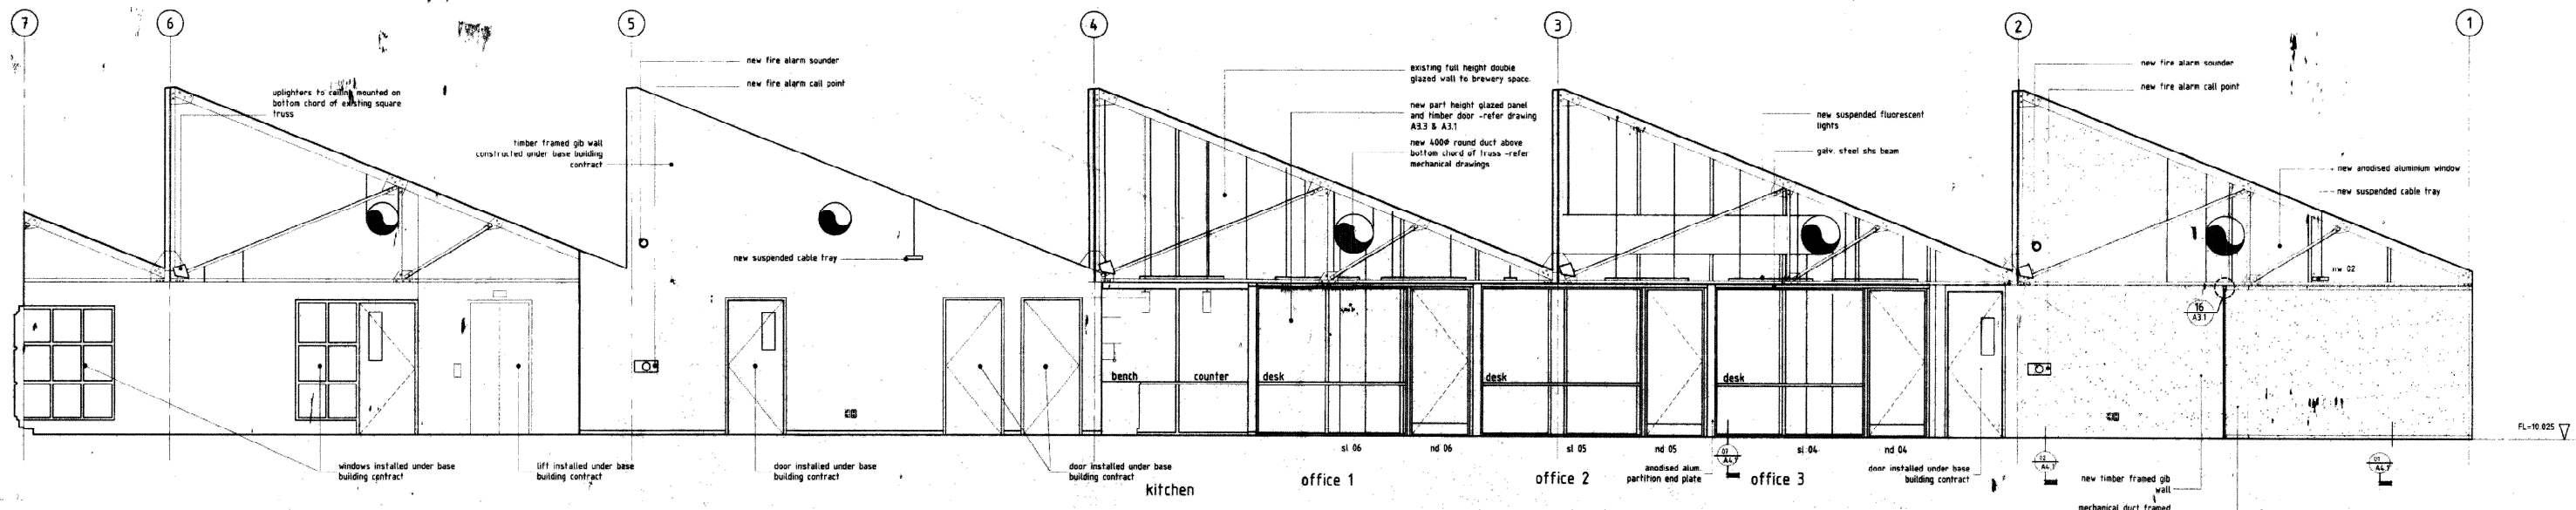


02 Interior Elevation
2.2 1:50

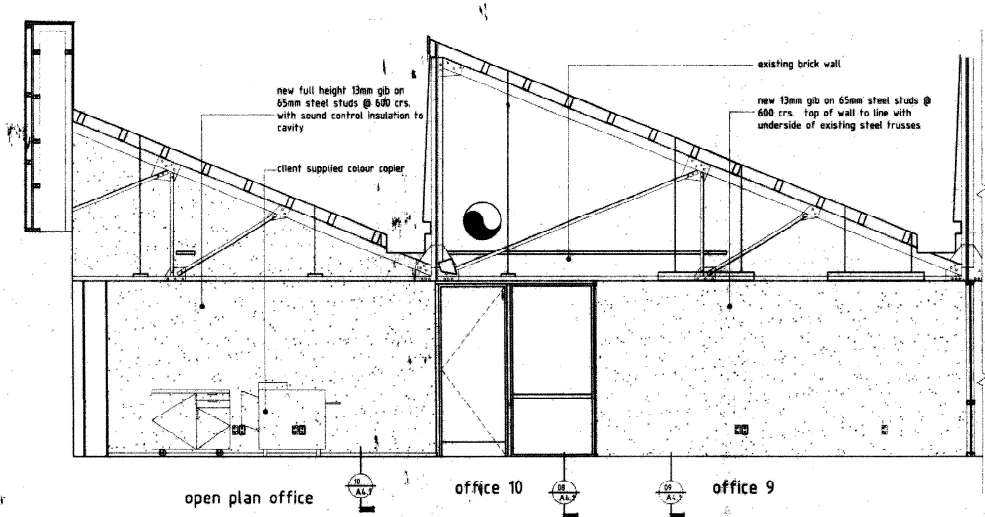

03 Interior Elevation to Office Space 2
2.2 1:50

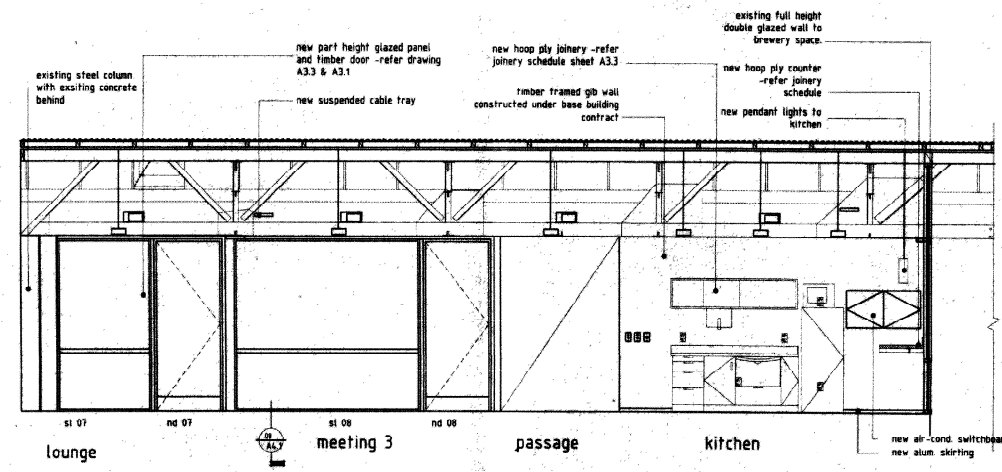

04 Interior Elevation to Main Office Space
2.2 1:50

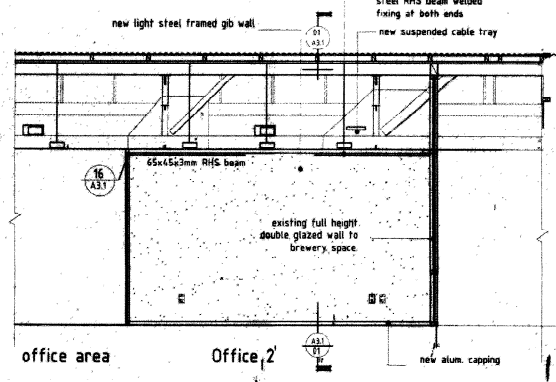

05 Interior Elevation to Office 2
2.2 1:50

Dunning Thornton Consultants Ltd
Consulting Engineers
P.O. Box 1044, Wellington, N.Z.
Tel: (044) 385-0312
Fax: (044) 385-0312
E-mail: dth@dtc.co.nz

W.C.C. RECORDS

WELLINGTON CITY COUNCIL
ENVIRONMENT
- 1 MAY 2002
RECEIVED
WAKEFIELD ST. WELLINGTON

Proposed Internal Elevations
scale: 1:50@A1 1:100@A3

WELLINGTON CITY COUNCIL
SERVICE REQUEST NO. 8740151
NZ Breweries Fitout
Second Floor Shed 22
APPROVED BUILDING
CONSENT DOCUMENTS

athfield architects limited
PO Box 1004 Wellington
PH 04 499 1727
FAX 04 499 1990
mail@athfield.co.nz

A2.2

KEY:

NOTES:

LUMINAIRE LEGEND

Refer to electrical section of specification and Appendix C21A - Luminaire Schedule
Refer to Electrical drawing A4.1 & Elevation drawing A2.3 for switch positions

Contractor to provide detailed breakdown in price including separate price for fittings and installation


Note: exterior, toilets, stair & ground floor foyer lighting specified under separate contract

- Fluorescent: Recessed batten fixture connect back to main switch except for Meeting room lights
- Uplighter: Deltaught - Piano connect back to main switch except for Meeting room lights
- Incandescent: 15m 'Bud' suspended pendant fitting complete with 100W lamps - selected colour shade
- Halogen: Delta Light 'Cocktail' wall mounted to Lounge & Toilet wall, mounted to underside of truss in Reception
- 2x28W TS: Mounted to ceiling

TS Lights suspended @ 2.4m AFFL.
refer to schedule in electrical section of specification for location of each type

- 1x28W TS: Suspended wire type
- 2x28W TS: Suspended wire type
- 1x35W TS: Suspended wire type
- 2x35W TS: Suspended wire type

Dunning Thornton Consultants Ltd
Consulting Engineers
P.O. Box 27-153 Wellington NZ
E-mail: dth@dtconsultants.co.nz

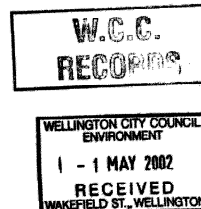


Proposed Internal Elevations
scale: 1:50@A1 1:100@A3


NZ Breweries Fitout
Second Floor Shed 22

WELLINGTON CITY COUNCIL SERVICE REQUEST NO 87443
APPROVED BUILDING CONSENT DOCUMENT

Wakefield architects limited
PO Box 3304 Wellington
04 499 1727
04 499 1960
mail@wakefieldarchitects.co.nz

A2.3

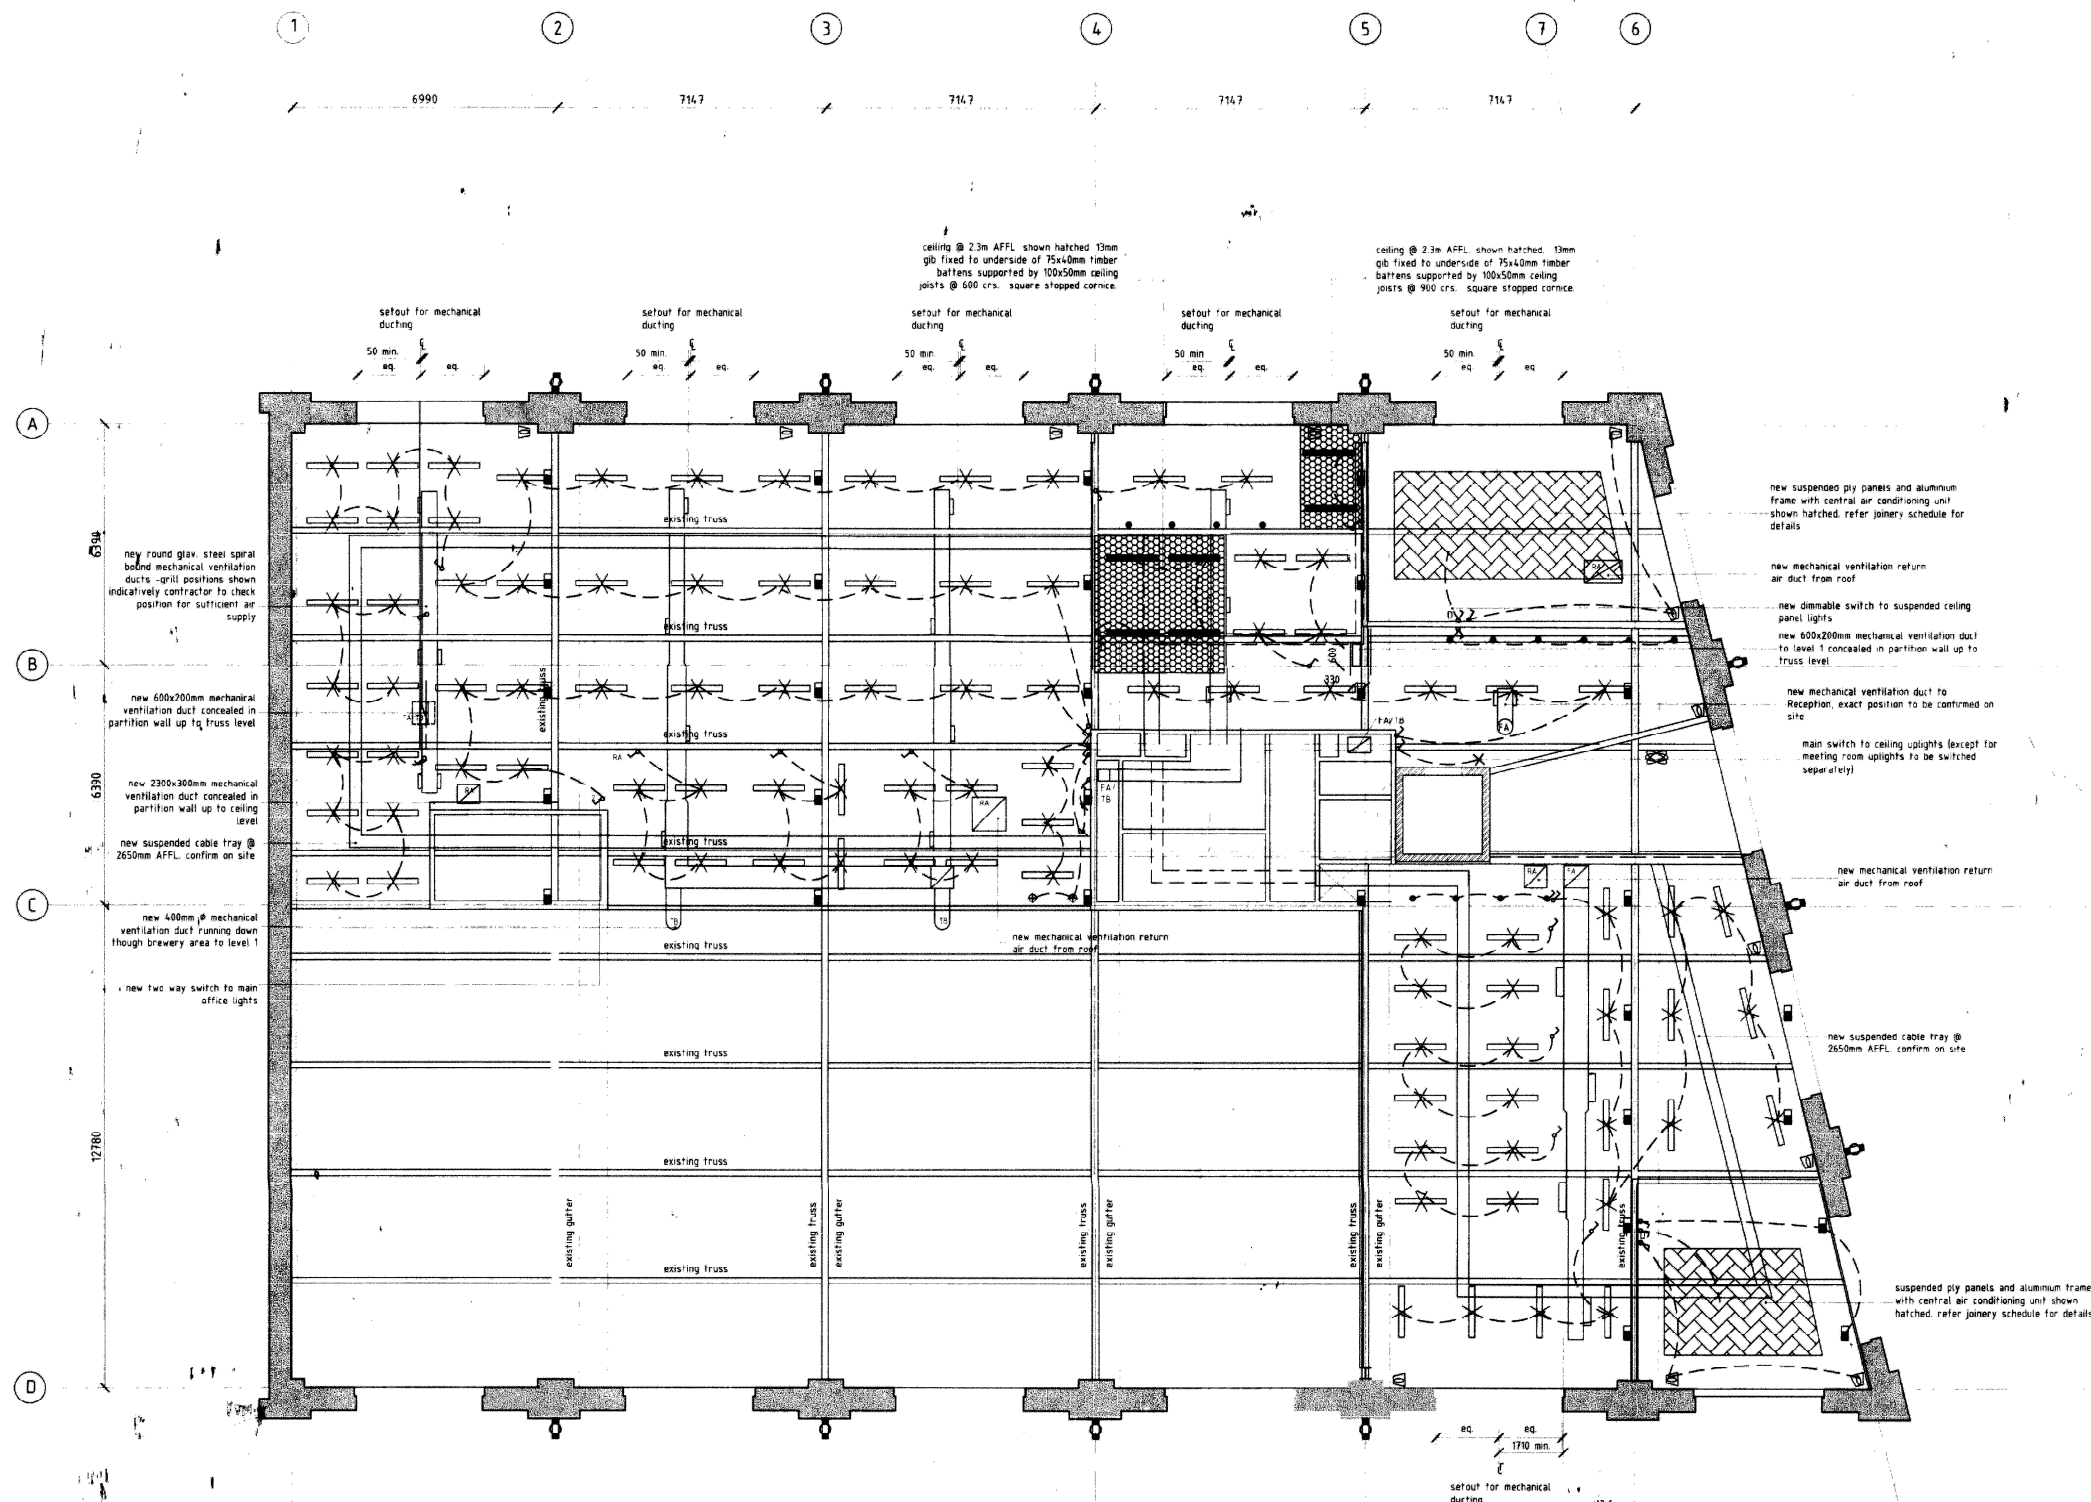

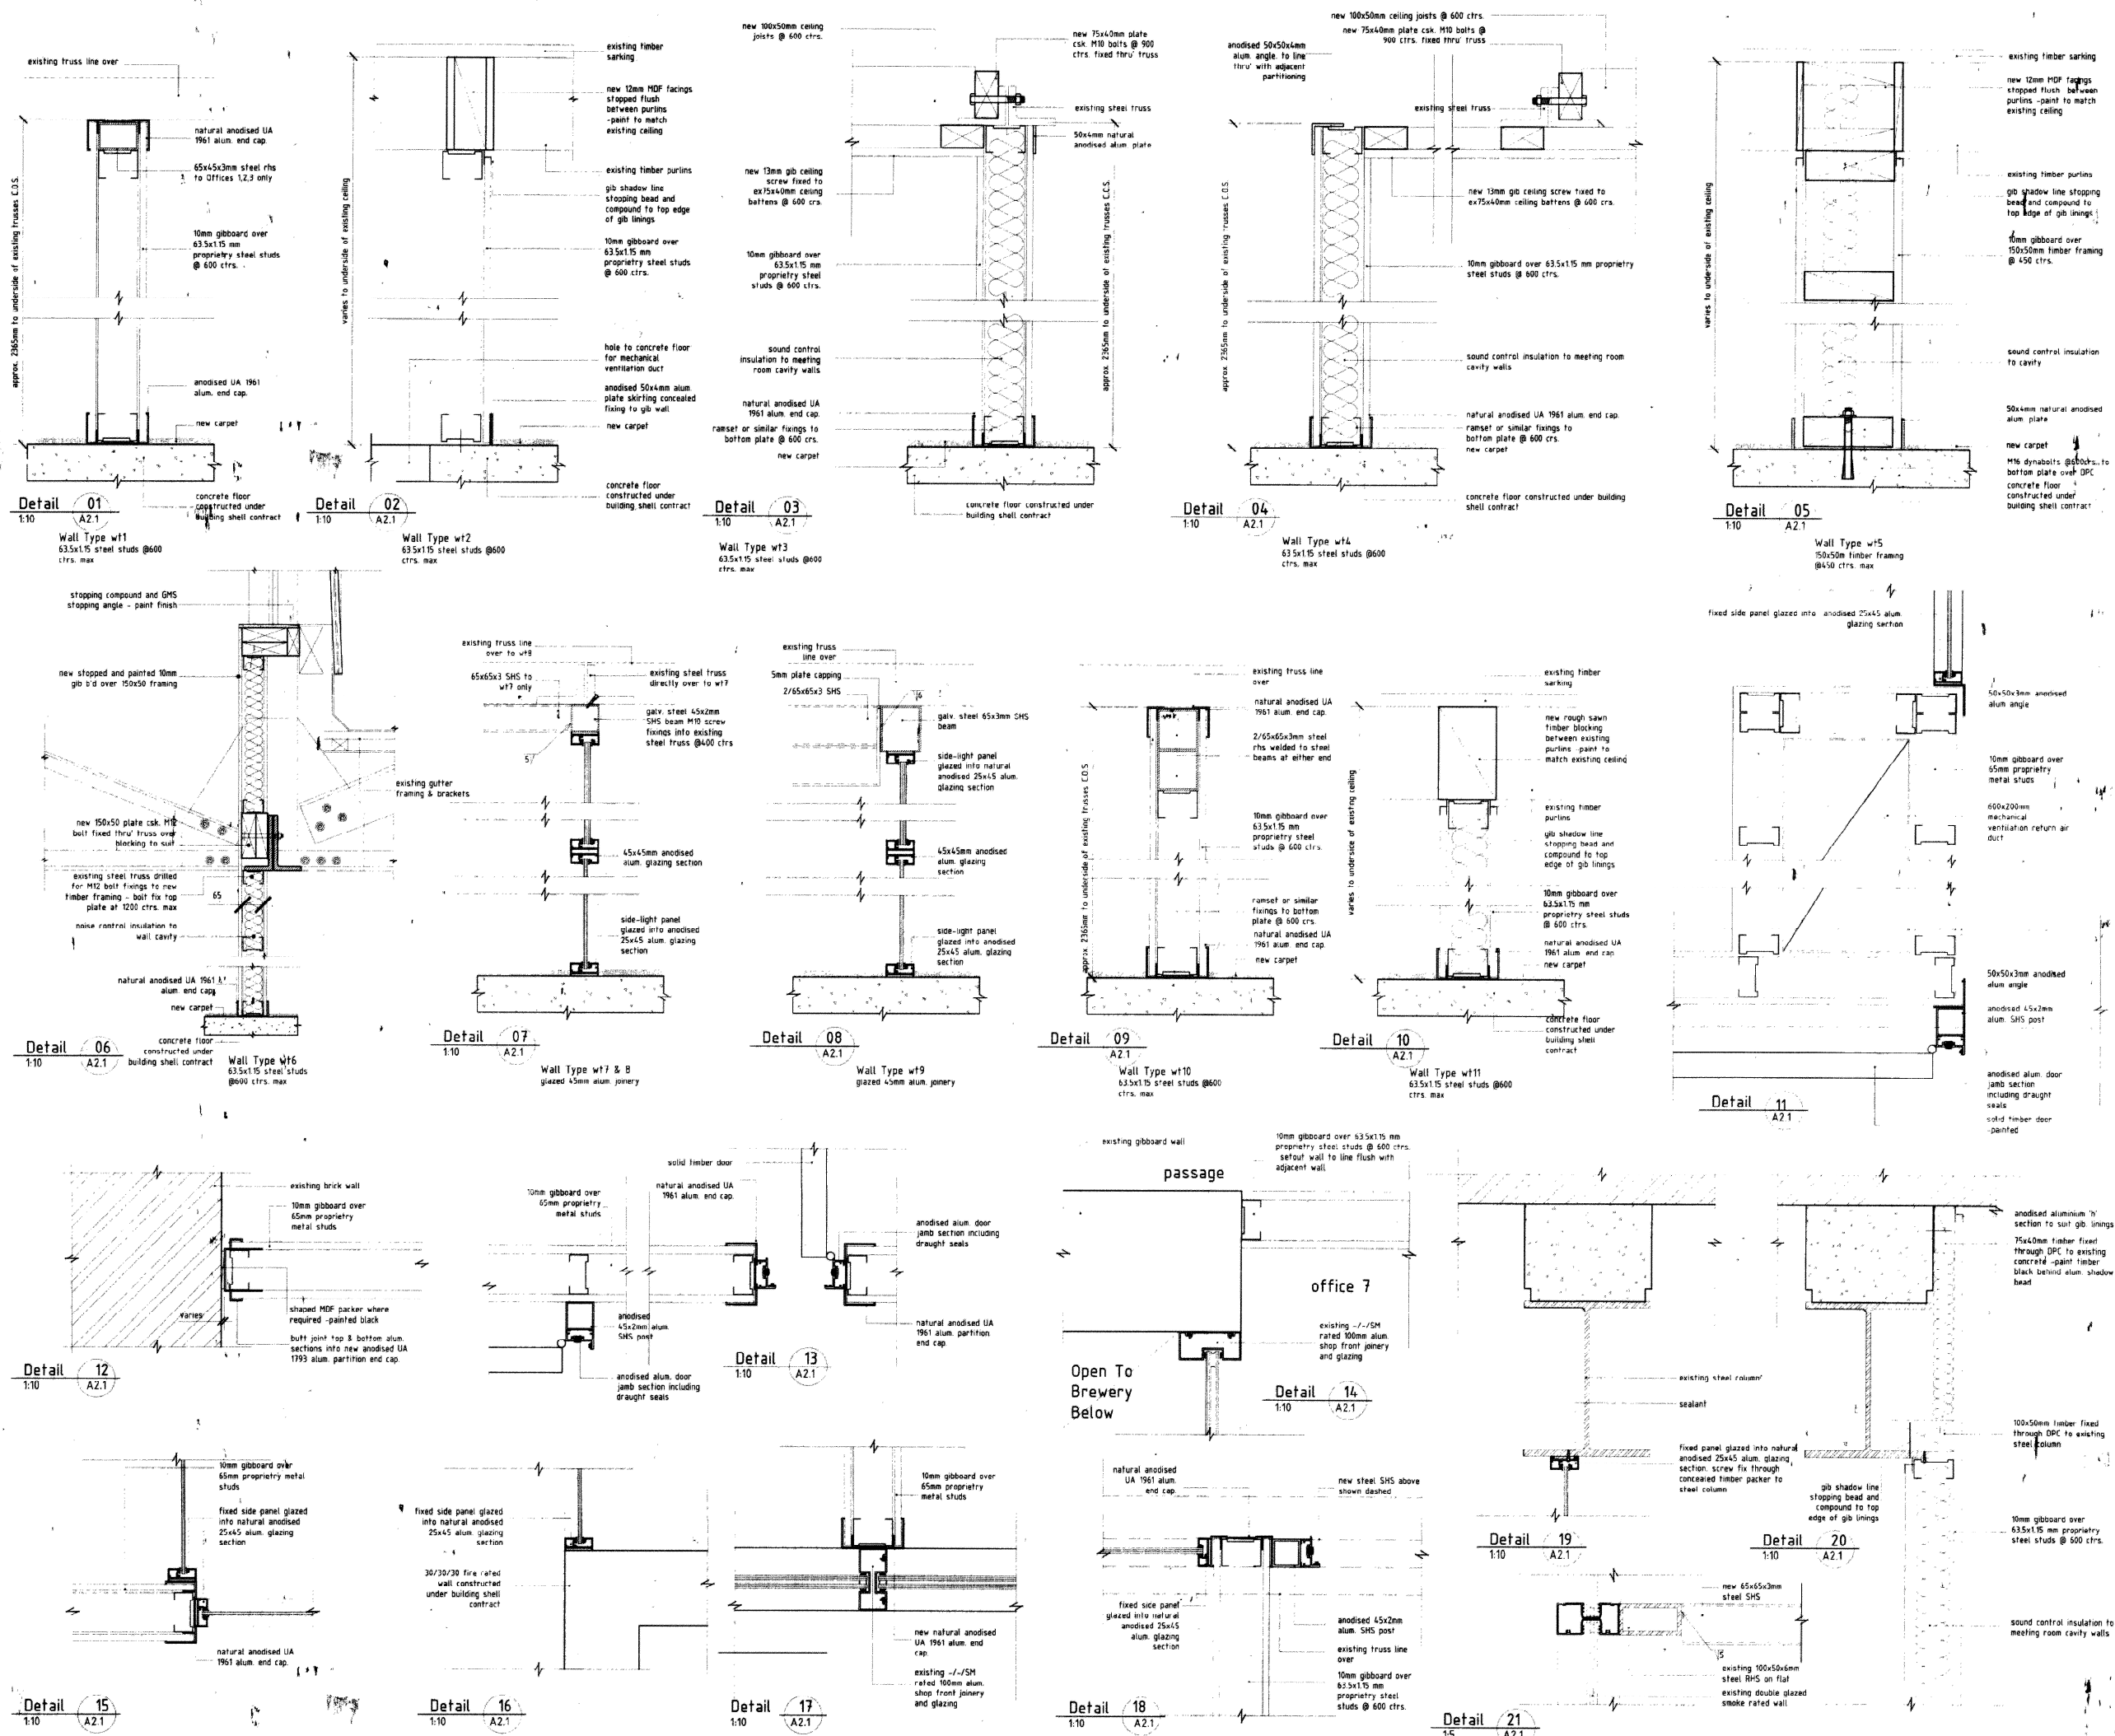

KEY

NOTES

Dunning Thornton Consultants Ltd
Consulting Engineers
Ph: (044) 385-0019
Fax: (044) 385-0312
PO Box 27 103, Wellington, NZ
E-mail: dth@dnthornton.co.nz






W.C.C. RECORD


WELLINGTON CITY COUNCIL ENVIRONMENT
1 - 1 MAY 2002
RECEIVED
WAKEFIELD ST., WELLINGTON

Details
scale: 1:5 @ A1 1:10 @ A2.1
WELLINGTON CITY COUNCIL
SERVICE REQUEST NO
NZ Breweries Fitout 874 403-51
Second Floor Shed 22
APPROVED BUILDING
CONSENT DOCUMENTS


athfield architects limited
po box 3304 Wellington
ph: 04 499 1727
fax: 04 499 1800
mail@athfieldarchitects.co.nz

A3.1

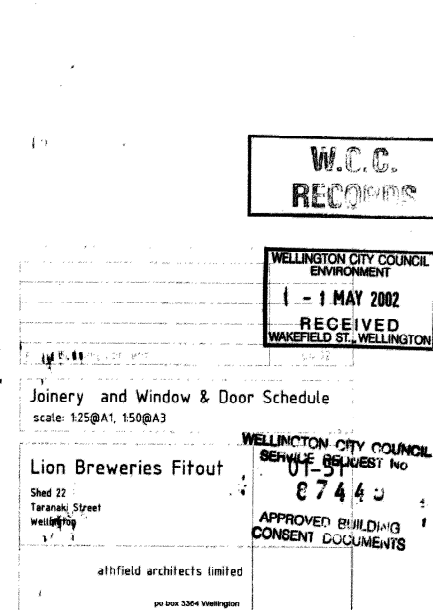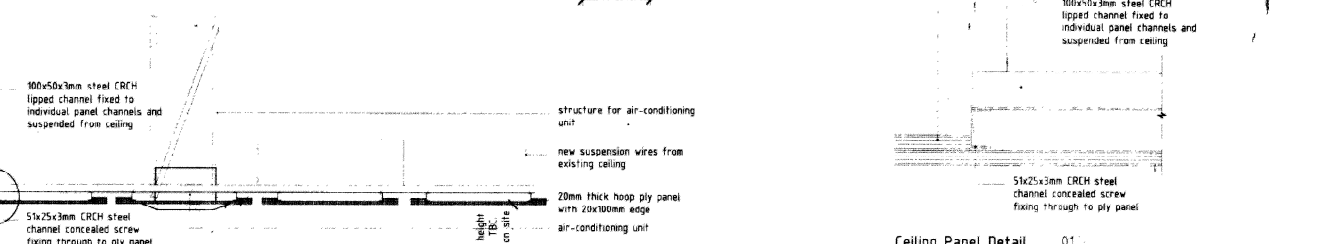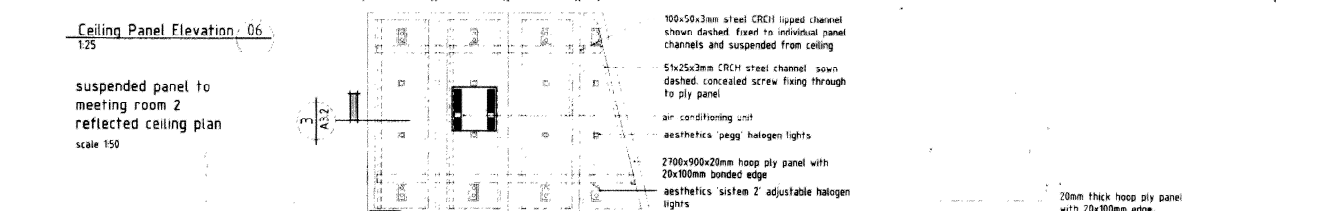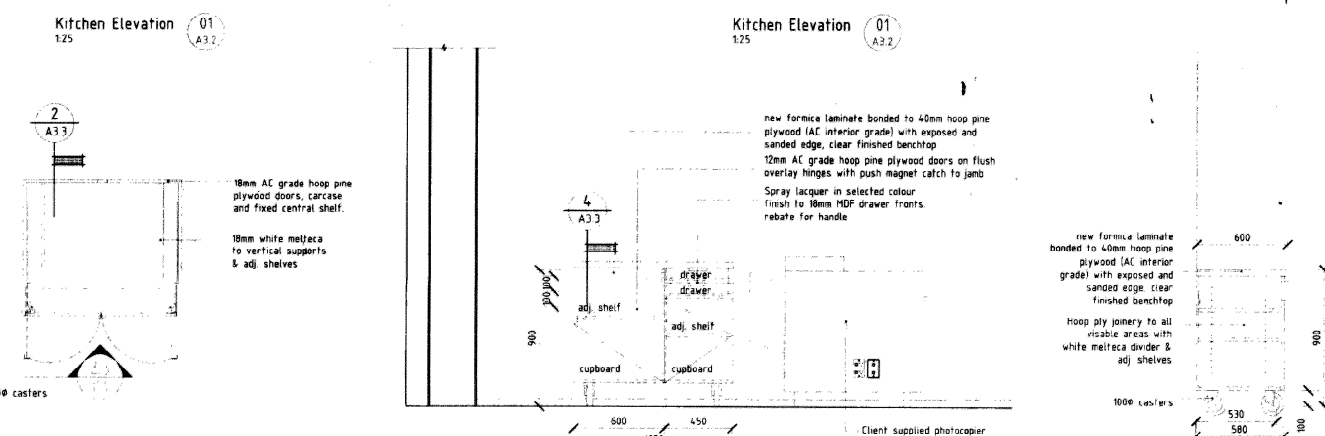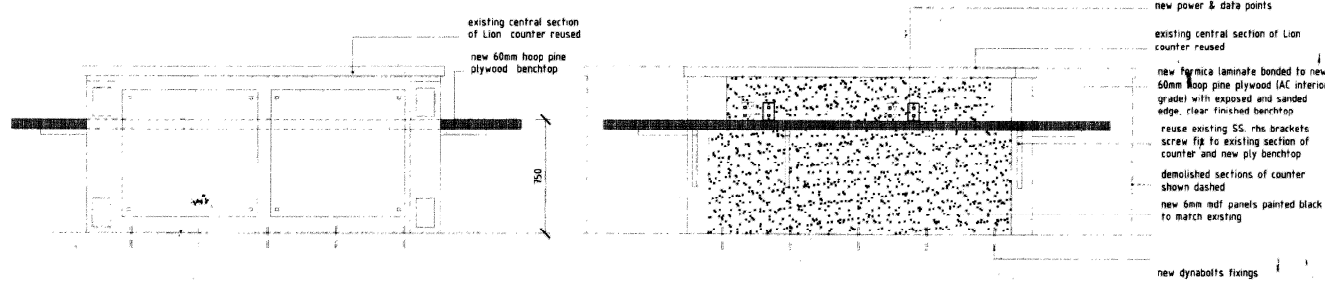


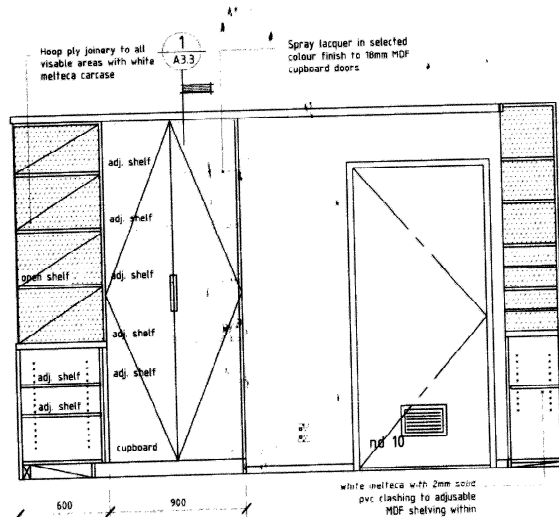


Copier Room Elevation 01
125 A3.3

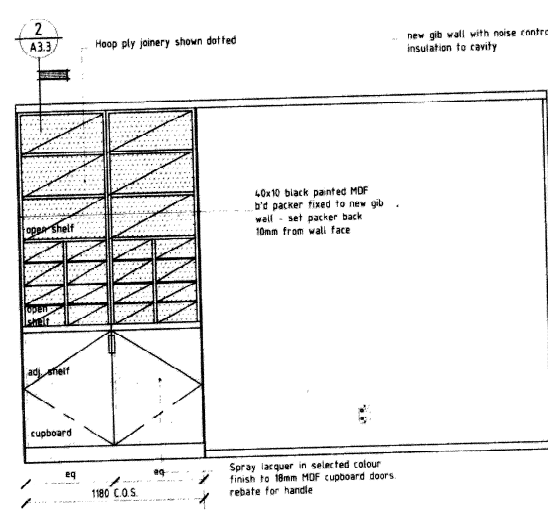


Copier Room Elevation 02
125 A3.3

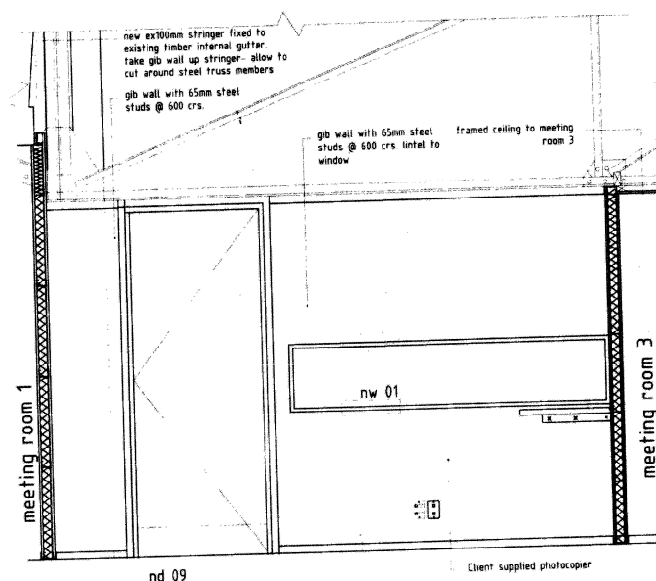


Copier Room Elevation 03
125 A3.3

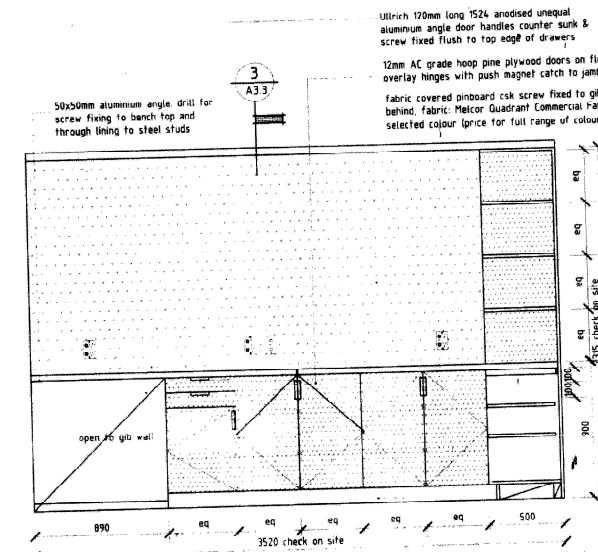


Copier Room Elevation 04
125 A3.3

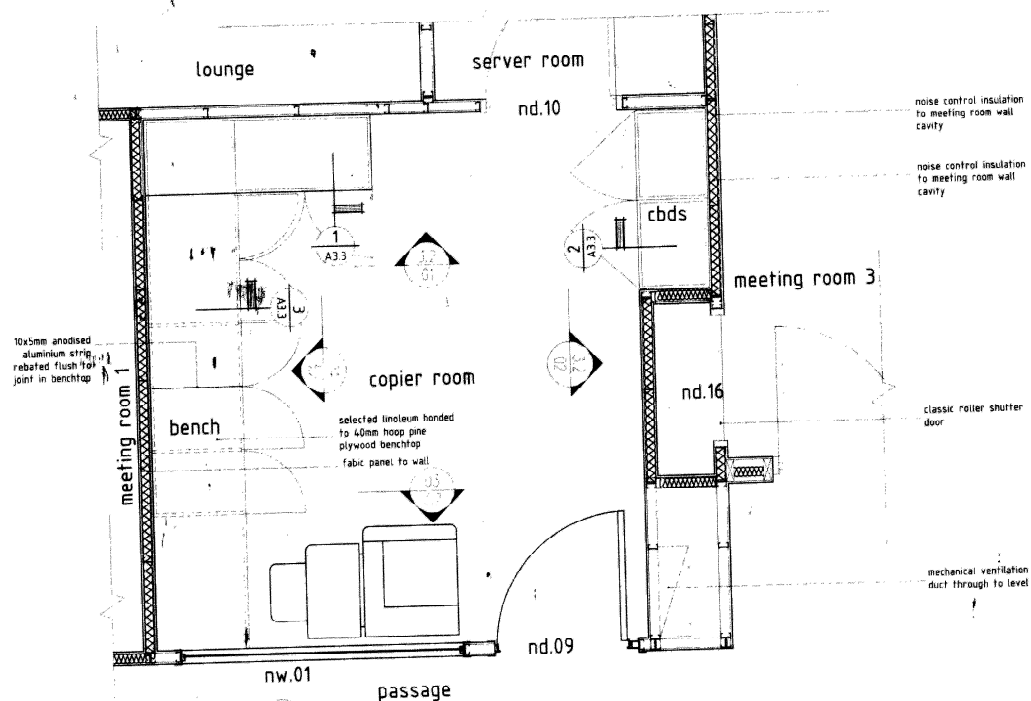


Copier Room Plan 01
125 A3.3

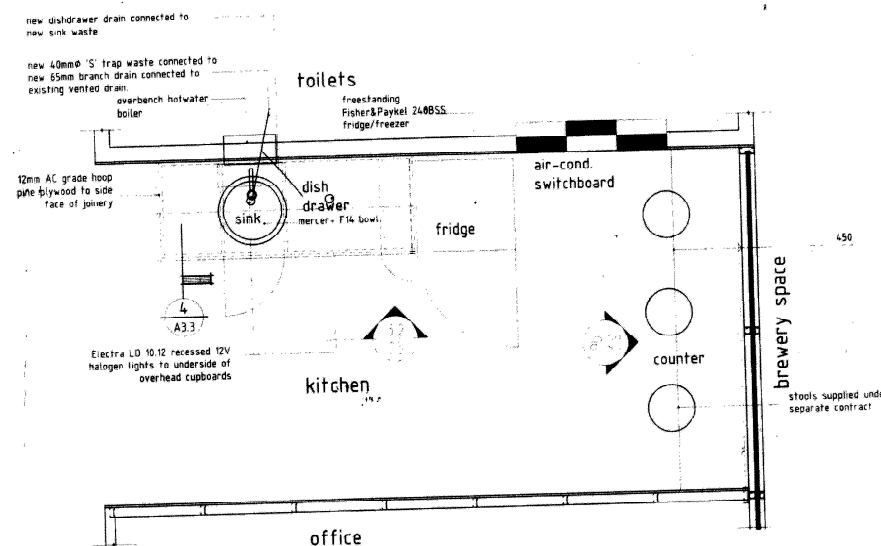


Kitchen Plan 02
125 A3.3

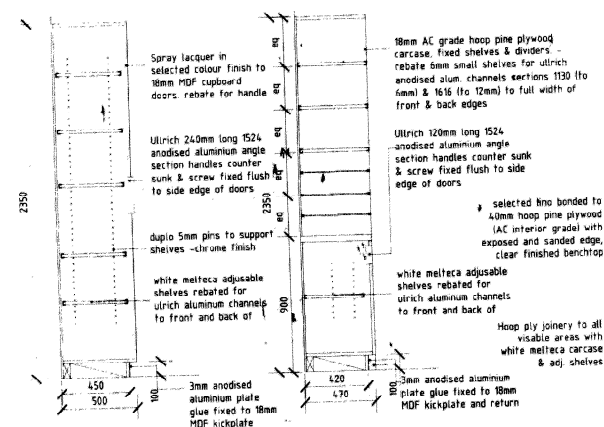


Section 1
125 A3.2

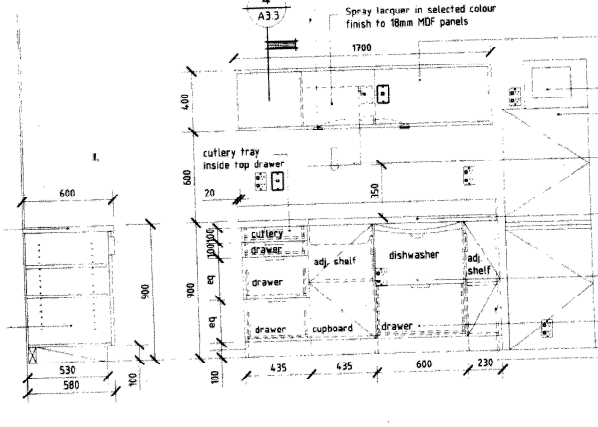


Section 2
125 A3.3

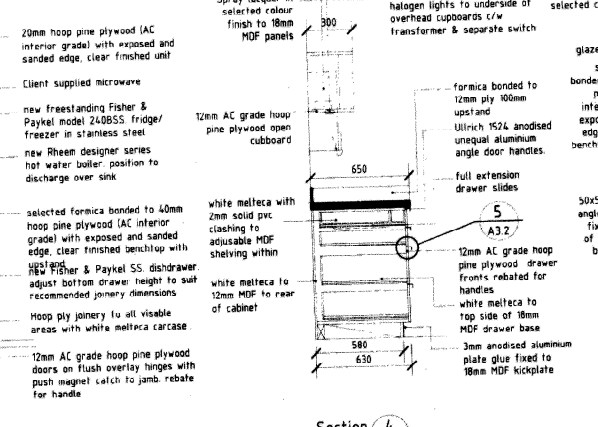


Section 3
125 A3.3

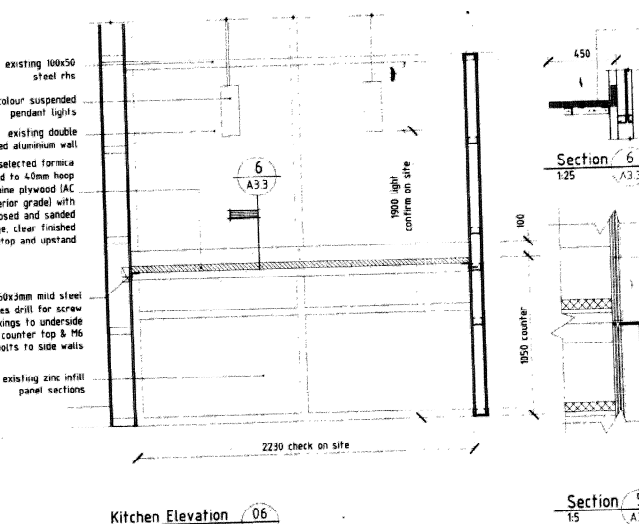

Section 4
125 A3.3

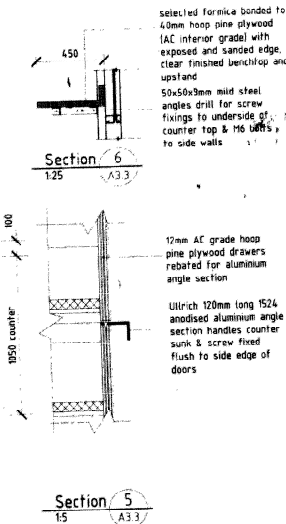

Section 5
125 A3.3

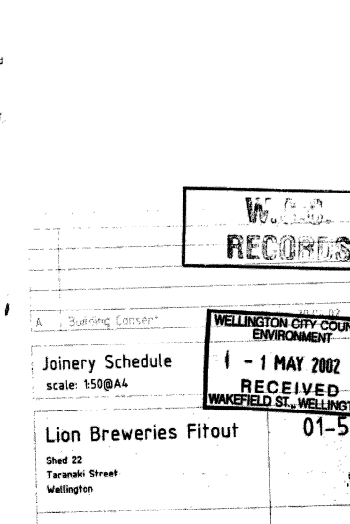

Section 6
125 A3.3

KEY:

NOTES:

Electrical Legend


PDL 600 series Double power outlet - c/w stainless steel cover plates

PDL 600 series Double Data or phone outlets - c/w stainless steel cover plates

PDL 600 series Light switch fuse actuator switch to aluminum post - c/w stainless steel cover plates

PDL 600 series Light switch with dimmer (connect to ceiling panel lights) - c/w stainless steel cover plates

Dunning Thornton Consultants Ltd
Consulting Engineers
Ph: (044) 385-0016
Fax: (044) 385-0312
PO Box 271151, Wellington NZ
E-mail: dth@dnthornton.co.nz

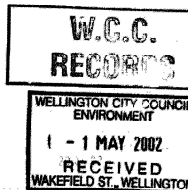

Building Consent

Proposed Electrical Plan
scale: 1:100@A1 1:200@A3

01-51

WELLINGTON CITY COUNCIL
SERVICE REQUEST NO


87445


APPROVED BUILDING
CONSENT DOCUMENTS

3364 Wellington
ph 04 499 1727
fax 04 499 1900
mail@cityofwellington.co.nz

A4.1

Electrical Plan
1:100

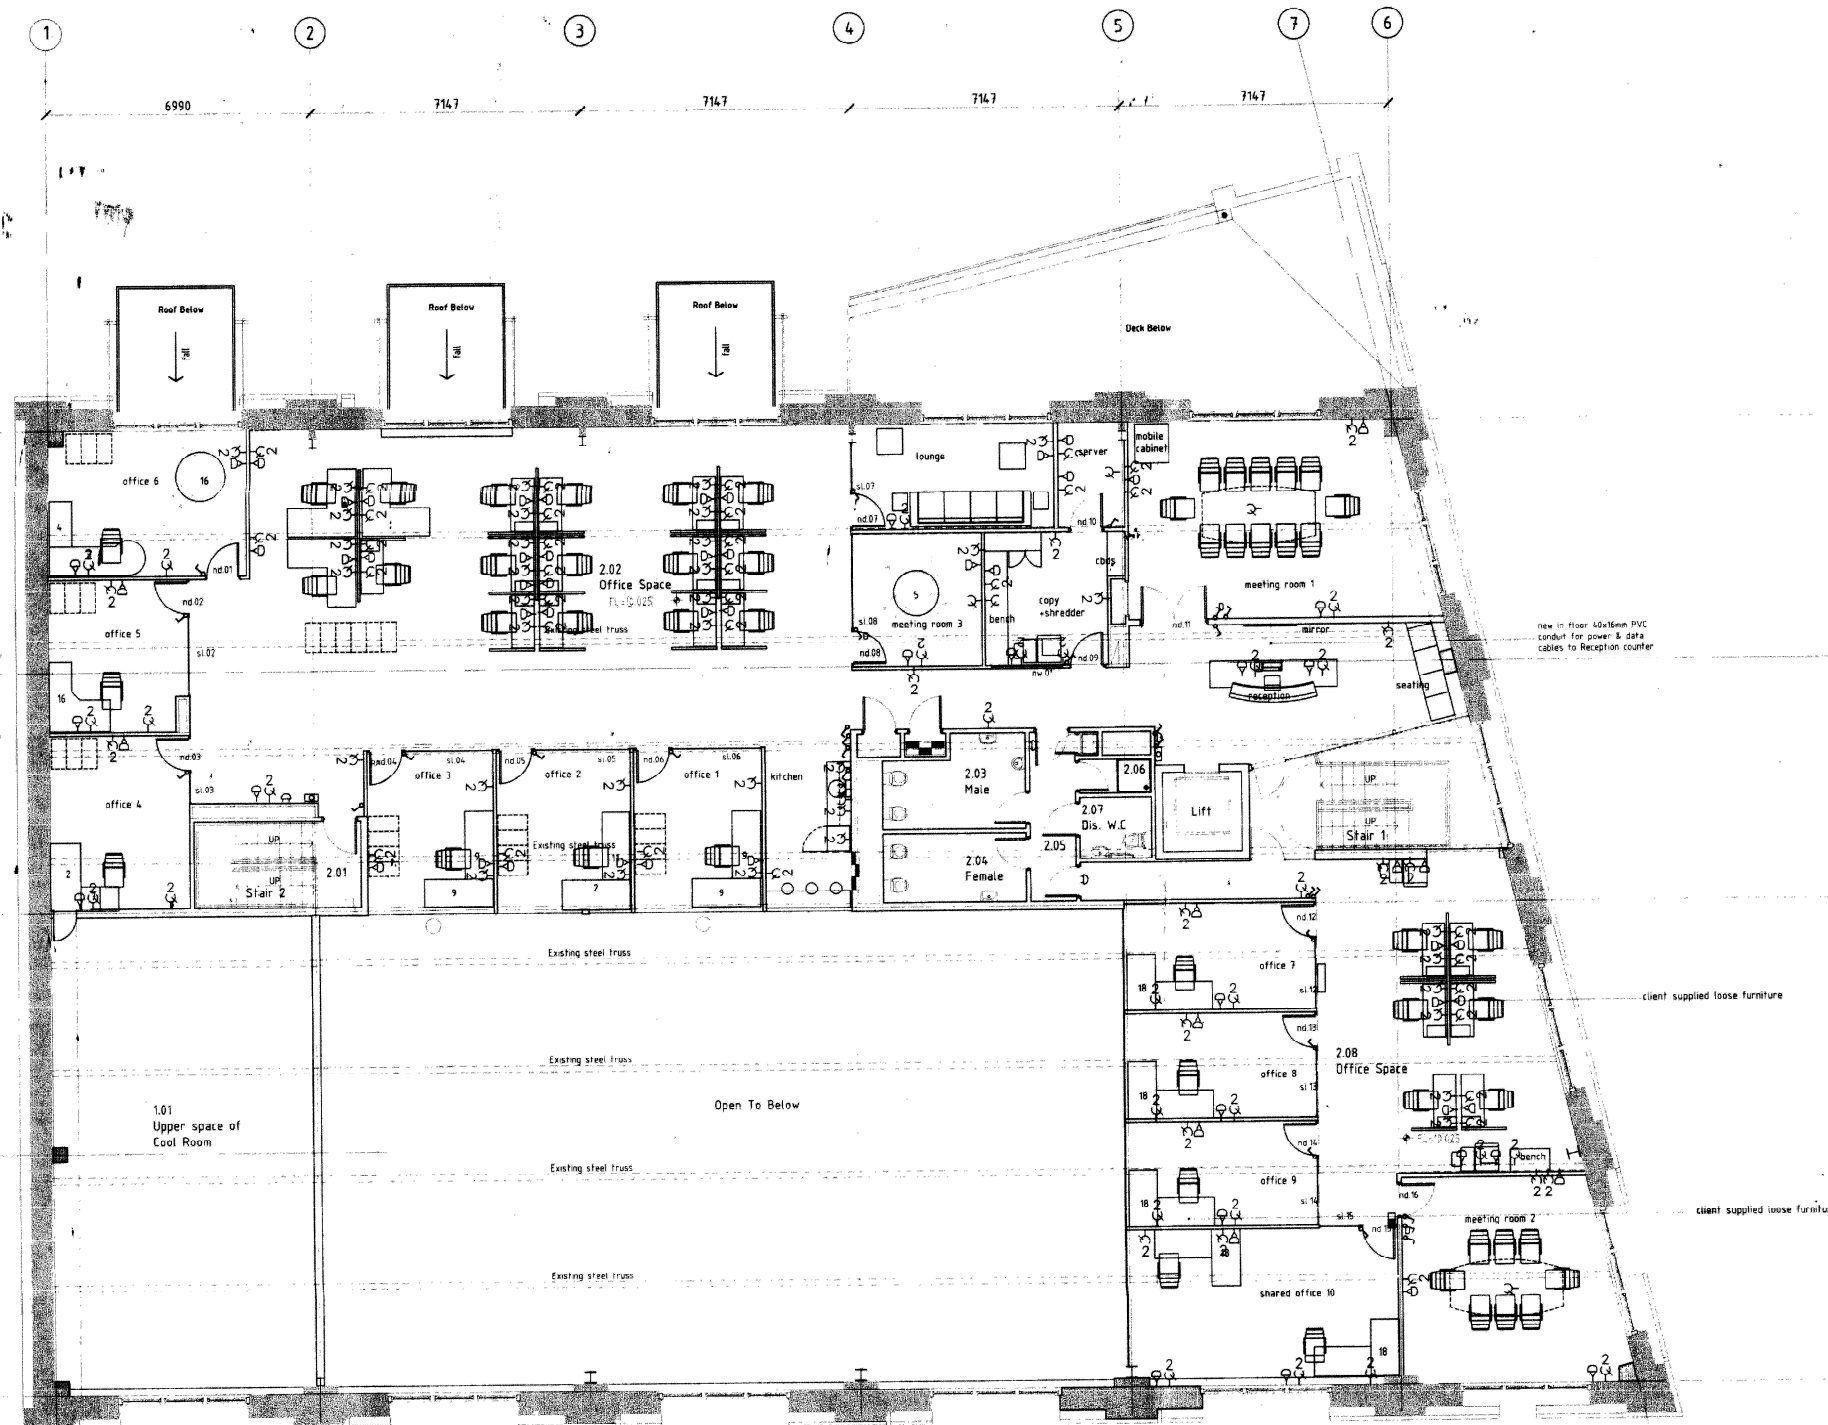

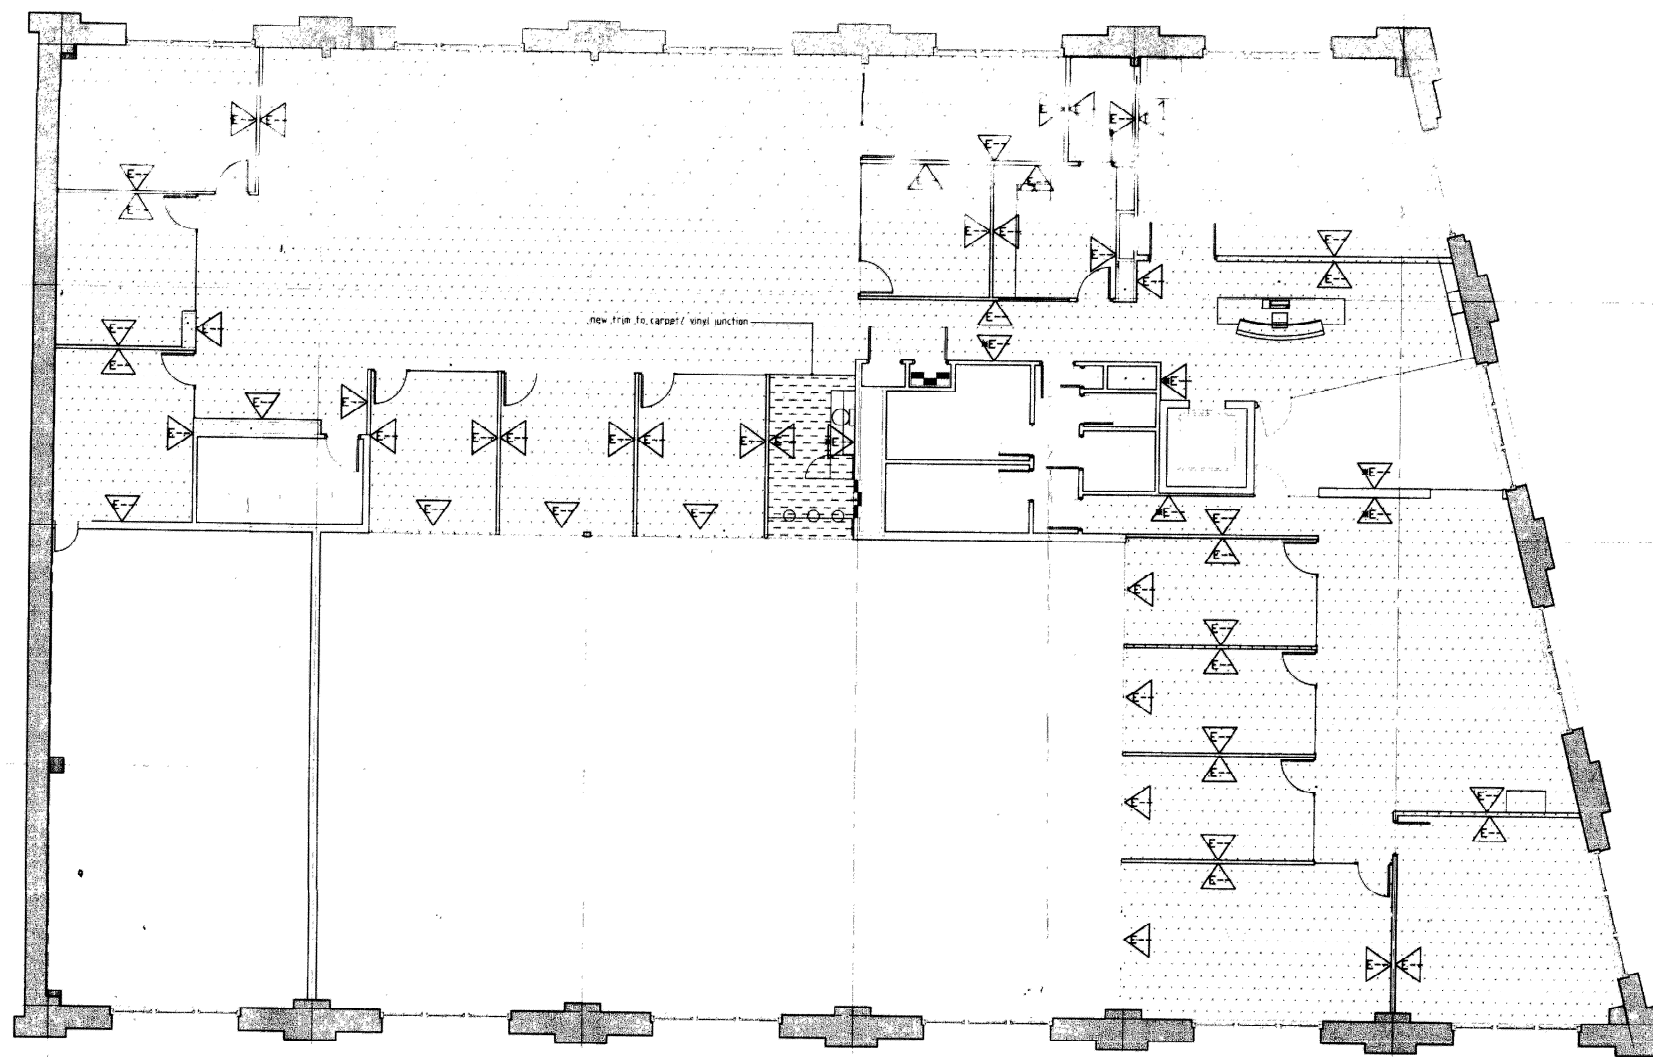

NOTES:

- all new interior doors for fitout requiring paint finish to be G--
- fitout colours to be confirmed
- for finishes to joinery units refer A3.2 / A3.3
- bathroom and lobby area finishes specified under separate contract
- all finish indicators marked with an * are under separate contract
- all brickwork, steelwork and ceiling finishes are to be specified under separate contract.

FINISHES KEY

Legend:

- ALL FINISH * - COLOUR
- SELECTED FLOORING

Finish Types:

10 Match Resene Spec Diagrams

- NL NO FINISH
- A RESENE AQUAPEL
- B RESENE SPECIAL EPOXY*
- C RESENE ENAMACRYL
- D RESENE IMPERITE
- E RESENE ZYLONE SHEEN
- F RESENE ZYLONE 20
- G RESENE LUSTACRYL
- H RESENE RESITEX STANDARD
- I RESENE PLATECODE
- J RESENE LUMBERSIDER
- K RESENE MULTI-SHIELD
- L RESENE MICARONI*
- M RESENE MICABOND*

Colours:

10 Match Resene Colour Chart

- 01 CLEAR
- 02 RESENE MONTANA
- 03 RESENE IEA
- 04 RESENE NAPA
- 05 RESENE CONCRETE
- 06 RESENE MASALA
- 07
- 08
- 09
- 10
- 11
- 12
- 13
- 14
- 15

Floor Finishes

- 20mm subfloor or 100mm solid
- golf tray finish 400 x 400 square driftwood

01 Finishes Plan
5:1 1:100

Dunning Thornton Consultants Ltd
Consulting Engineers
PO Box 188-078
Fax: 0441 385-072
20, New 35-083 Wellington NZ
E-mail: dtw@dtwconsultants.co.nz

WELLINGTON CITY COUNCIL
SERVICE REQUEST No

87445

APPROVED BUILDING
CONSENT DOCUMENTS

WELLINGTON CITY COUNCIL
ENVIRONMENT

1 - 1 MAY 2002

RECEIVED
WAKEMAN ST, WELLINGTON

A Building Consent

Level 2 Fitout Finishes

scale: 1:100@A1 1:200@A3

NZ Breweries Fitout

Second Floor, Shed 22

W.01-01
RECORDS

athfield architects limited

20 New 3584 Wellington
21 New 499 1929
Fax: 04 499 1929
mail@athfieldarchitects.co.nz

A5.1