


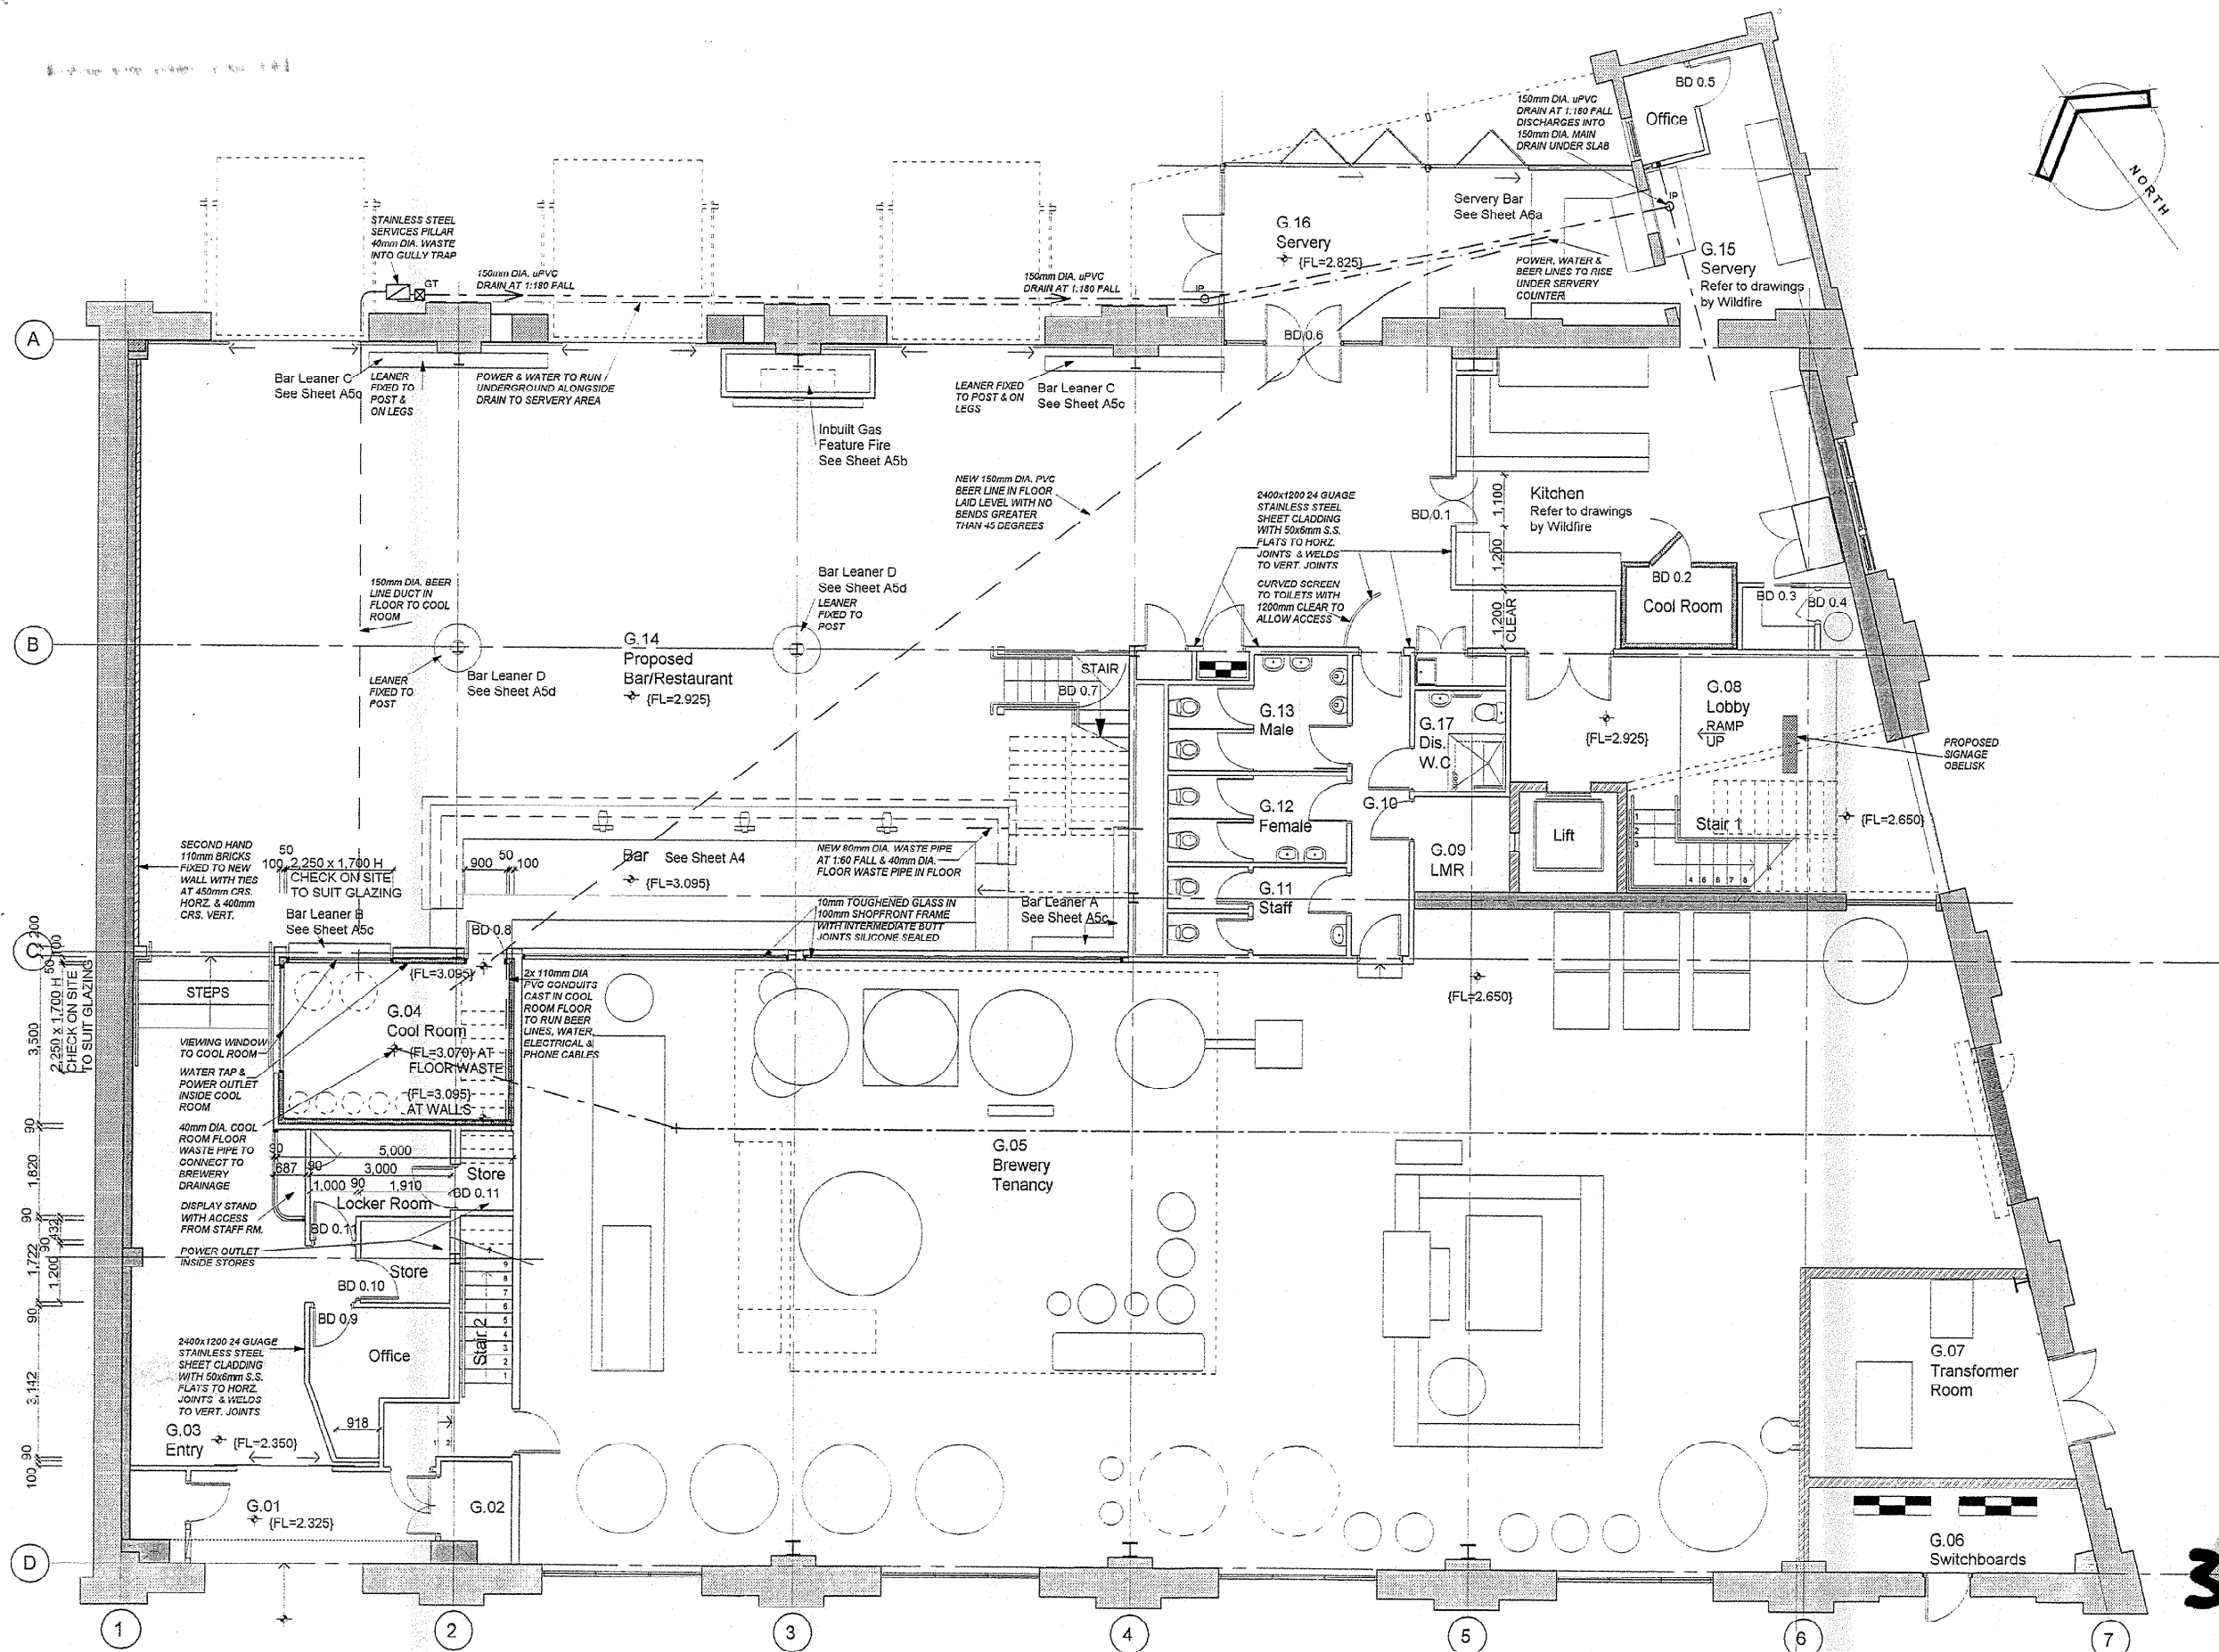

WELLINGTON CITY COUNCIL
SERVICES REQUEST NO

90586

APPROVED BUILDING
CONSENT DOCUMENTS

**W.C.C.
RECORDS**

WELLINGTON CITY COUNCIL
ENVIRONMENT
10 JUL 2002
RECEIVED
WAKEFIELD ST., WELLINGTON



66 mandeville street . p o box 36210 . christchurch . new zealand
ph 64 3 343 6556 . fax 64 3 343 6566 . email info@3baldmen.co.nz

CONTRACTOR SHALL CHECK ALL DIMENSIONS PRIOR TO COMMENCING WORK
THIS DRAWING IS CONFIDENTIAL FOR SECURITY & COPYRIGHT

WARREN ARCHITECTURAL DESIGN


DIRECTOR :
PHONE/FAX :
EMAIL :
ADDRESS :

SCALE :
DATE :
FILE :

A1

SHED 22 - WELLINGTON

REVISION	DESCRIPTION	DATE
6	ADD NOTES & WINDOW TO COOL ROOM, AMEND STEPS	24/06/02
5	AMEND BRICK WALLS, REMOVE RAMP, SEATING & STAGE	04/06/02
4	ADD STAIR HANDRAILS, AMEND SEATING & COOL RM WINDOW	30/04/02
3	ADD GRIDS, AMEND WINDOW WALL	19/04/02
2	ADD STAIR & BREWERY, AMEND BAR LENGTH & COOL RM WINDOWS	05/04/02
1	ADD DIMENSIONS & NOTES, AMEND BAR WALL, BREWERY & KITCHEN	05/03/02

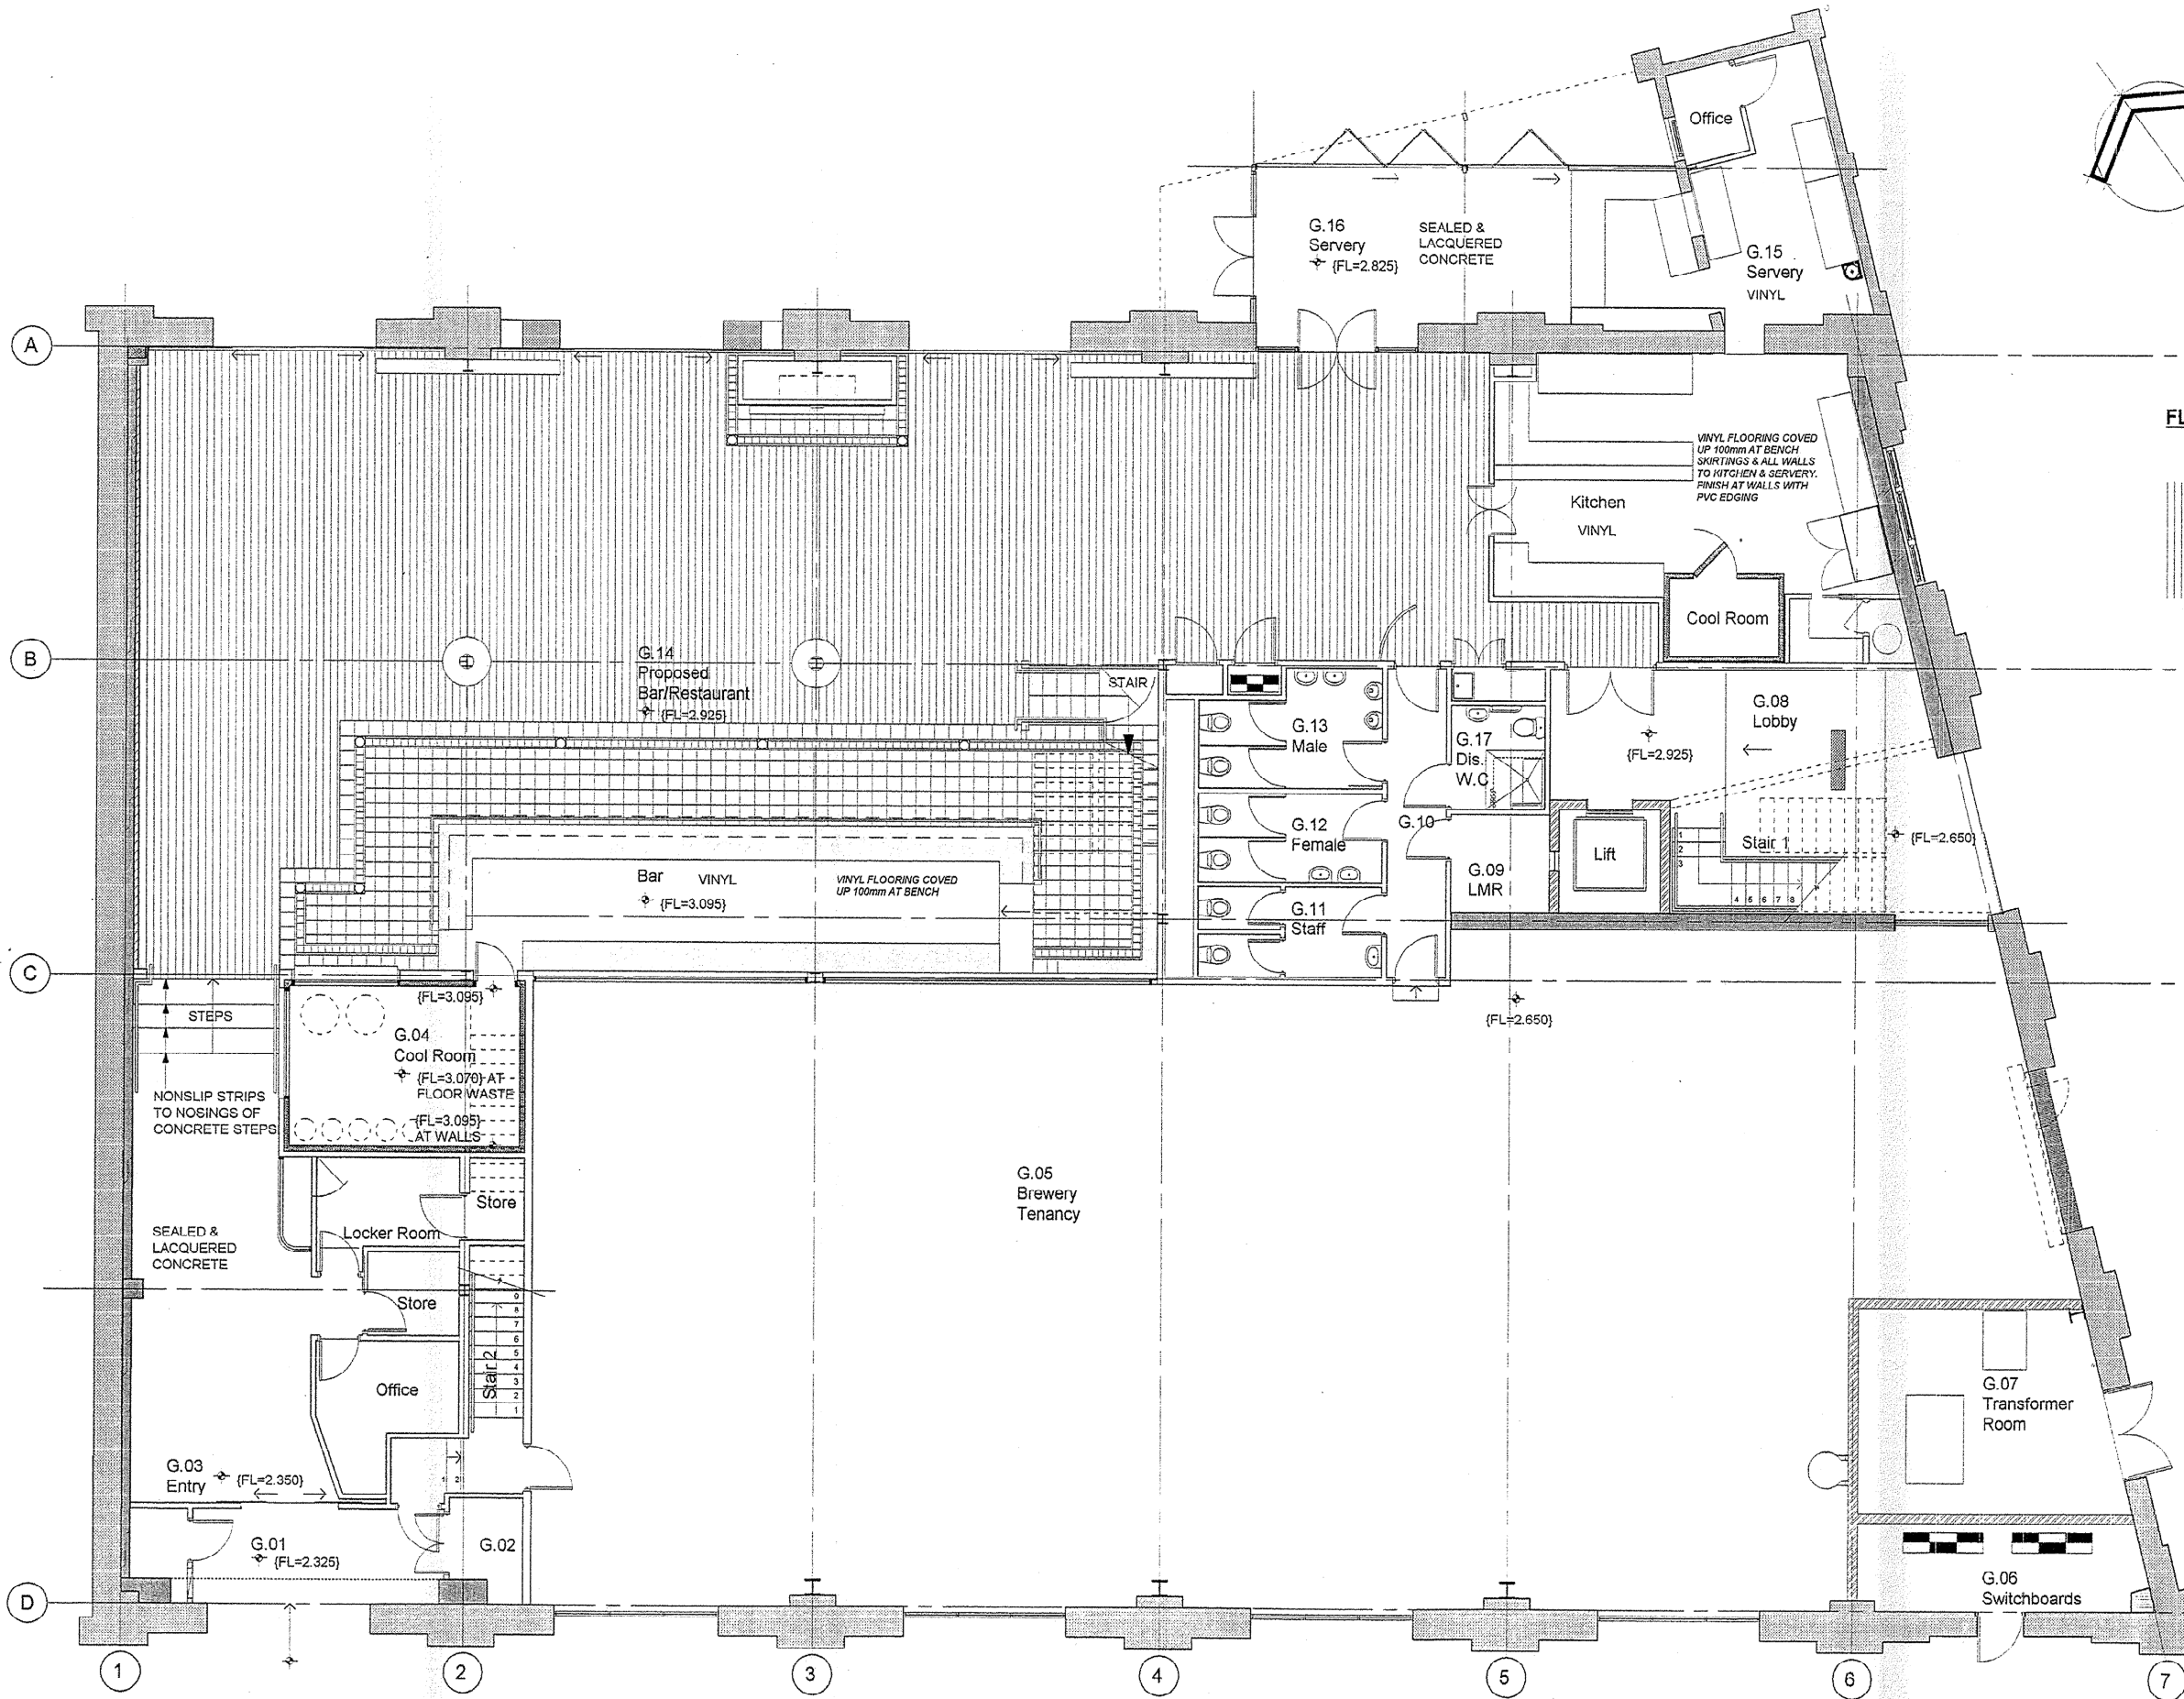

FLOOR FINISHES LEGEND

- SELECTED RECYCLED 150x25 TIMBER STRIP FLOORING
- SELECTED 150x150 TILE FLOORING
- SELECTED 300x60 TILE EDGING
- 250x250 CAST METAL INSERT
- SELECTED 300x300 TILE FLOORING

W.C.C. RECORDS

WELLINGTON CITY COUNCIL SERVICES REQUEST No.

90586

APPROVED BUILDING CONSENT DOCUMENTS

WELLINGTON CITY COUNCIL ENVIRONMENT
10 JUL 2002
 RECEIVED
 WAKEFIELD ST., WELLINGTON



66 mandeville street, p o box 36210, christchurch, new zealand
 ph 64 3 343 6556, fax 64 3 343 6566, email info@3baldmen.co.nz

CONTRACTOR SHALL CHECK ALL DIMENSIONS PRIOR TO COMMENCING WORK
 THIS DRAWING IS CONFIDENTIAL FOR SECURITY & COPYRIGHT

WARREN ARCHITECTURAL DESIGN

DIRECTOR: GEOFF WARREN NZCD(ARCH) ADNZ
 PHONE / FAX: (03) 365 9983
 EMAIL: warrenarchitectural@clear.net.nz
 ADDRESS: FIRST FLOOR, 187 LICHFIELD STREET
 CNR. LICHFIELD & BARBADOS STS.
 P.O. BOX 8876 CHRISTCHURCH


SCALE: 1:100
 DATE: FEBRUARY 2002
 FILE: 0140

A1a

GROUND FLOOR FINISHES SCALE 1:100

SHED 22 - WELLINGTON

REVISION	DESCRIPTION	DATE
7	ADD NOTES & WINDOW TO COOL ROOM, AMEND STEPS	24/06/02
6	AMEND FLOORING AREAS TO TILING & TIMBER	04/06/02
5	AMEND TILING, SEATS & WALLS, ADD STAGE, REMOVE FURNITURE	20/05/02
4	ADD STAIR HANDRAILS, AMEND SEATING & COOL RM WINDOW	30/04/02
3	ADD GRIDS, AMEND WINDOW WALL	15/04/02
2	AMEND & ADD FLOOR TILING	09/04/02
1	ADD STAIR, AMEND FLOORING, BAR LENGTH & COOL RM WINDOWS	05/04/02

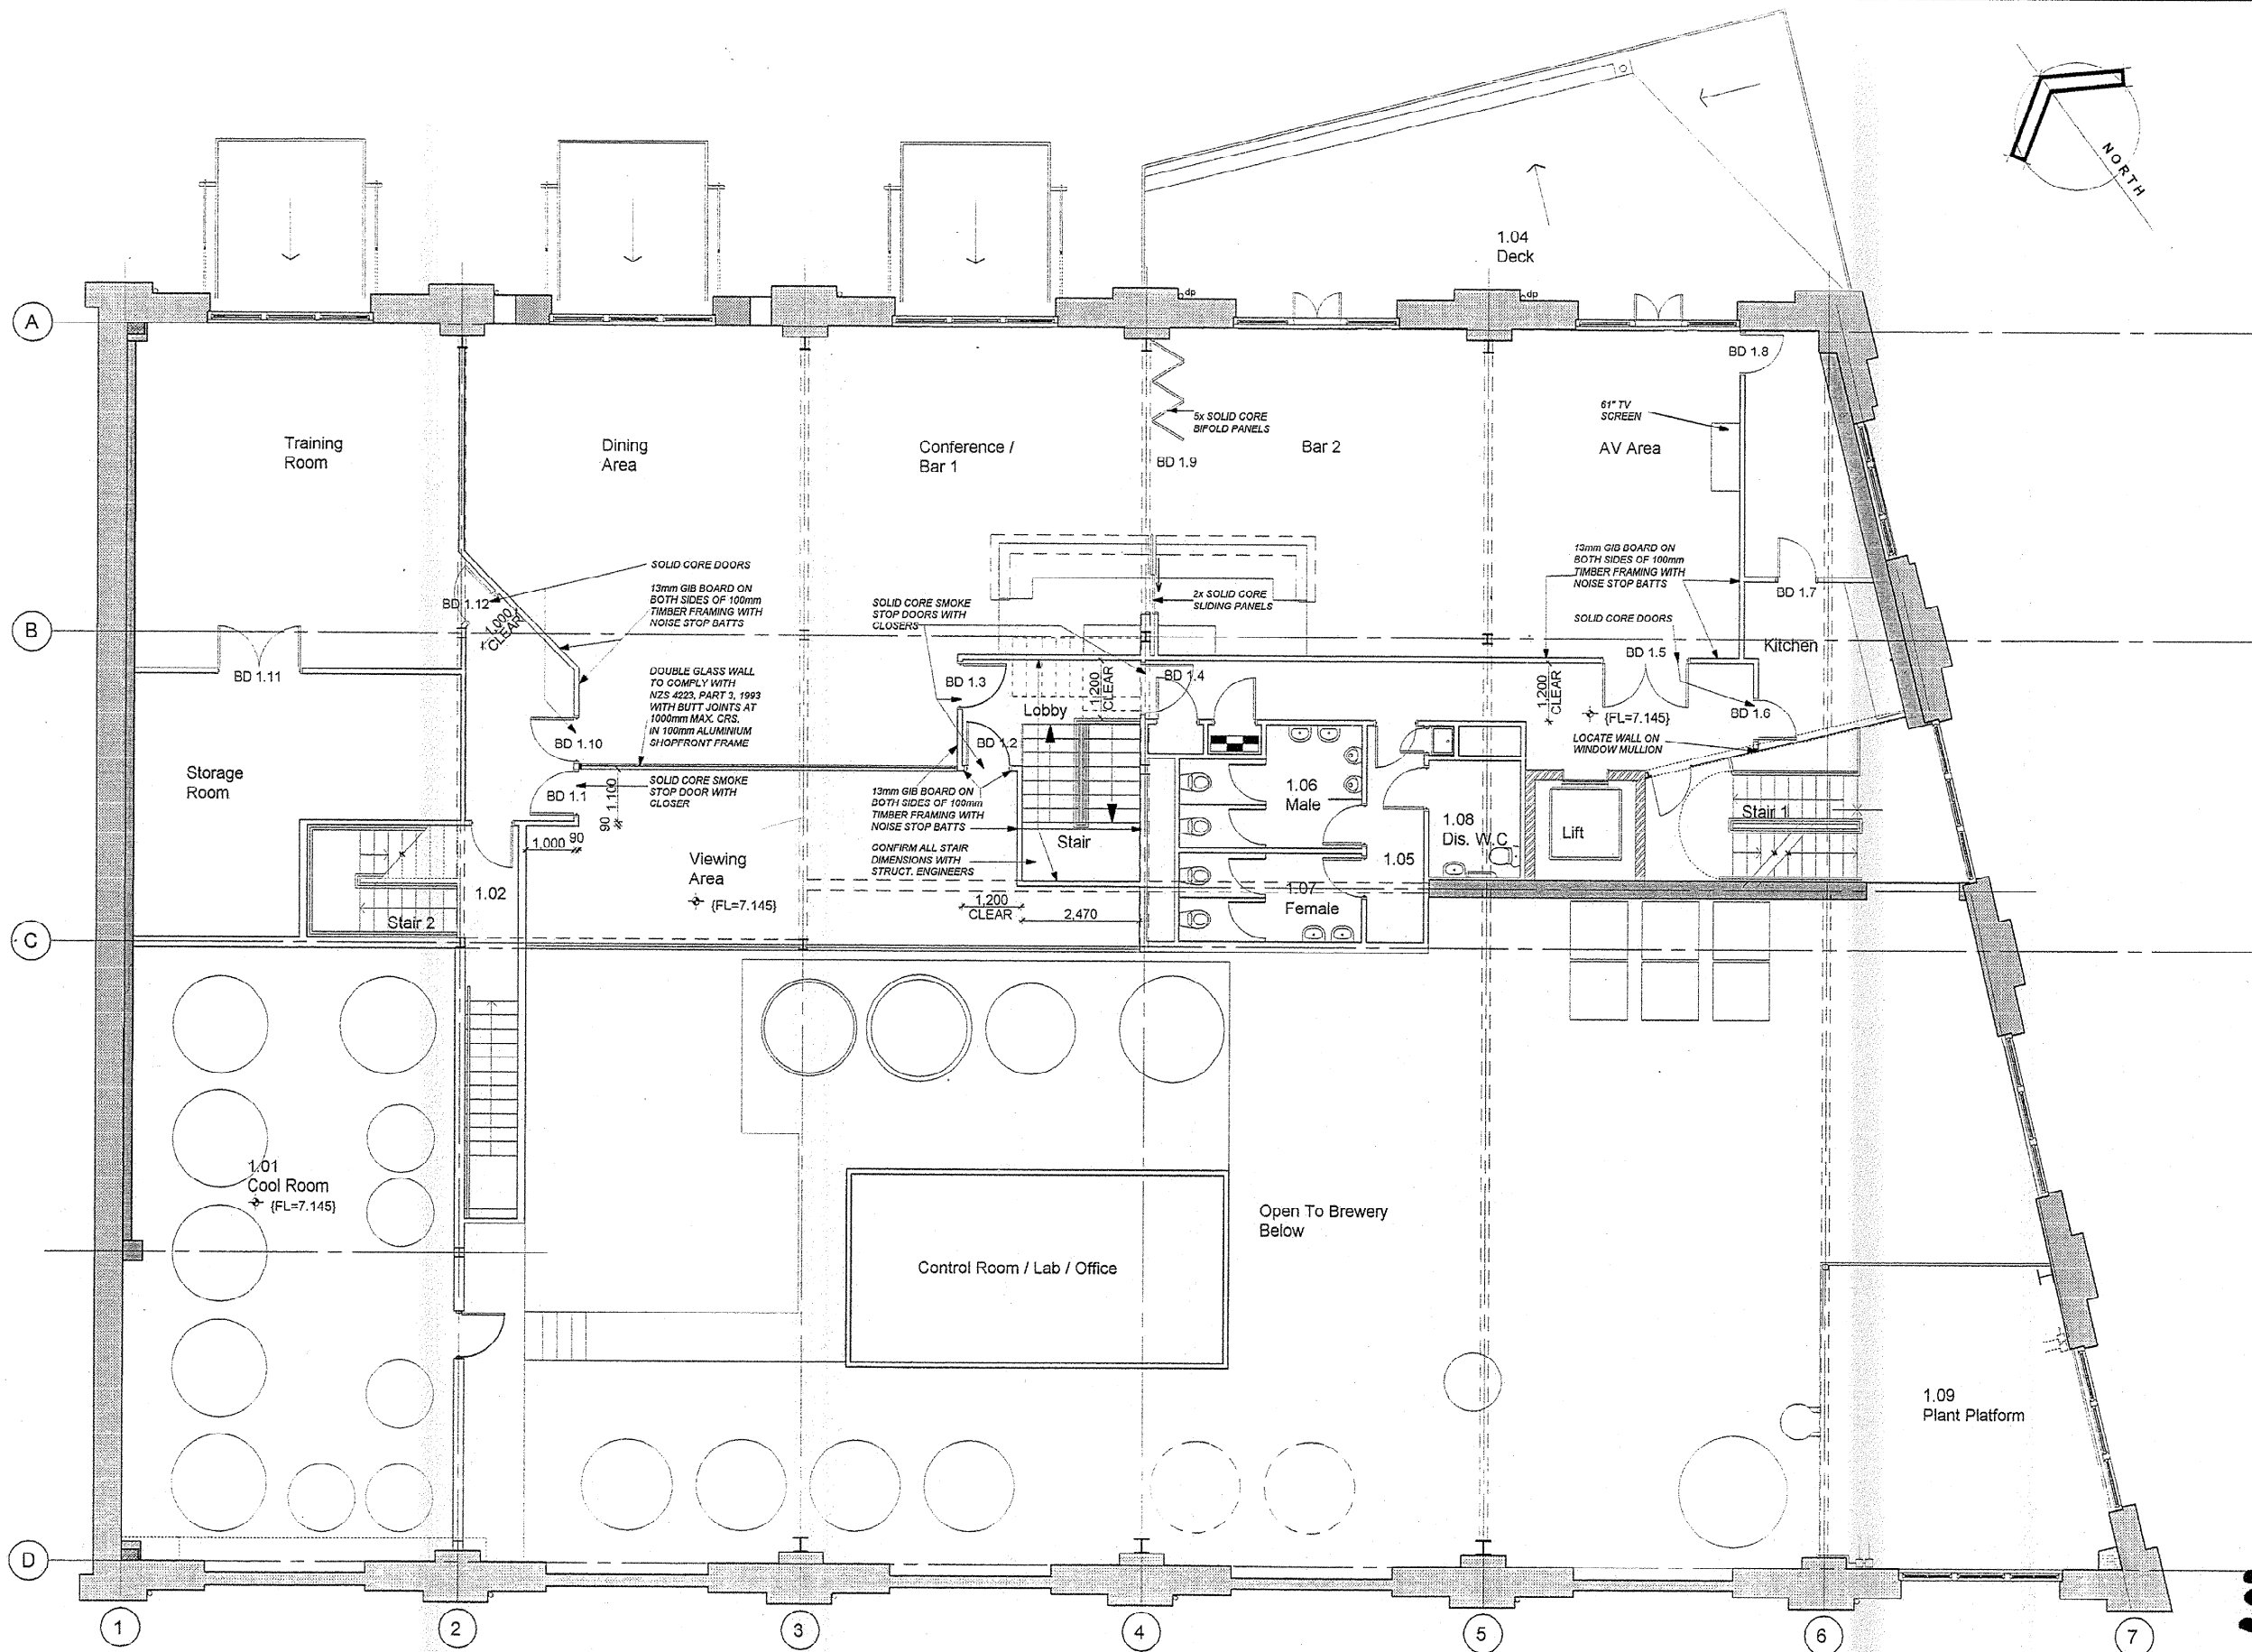

FIRST FLOOR PLAN


SCALE 1:100

WELLINGTON CITY COUNCIL
SERVICES REQUEST NO

№ - 90586

APPROVED BUILDING
CONSENT DOCUMENTS

**W.C.C.
RECORDS**

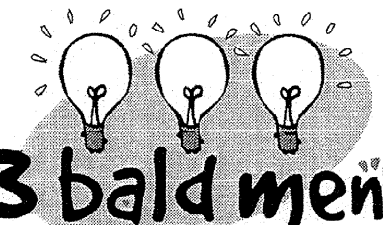

66 mandeville street . p o box 36210 . christchurch . new zealand
ph 64 3 343 6556 . fax 64 3 343 6566 . email info@3baldmen.co.nz

CONTRACTOR SHALL CHECK ALL DIMENSIONS PRIOR TO COMMENCING WORK
THIS DRAWING IS CONFIDENTIAL FOR SECURITY & COPYRIGHT

WARREN ARCHITECTURAL DESIGN


DIRECTOR : GEOFF WARREN (NZCD(ARCH)) ADNZ
PHONE/FAX : (03) 365 3993
EMAIL : warrenarchitectural@clear.net.nz
ADDRESS : FIRST FLOOR, 181 LICHFIELD STREET
CNR. LICHFIELD & BARBADOS STS.
P.O. BOX 8876 CHRISTCHURCH

SCALE : 1:100
DATE : MARCH 2002
FILE : 0140

A1d

SHED 22 - WELLINGTON

REVISION	DESCRIPTION	DATE
9	ADD NOTES & AMEND DOORS	24/06/02
8	AMEND WALLS, ADD NOTES & DIMENSIONS	04/05/02
7	AMEND BAR, WALLS, TILING & STAIRS	30/04/02
6	ADD GRIDS	15/04/02
5	ADD BAR TILING, AMEND WALLS, DOORS & LAB	09/04/02
4	BREWERY ADDED, TOILET NOTE REMOVED	05/04/02
3	ROOM NAMES, DOORS & STAIR OPTIONS AMENDED	22/03/02
2	ROOM NAMES, DOORS & STAIR OPTIONS AMENDED	18/03/02
1	ROOM LAYOUT AMENDED	15/03/02

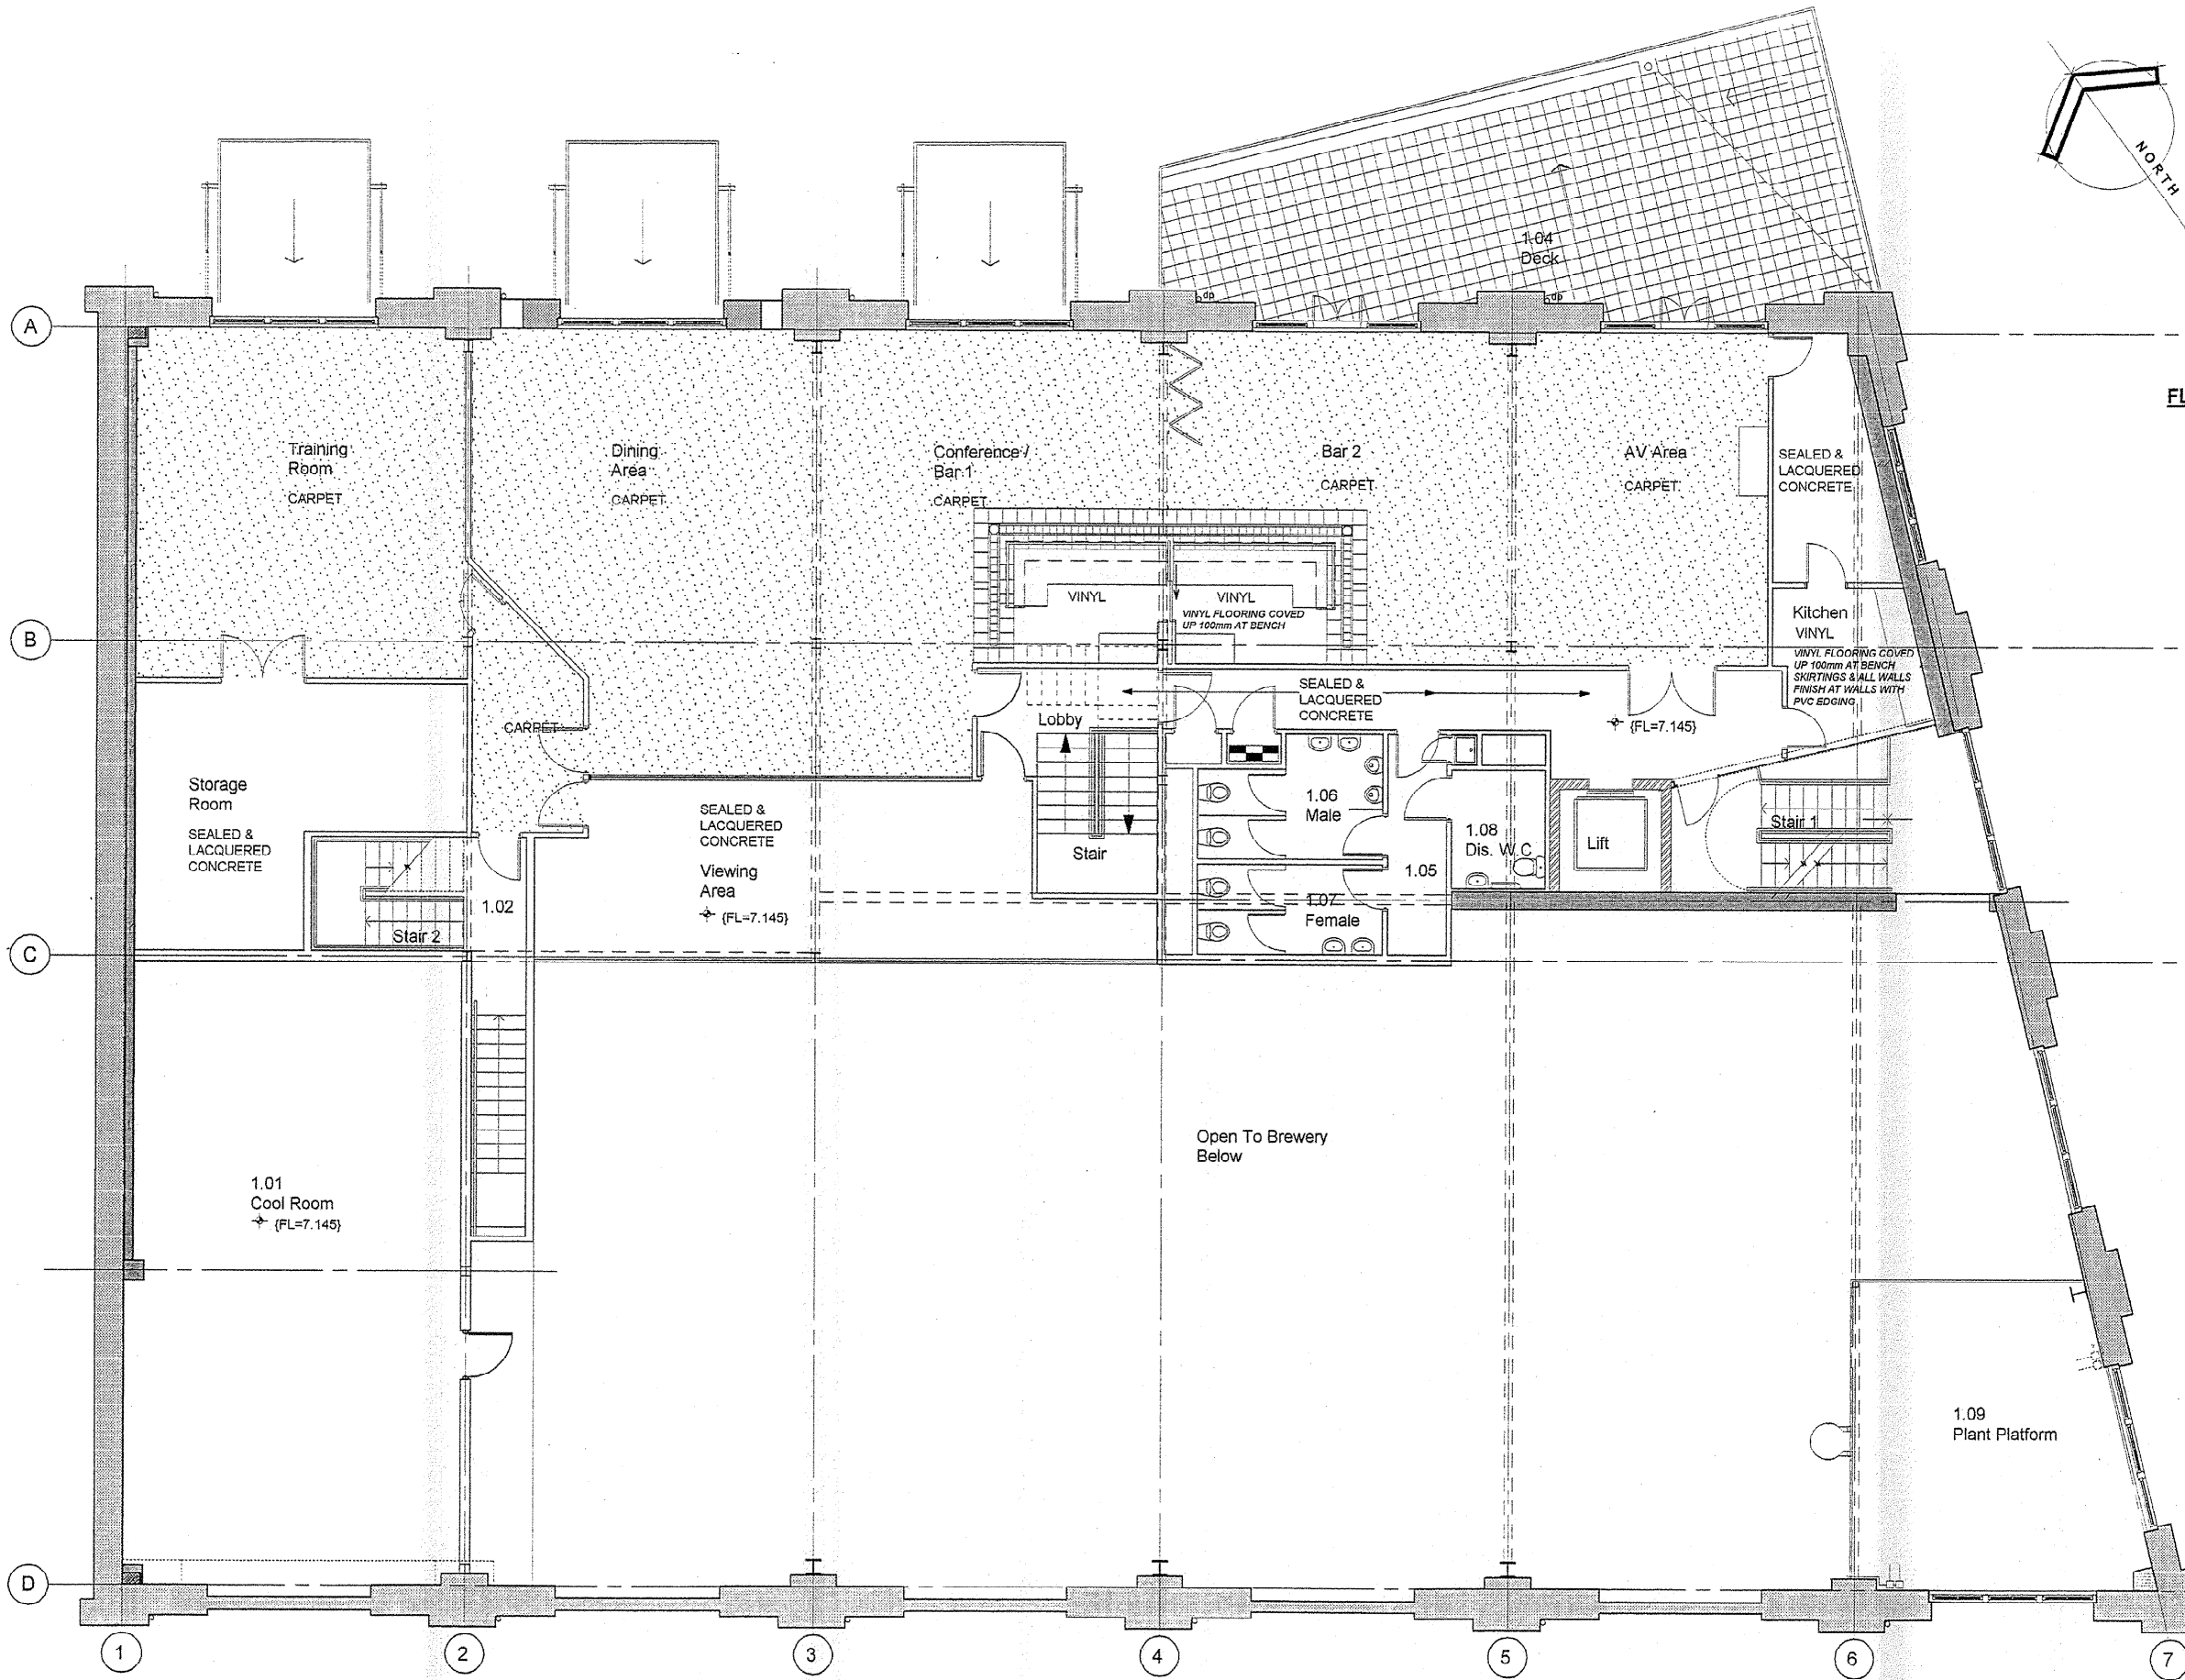

FLOOR FINISHES LEGEND

- SELECTED CARPET FLOORING
- SELECTED 150X150 TILE FLOORING
- SELECTED 300X50 TILE EDGING
- 250X250 CAST METAL INSERT
- SELECTED 300X300 TILE FLOORING

W.C.C. RECORDS

WELLINGTON CITY COUNCIL
SERVICES REQUEST NO

90586

APPROVED BUILDING
CONSENT DOCUMENTS

WELLINGTON CITY COUNCIL
ENVIRONMENT
10 JUL 2002
RECEIVED
WAKEFIELD ST., WELLINGTON

1.09
Plant Platform



66 mandeville street . p o box 36210 . christchurch . new zealand
ph 64 3 343 6556 . fax 64 3 343 6566 . email info@3baldmen.co.nz

CONTRACTOR SHALL CHECK ALL DIMENSIONS PRIOR TO COMMENCING WORK
THIS DRAWING IS CONFIDENTIAL FOR SECURITY & COPYRIGHT

WARREN ARCHITECTURAL DESIGN

DIRECTOR : GEOFF WARREN NZQA(ARCH) ADNZ
PHONE/FAX : (03) 365 9993
EMAIL : warrenarchitectural@clear.net.nz
ADDRESS : FIRST FLOOR, 187 LICHFIELD STREET
CNR. LICHFIELD & BARBADOS STS.
P.O. BOX 8876 CHRISTCHURCH


SCALE : 1 : 100
DATE : MARCH 2002
FILE : 0140

A1e


REVISION	DESCRIPTION	DATE
4	ADD NOTES & AMEND DOORS	24/08/02
3	AMEND WALLS & FLOOR FINISHES	04/08/02
2	AMEND TILING & WALLS	20/05/02
1	AMEND BAR, WALLS, TILING & STAIRS	30/04/02

FIRST FLOOR FINISHES SCALE 1 : 100


SHED 22 - WELLINGTON

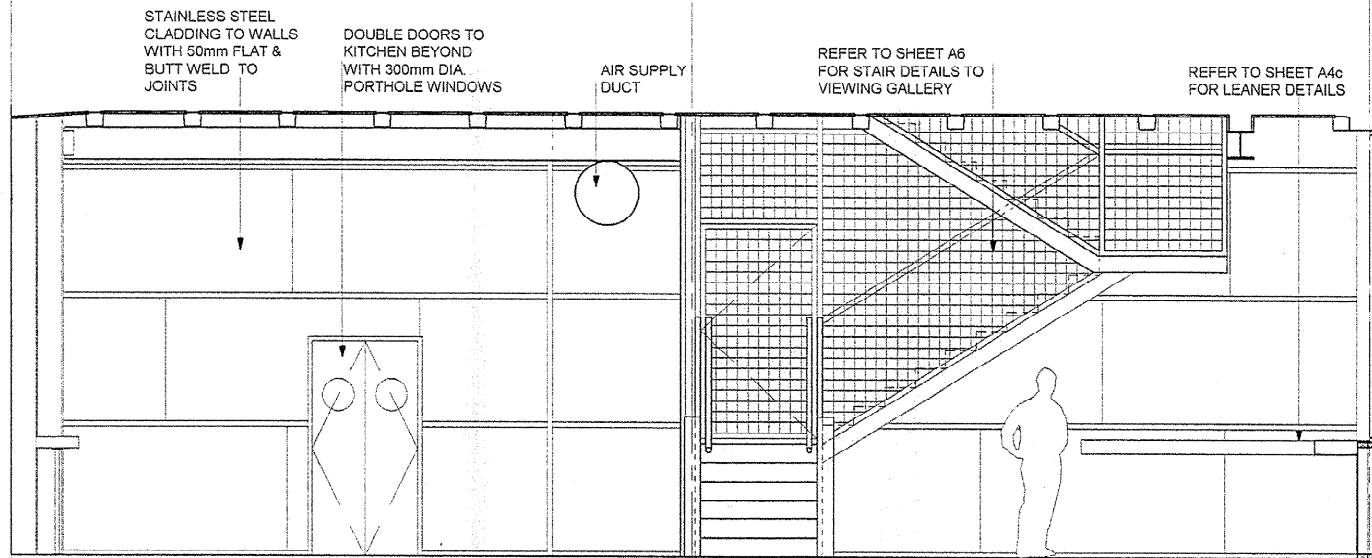

SOUTH EAST ELEVATION

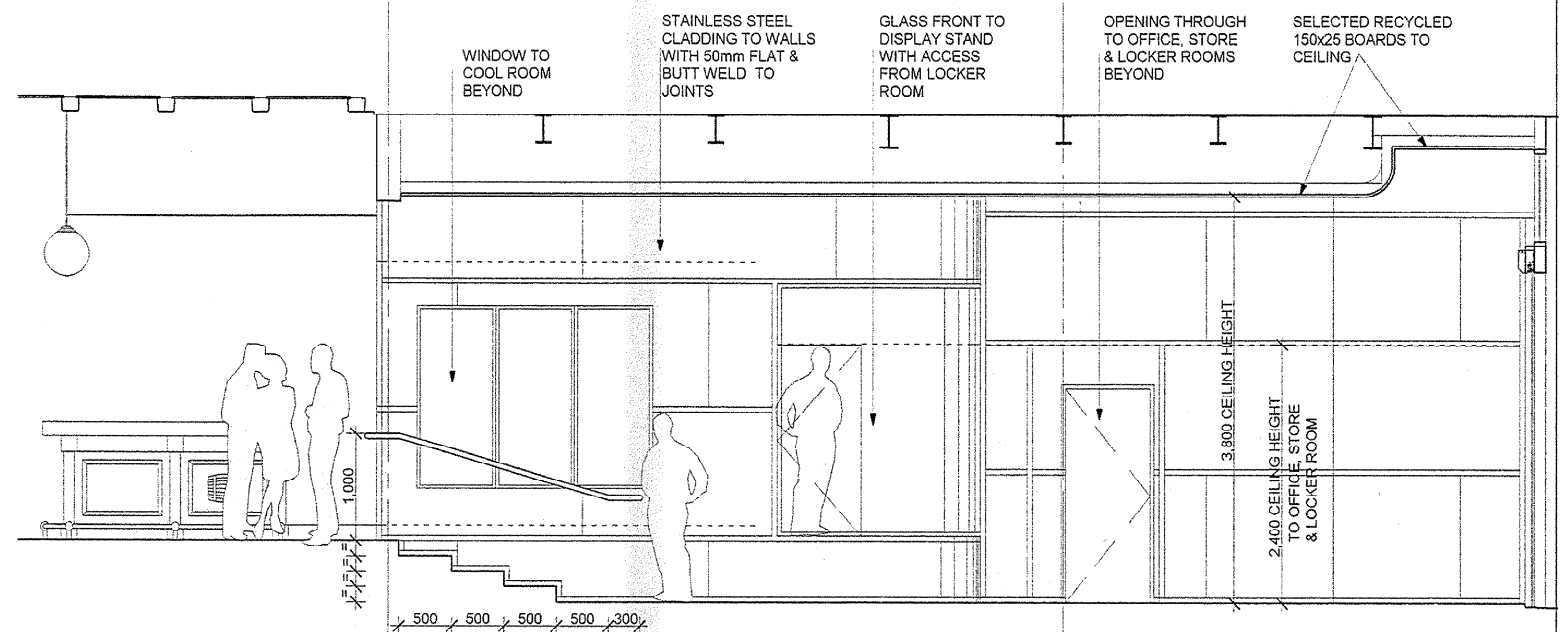

CABLE ST ENTRANCE ELEVATION

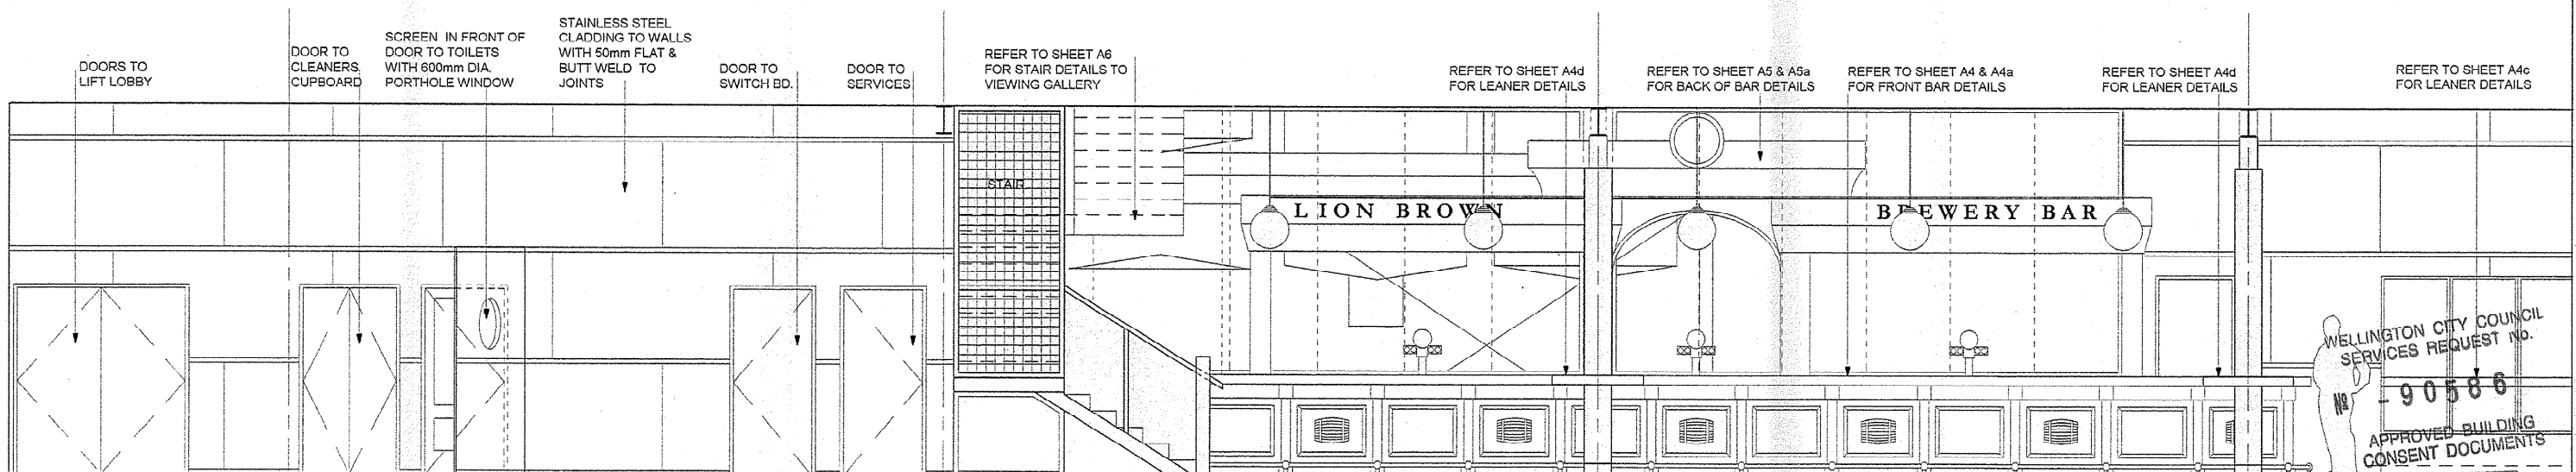


SOUTH WEST ELEVATION

SCALE 1:50

GROUND FLOOR BAR / RESTAURANT ELEVATIONS

WELLINGTON CITY COUNCIL
SERVICES REQUEST NO.
90586
APPROVED BUILDING
CONSENT DOCUMENTS

W.C.C.
RECORDS

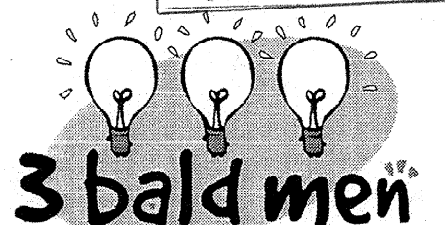

WELLINGTON CITY COUNCIL
ENVIRONMENT
10 JUL 2002
RECEIVED
WAKEFIELD ST., WELLINGTON

66 mandeville street . p o box 36210 . christchurch . new zealand
ph 64 3 343 6556 . fax 64 3 343 6566 . email info@3baldmen.co.nz


CONTRACTOR SHALL CHECK ALL DIMENSIONS PRIOR TO COMMENCING WORK
THIS DRAWING IS CONFIDENTIAL FOR SECURITY & COPYRIGHT

WARREN ARCHITECTURAL DESIGN
DIRECTOR :
PHONE / FAX : (03) 355 3553
EMAIL :
ADDRESS :
SCALE : 1:50
DATE : FEBRUARY 2002
FILE : 0140


A2

SHED 22 - WELLINGTON

REVISION	DESCRIPTION	DATE
5	ADD NOTES & STEPS, REMOVE SEATS & RAMP, AMEND CLADDING	24/06/02
4	ADD & AMEND DETAIL	30/04/02
3	ADD LOWERED CEILING, AMEND COOL ROOM WINDOWS	15/04/02
2	ADD STAIR & BREWERY, AMEND BAR LENGTH & COOL RM WINDOWS	09/04/02
1	BAR WALL AMENDED - BRICK REMOVED, OPENING SIZES INCREASED	05/03/02

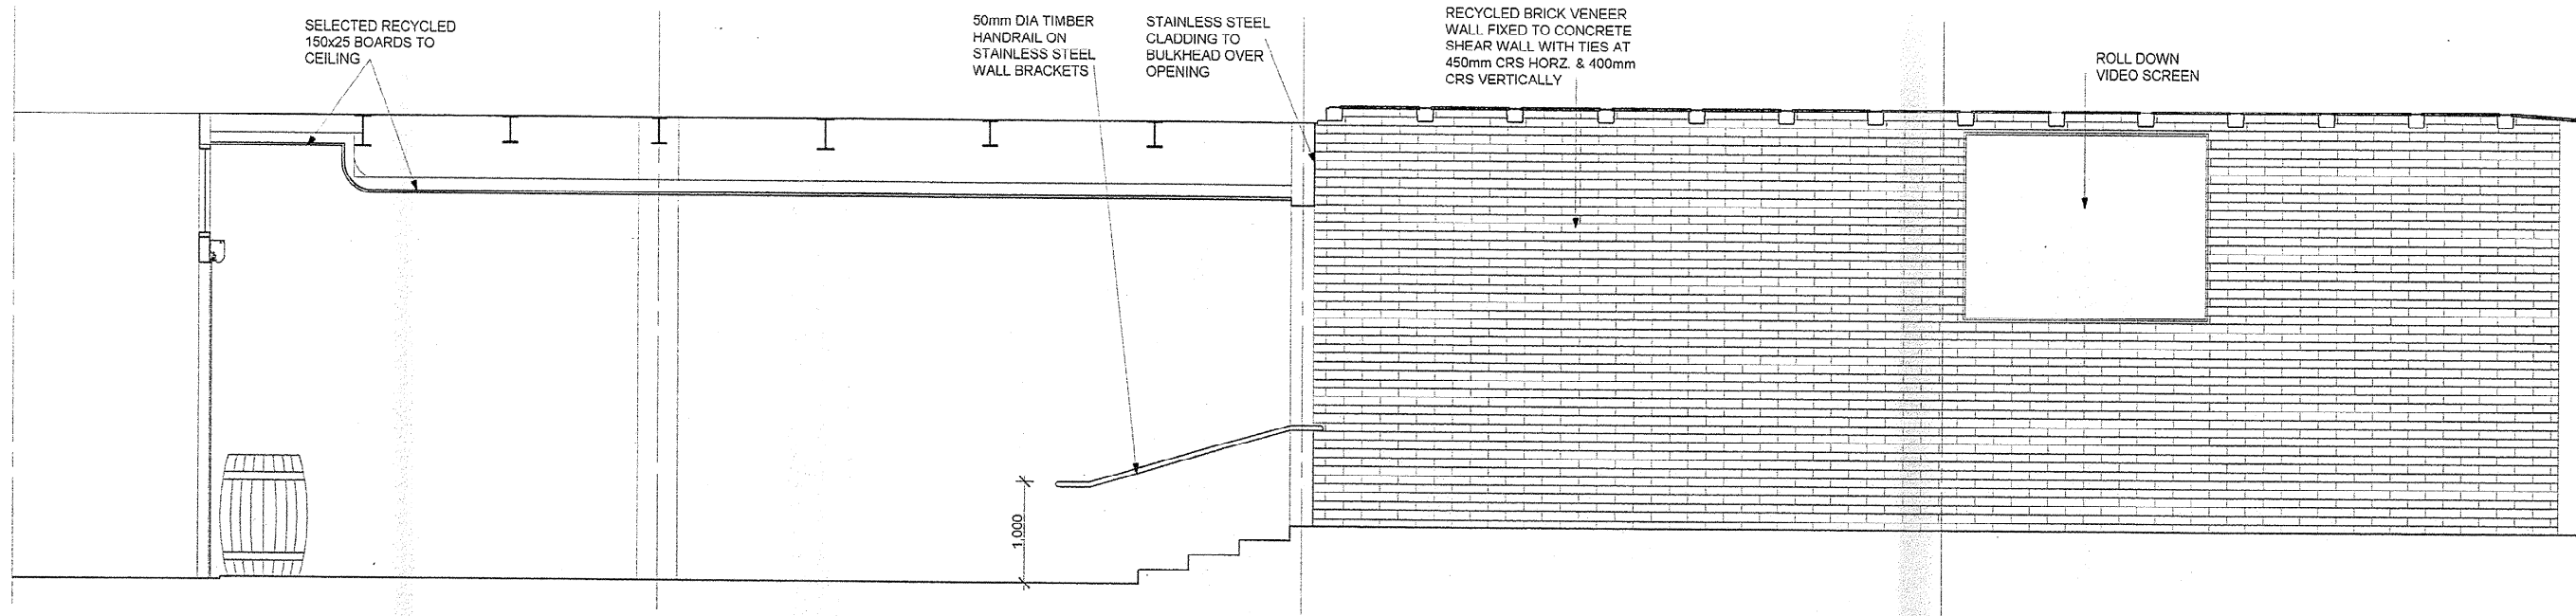

NORTH WEST ELEVATION

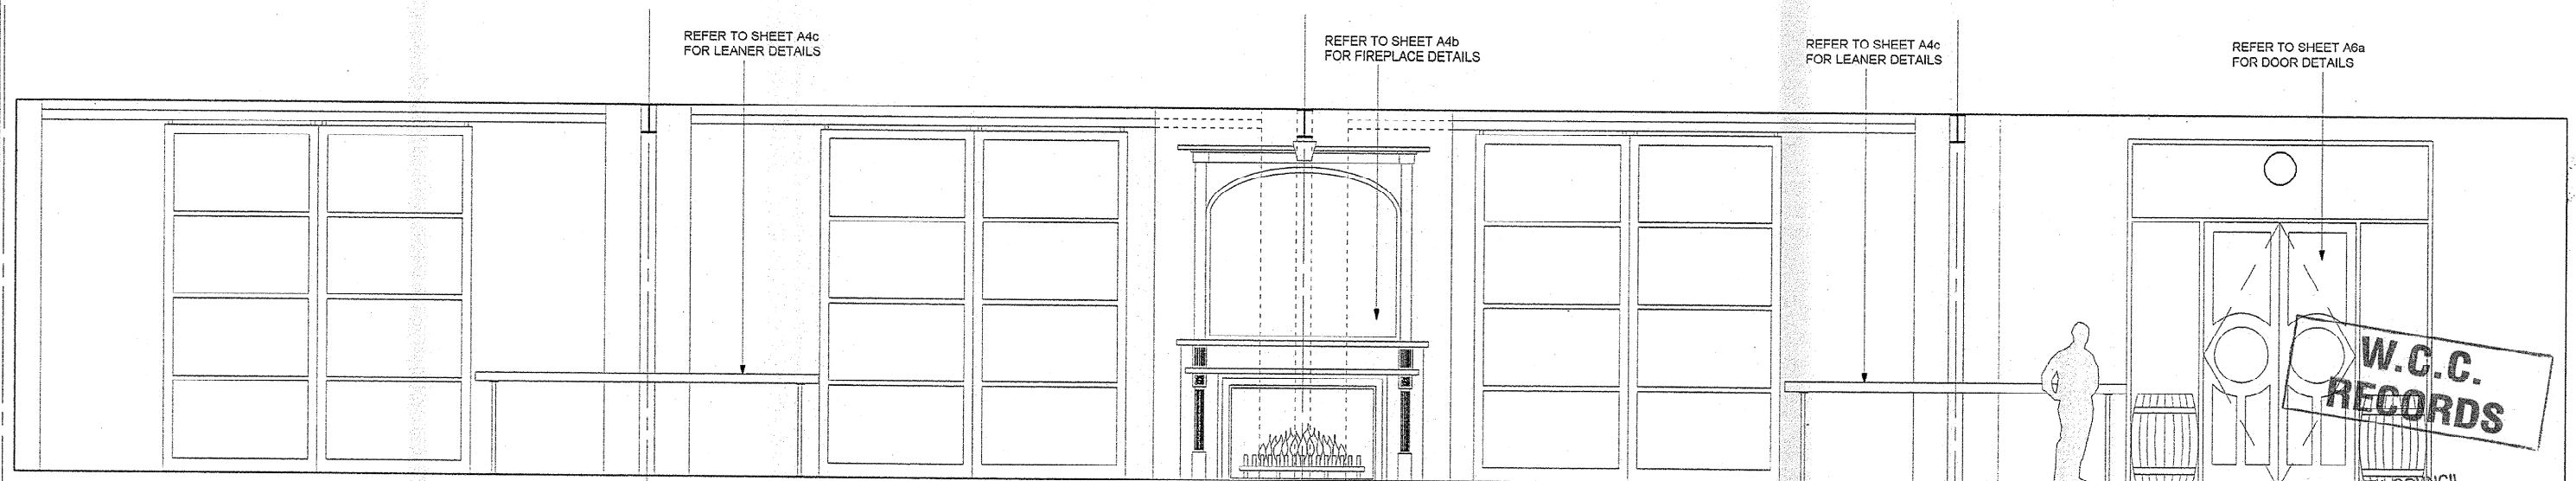



NORTH EAST ELEVATION SCALE 1:50

GROUND FLOOR BAR / RESTAURANT ELEVATIONS

WELLINGTON CITY COUNCIL
SERVICES REQUEST NO

№ - 90586

APPROVED BUILDING
CONSENT DOCUMENTS

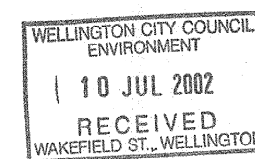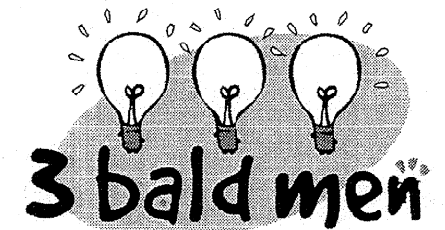

66 mandeville street . p o box 36210 . christchurch . new zealand
ph 64 3 343 6556 . fax 64 3 343 6566 . email info@3baldmen.co.nz

CONTRACTOR SHALL CHECK ALL DIMENSIONS PRIOR TO COMMENCING WORK
THIS DRAWING IS CONFIDENTIAL FOR SECURITY & COPYRIGHT


SHED 22 - WELLINGTON

REVISION	DESCRIPTION	DATE
4	ADD NOTES & STEPS, REMOVE SEATS & RAMP, AMEND CLADDING	24/06/02
3	ADD DETAIL, AMEND SEATING, FIREPLACE & DETAIL	20/04/02
2	ADD LOWERED CEILING	15/04/02
1	DUCT OVER SERVING DOOR ADDED	05/04/02


WARREN ARCHITECTURAL DESIGN
 DIRECTOR : GEOFF WARREN NZQA(ARCH) ADNZ
 PHONE / FAX : (03) 385 9993
 EMAIL : warrenarchitectural@clear.net.nz
 ADDRESS : FIRST FLOOR, 187 LICHFIELD STREET
 CNR. LICHFIELD & BARBADOS STS.
 P.O. BOX 8876 CHRISTCHURCH

SCALE : 1:50
 DATE : FEBRUARY 2002
 FILE : 0140


A3

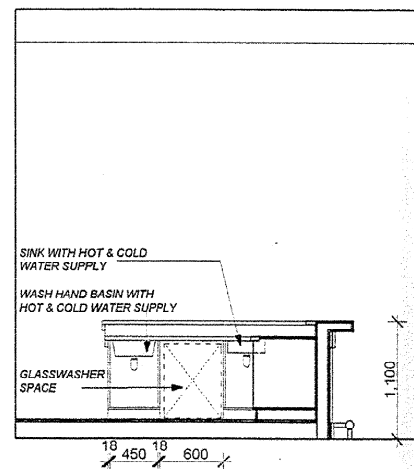


ELEVATION 1

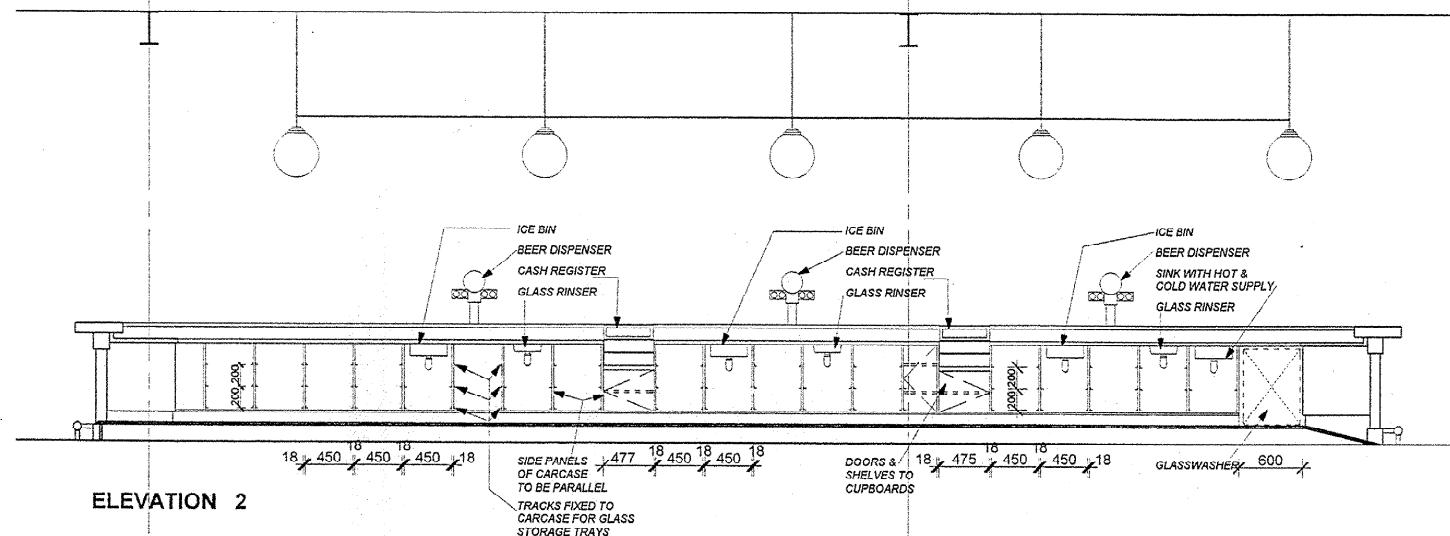


ELEVATION 2

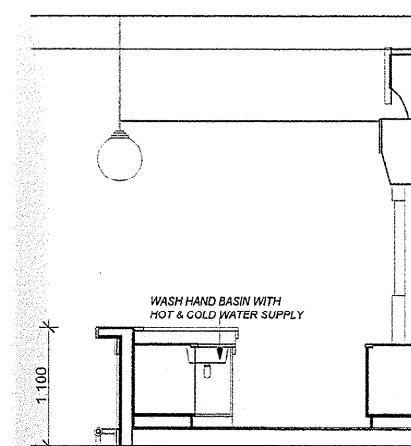


ELEVATION 3

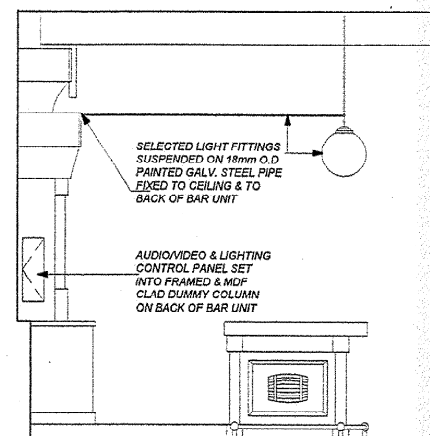


SIDE ELEVATION

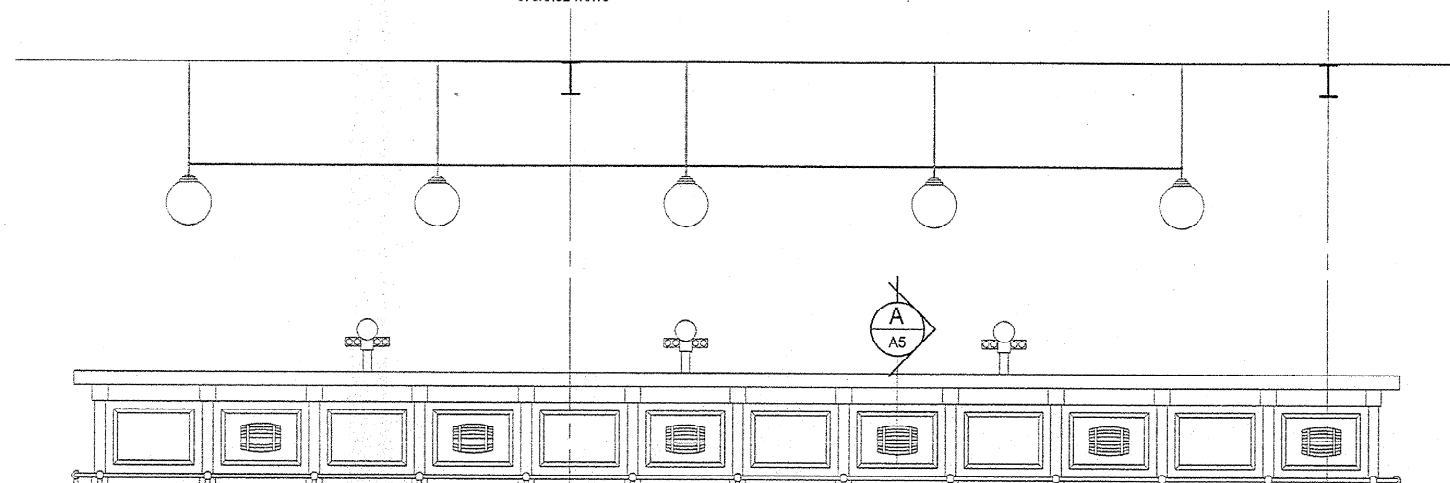

FRONT OF BAR ELEVATION

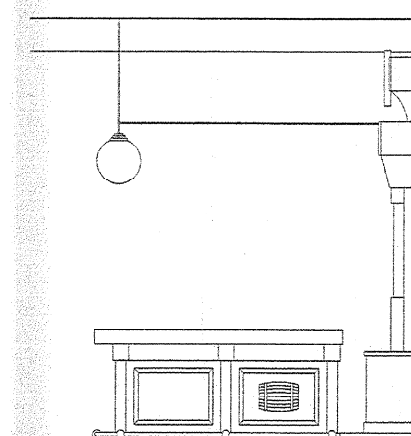

SIDE ELEVATION

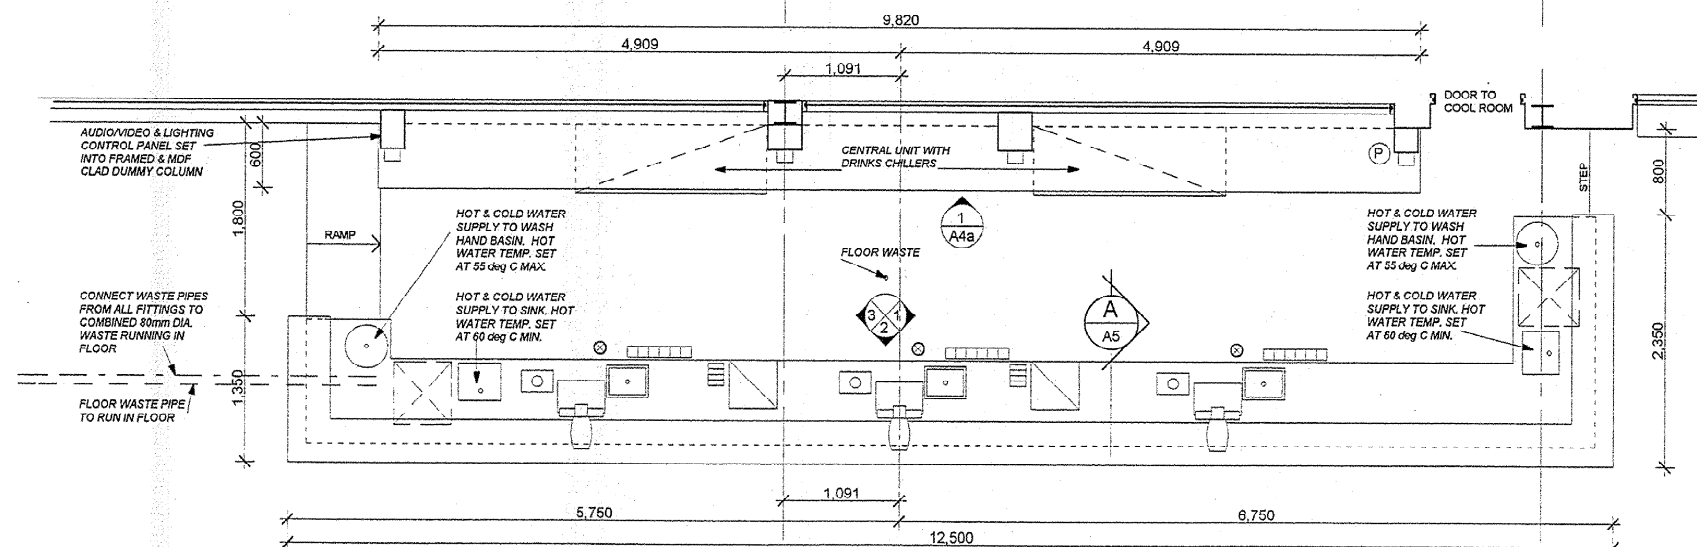

PLAN OF BAR SCALE 1:50
GROUND FLOOR BAR / RESTAURANT

BAR LEGEND

- STAINLESS STEEL SINK UNIT
- HAND BASIN
- GLASSWASHER
- PURPOSE MADE GLASS RINSER
- CASH REGISTER
- EFTPOS TERMINAL
- BEER DISPENSER WITH DRIP TRAY
- 6 SPIRIT BOTTLE SPEED RACK
- ICE BIN
- POSTMIX GUNS TO CONNECT TO REMOTE STORAGE IN COOL ROOM
- PHONE JACK POINT



BEER DISPENSER WITH DRIP TRAY



6 SPIRIT BOTTLE SPEED RACK



ICE BIN



POSTMIX GUNS TO CONNECT TO REMOTE STORAGE IN COOL ROOM



PHONE JACK POINT



NOTE: CONFIRM SIZES & CLEARANCES REQUIRED FOR ALL FITTINGS & APPLIANCES PRIOR TO STARTING CONSTRUCTION OF JOINERY UNITS

WELLINGTON CITY COUNCIL SERVICES REQUEST NO.

TELEPHONE - 90586

APPROVED BUILDING CONSENT DOCUMENTS

W.C.C. RECORDS

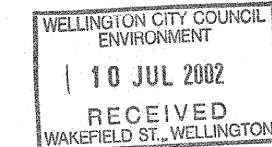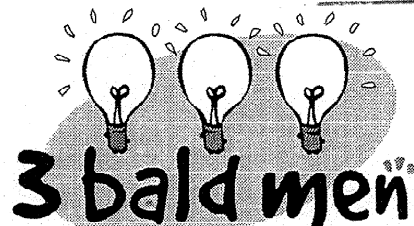

66 mandeville street, p o box 36210, christchurch, new zealand
PH 64 3 343 6556, FAX 64 3 343 6566, email info@3baldmen.co.nz

CONTRACTOR SHALL CHECK ALL DIMENSIONS PRIOR TO COMMENCING WORK
THIS DRAWING IS CONFIDENTIAL FOR SECURITY & COPYRIGHT

WARREN ARCHITECTURAL DESIGN

DIRECTOR: GEOFF WARREN NZQA(ARCH) ADNZ
PHONE/FAX: (03) 365 9993
EMAIL: warrenarchitectural@clear.net.nz
ADDRESS: FIRST FLOOR, 187 LICHFIELD STREET
CNR LICHFIELD & BARBADOS STS.
P.O. BOX 8876 CHRISTCHURCH


SCALE: 1:50
DATE: FEBRUARY 2002
FILE: 0140

A4



SHED 22 - WELLINGTON

REVISION	DESCRIPTION
3	ADD NOTES & DETAIL, AMEND BAR FITTING LAYOUT
2	BAR SHORTENED AT COOL ROOM END
1	BRICK WALL REMOVED, OPENINGS INCREASED, 3 DISPENSERS

24/08/02
05/04/02
05/03/02
DATE

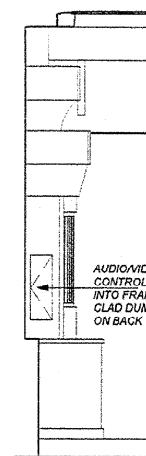

SIDE ELEVATION

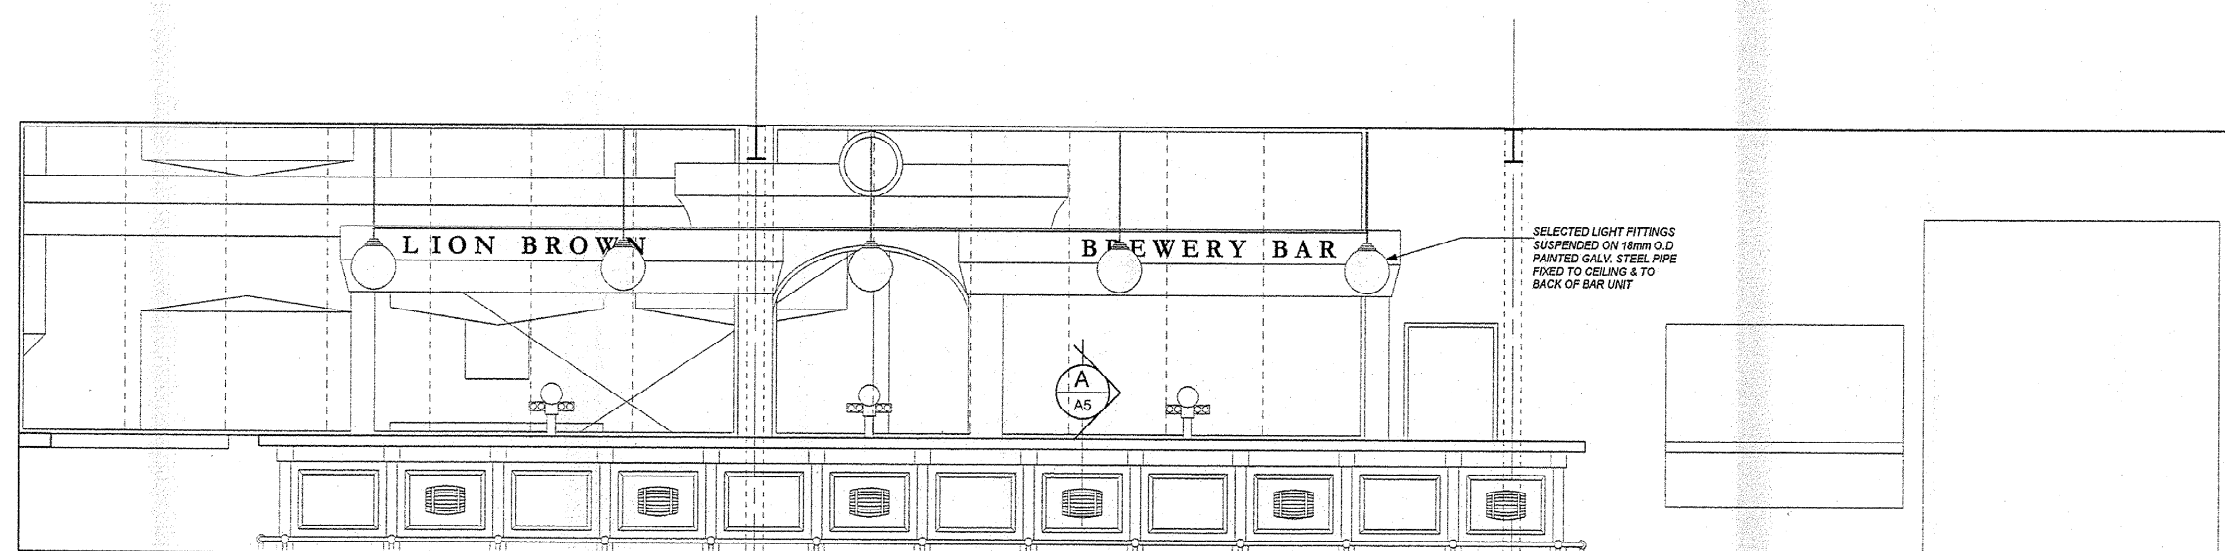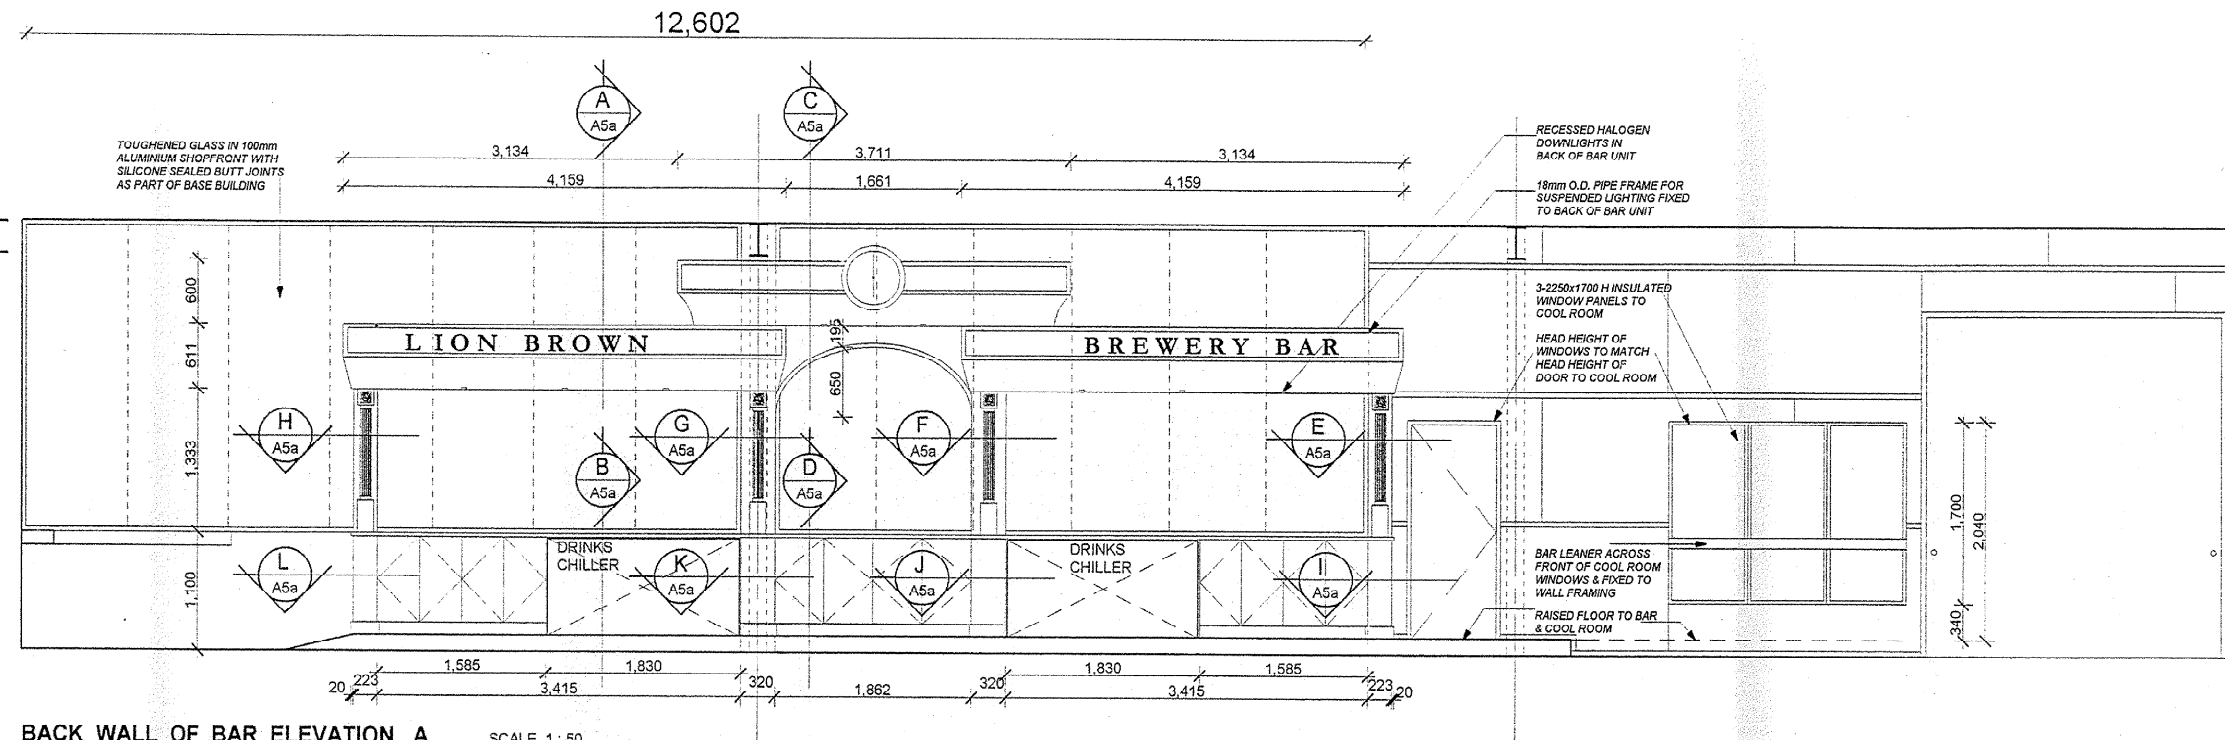



GROUND FLOOR BAR / RESTAURANT

W.C.C.
RECORDS

WELLINGTON CITY COUNCIL
SERVICES REQUEST No.

90586

APPROVED BUILDING
CONSENT DOCUMENTS

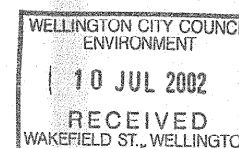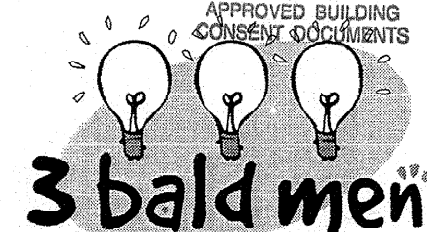

66 mandeville street . p o box 36210 . christchurch . new zealand
ph 64 3 343 6556 . fax 64 3 343 6566 . email info@3baldmen.co.nz

CONTRACTOR SHALL CHECK ALL DIMENSIONS PRIOR TO COMMENCING WORK
THIS DRAWING IS CONFIDENTIAL FOR SECURITY & COPYRIGHT

WARREN ARCHITECTURAL DESIGN


DIRECTOR: GEORGE WARREN NZQA(ARCH) ADNZ
PHONE/FAX: (03) 365 9993
EMAIL: warrenarchitectural@clear.net.nz
ADDRESS: FIRST FLOOR, 187 LICHFIELD STREET
CHR. LICHFIELD & BARBADOES STS.
P.O. BOX 8878 CHRISTCHURCH

SCALE: 1:50
DATE: FEBRUARY 2002
FILE: 0140


A4a

SHED 22 - WELLINGTON


2	ADD ELEVATIONAL DETAIL, DIMENSIONS & NOTES, ALTER NUMBER	24/06/02
1	AMEND & ADD ELEVATIONAL DETAIL	30/04/02
REVISION/	DESCRIPTION	DATE

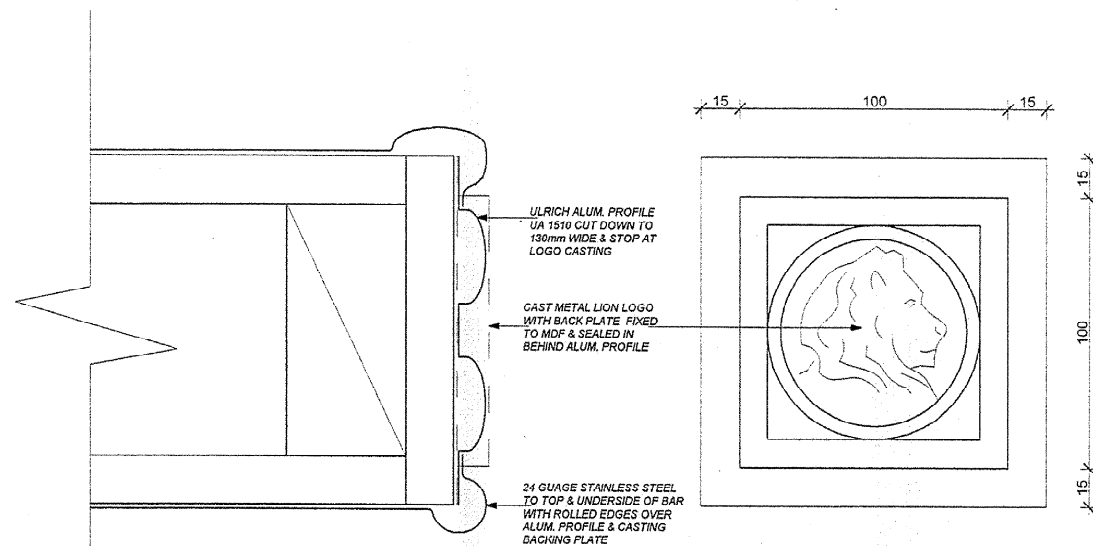


BAR EDGE DETAIL SCALE 1:2

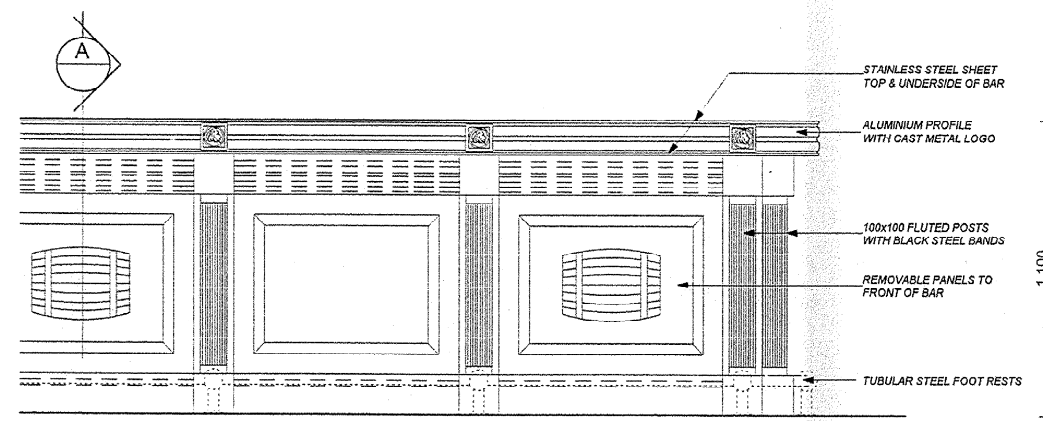


TYPICAL BAR ELEVATION SCALE 1:20

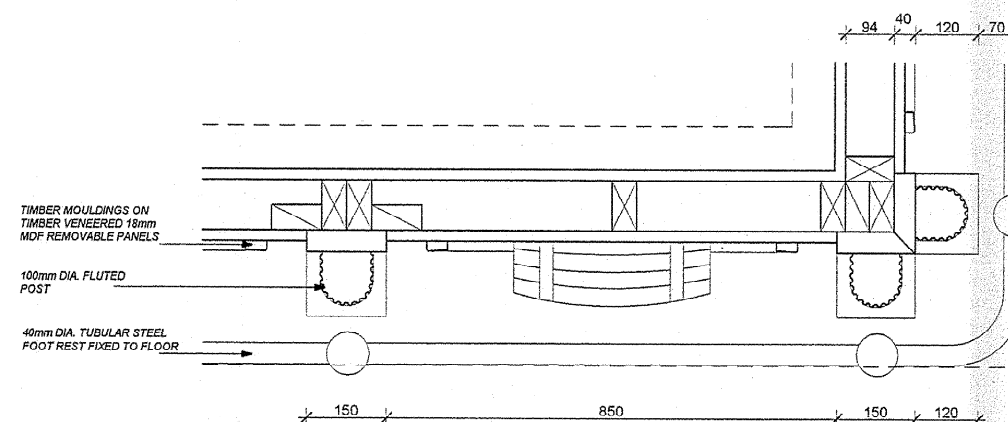

PART PLAN SCALE 1:10

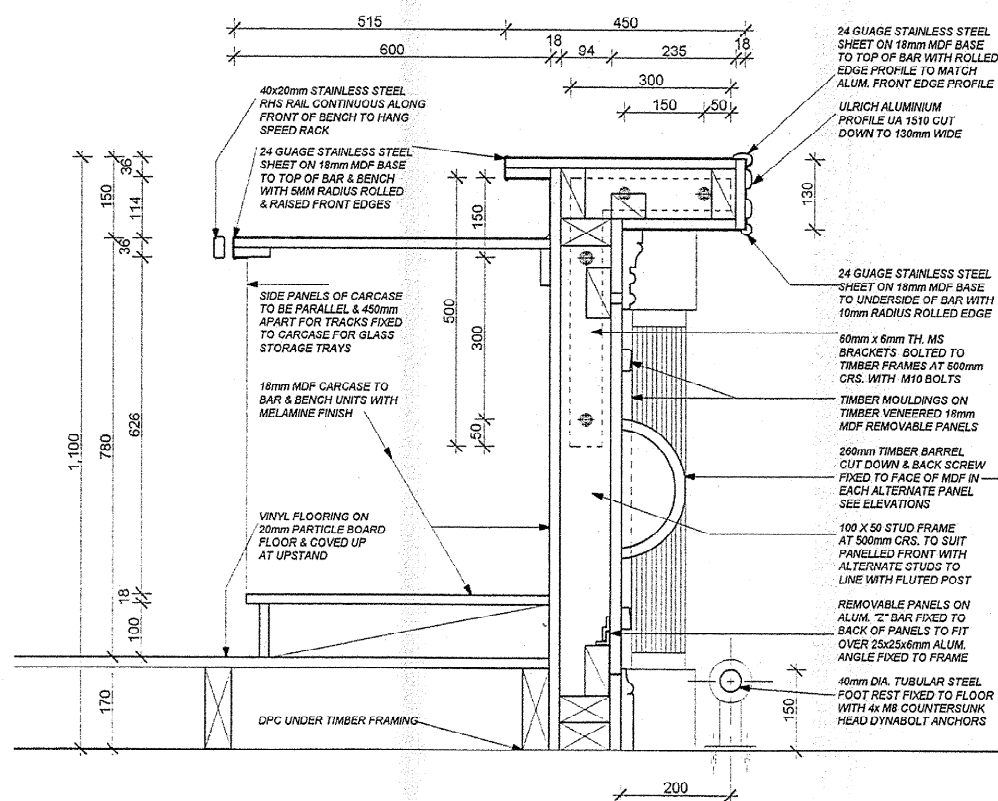

SECTION A THROUGH BAR SCALE 1:10

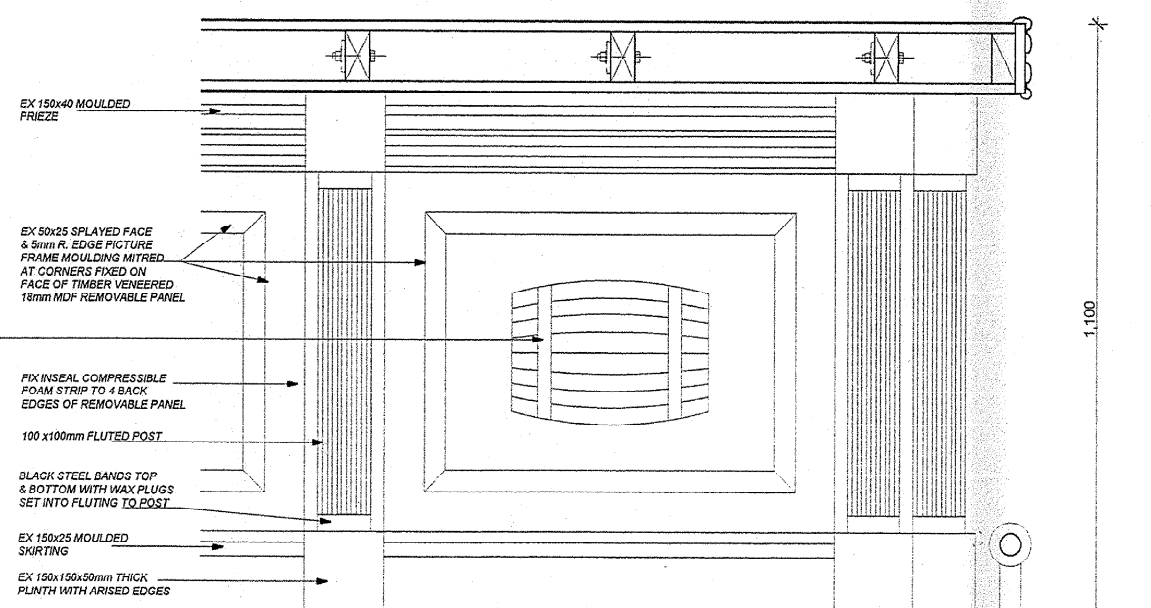

ELEVATION OF BAR FRONT SCALE 1:10

WELLINGTON CITY COUNCIL
SERVICES REQUEST No.

- 90586 -

APPROVED BUILDING
CONSENT DOCUMENTS

W.C.C.
RECORDS



66 mandeville street . p o box 36210 . christchurch . new zealand
ph 64 3 343 6556 . fax 64 3 343 6566 . email info@3baldmen.co.nz

CONTRACTOR SHALL CHECK ALL DIMENSIONS PRIOR TO COMMENCING WORK
THIS DRAWING IS CONFIDENTIAL FOR SECURITY & COPYRIGHT


WARREN ARCHITECTURAL DESIGN

DIRECTOR :
PHONE/FAX :
EMAIL :
ADDRESS :
GEOFF WARREN NZCD(ARCH.) ADNZ
PHONE / FAX : (03) 365 9993
warrenarchitectural@clear.net.nz
FIRST FLOOR, 107 LICHFIELD STREET
CNR LICHFIELD & BARBADOS STS.
P.O. BOX 8876 CHRISTCHURCH

SCALE : 1:20 1:10 1:2
DATE : FEBRUARY 2002
FILE : 0140


A5

SHED 22 - WELLINGTON

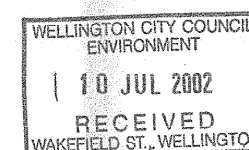


1 ADD NOTE & DIMENSIONS, ALTER NUMBER
REVISION DESCRIPTION


24/06/02
DATE

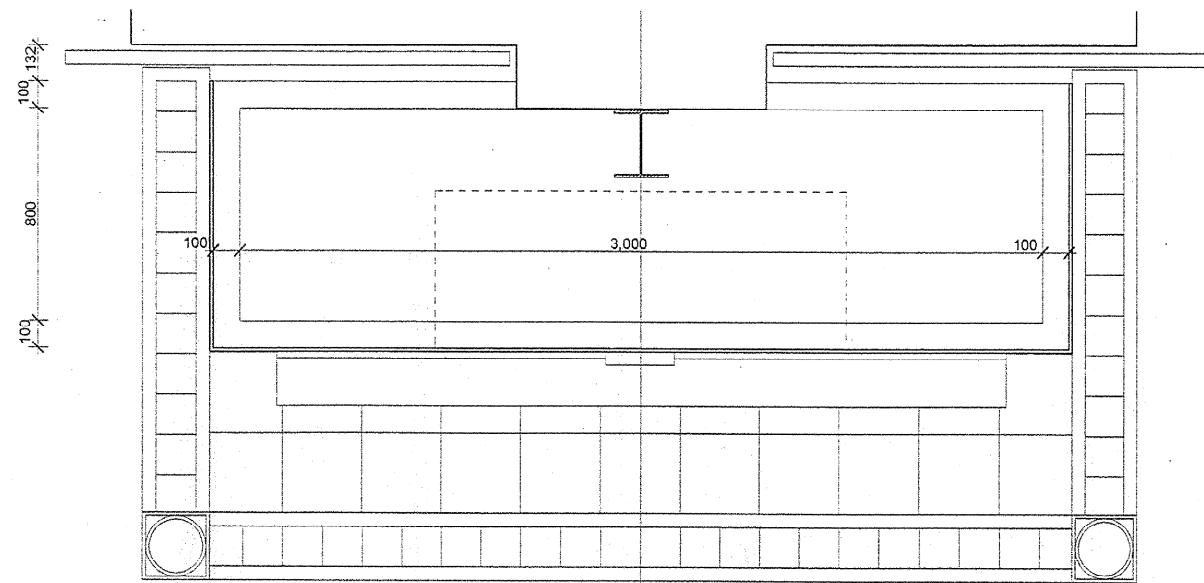

PLAN

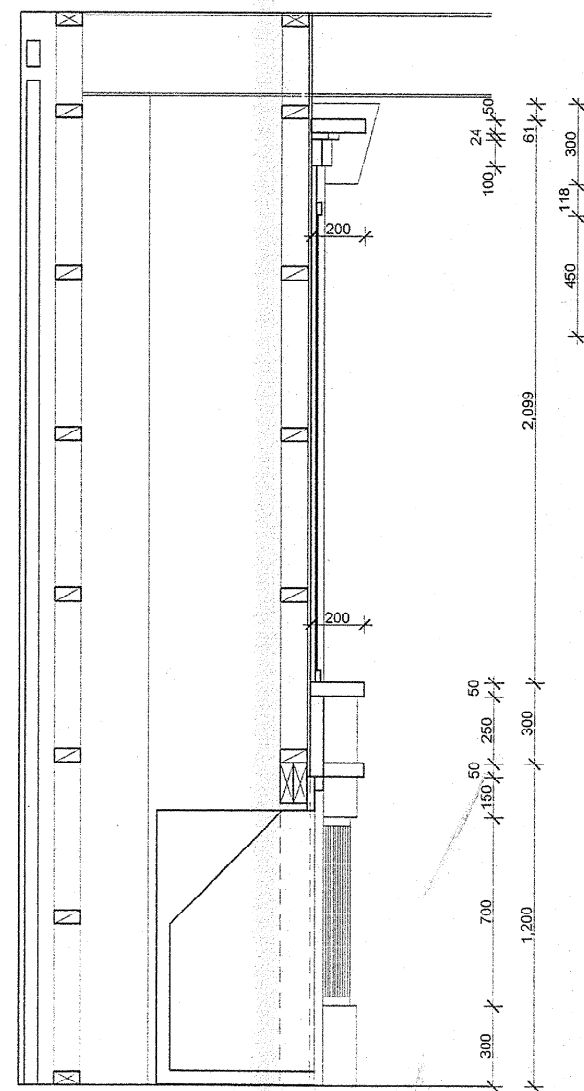

SECTION THROUGH FIREPLACE SCALE 1:20

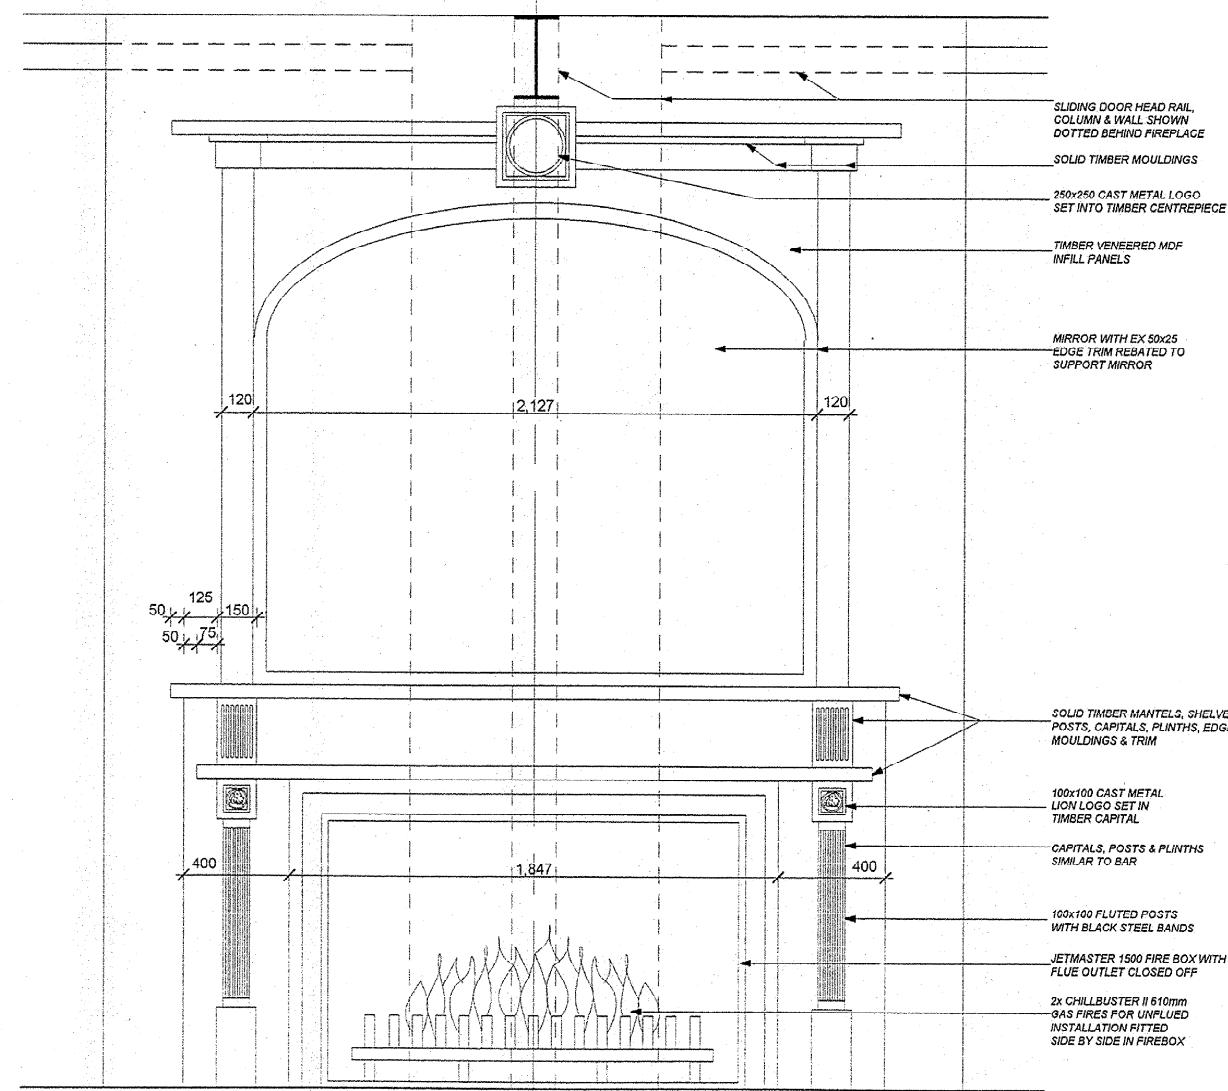


ELEVATION OF FIREPLACE SCALE 1:20

WELLINGTON CITY COUNCIL
SERVICES REQUEST No.

№ - 90586


APPROVED BUILDING
CONSENT DOCUMENTS

**W.C.C.
RECORDS**

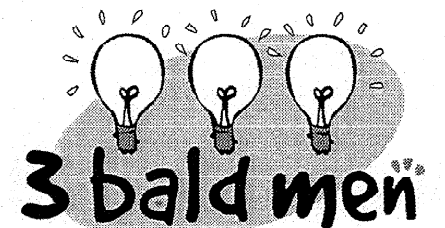

66 mandeville street . p o box 36210 . christchurch . new zealand
ph 64 3 343 6556 . fax 64 3 343 6566 . email info@3baldmen.co.nz

CONTRACTOR SHALL CHECK ALL DIMENSIONS PRIOR TO COMMENCING WORK
THIS DRAWING IS CONFIDENTIAL FOR SECURITY & COPYRIGHT

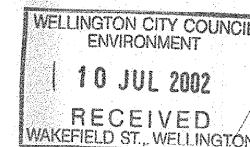

WARREN ARCHITECTURAL DESIGN


DIRECTOR :
PHONE/FAX :
EMAIL :
ADDRESS :
GEOFF WARREN NZCO(ARCH.) ADNZ
PHONE / FAX: (03) 365 9993
warrenarchitectural@clear.net.nz
FIRST FLOOR, 187 LICHFIELD STREET
CNR LICHFIELD & BARBADOS STS.
P.O.BOX 8876 CHRISTCHURCH

SCALE :
DATE :
FILE :


A5b

SHED 22 - WELLINGTON


REVISION/ DESCRIPTION
1 AMEND FIREBOX SIZE & MOULDINGS
2 REMOVE BRICKWORK, ADD NOTES & DIMENSIONS, ALTER NUMBER
DATE 21/06/02
30/04/02

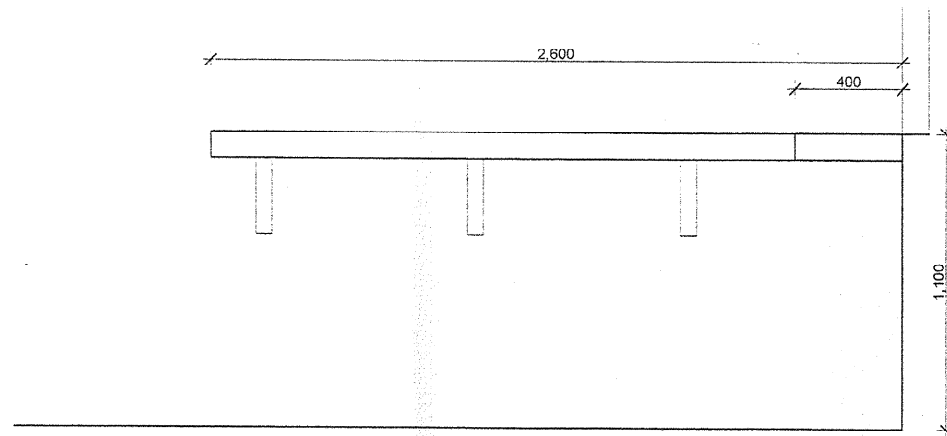


ELEVATION OF LEANER A SCALE 1:20

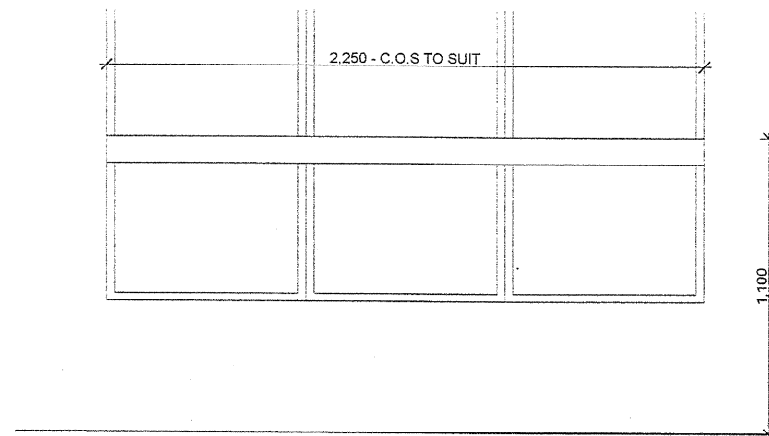


ELEVATION OF LEANER B SCALE 1:20

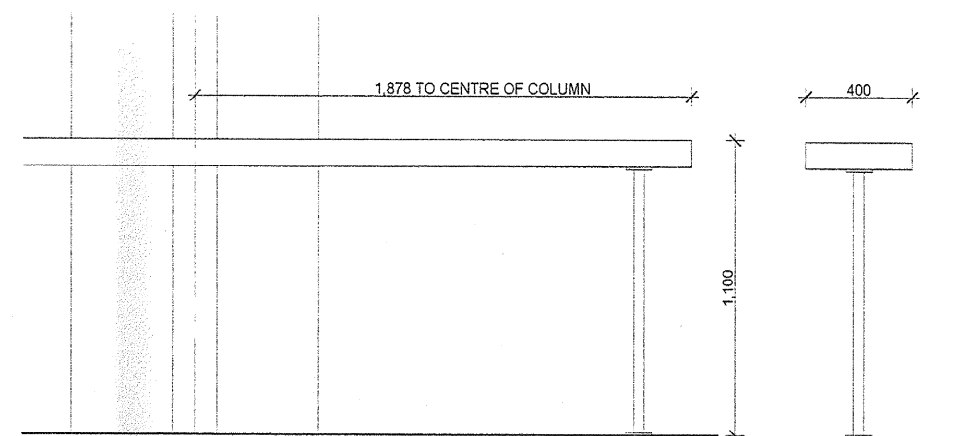


ELEVATION OF LEANER C SCALE 1:20

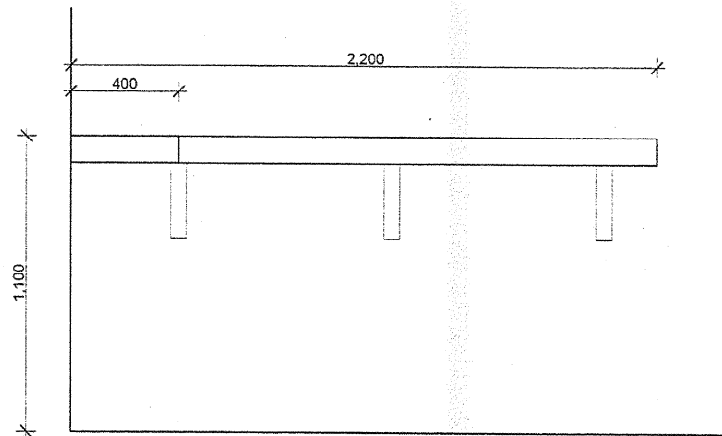


ELEVATION OF LEANER A SCALE 1:20

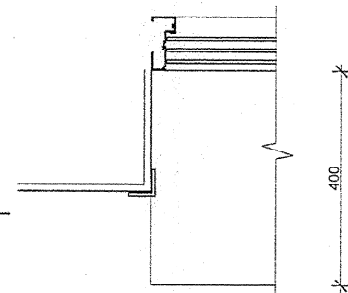


PLAN

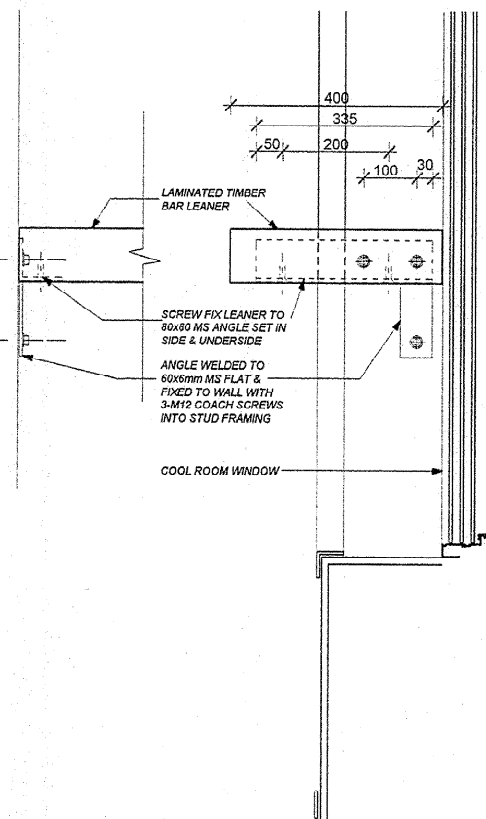


DETAILS FOR LEANER B SCALE 1:10

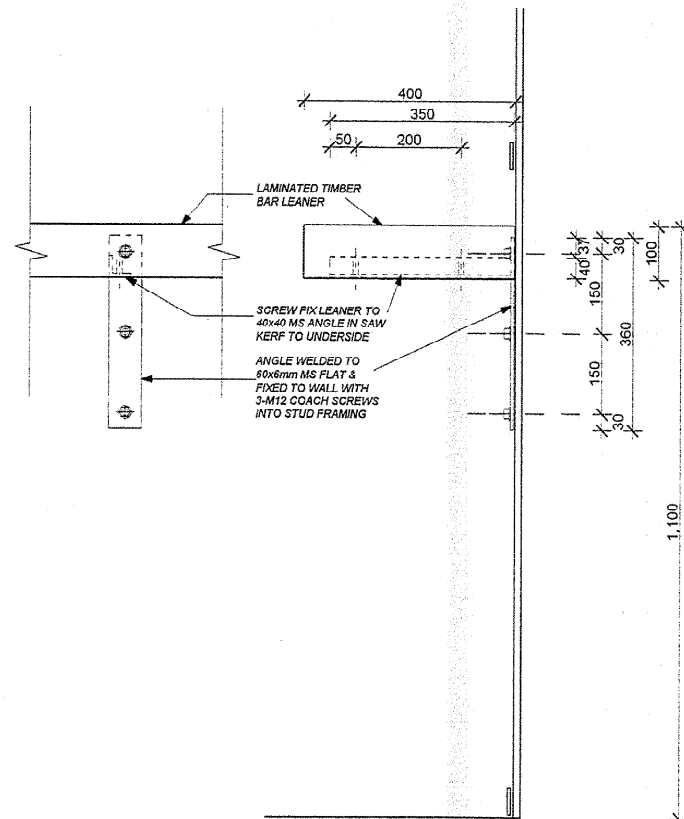

DETAILS FOR LEANER A SCALE 1:10

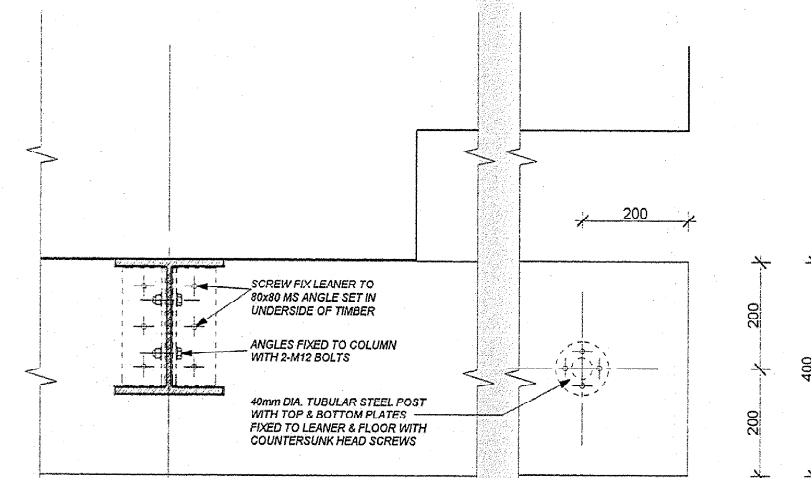

PLAN

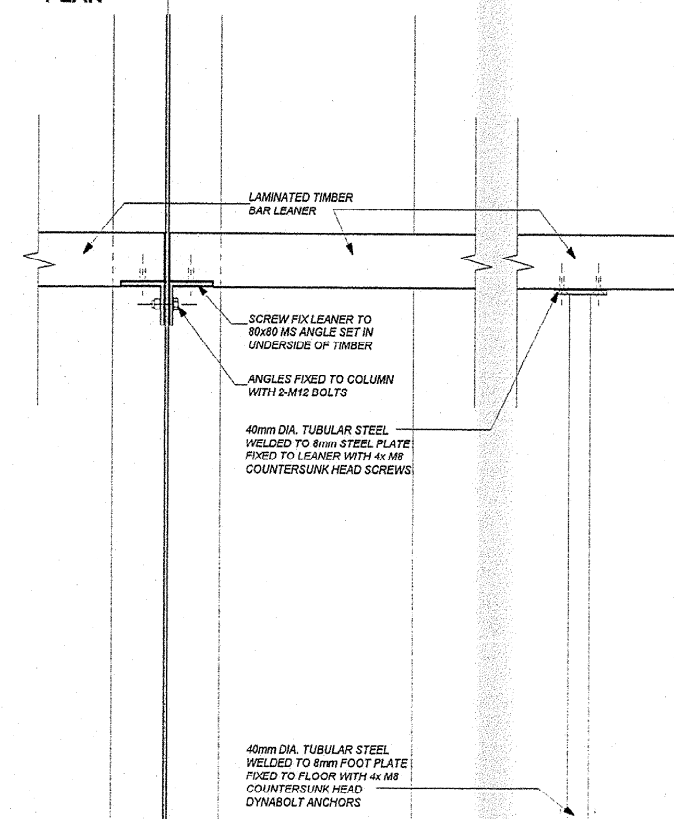


DETAILS FOR LEANER C SCALE 1:10

W.C.C. RECORDS

WELLINGTON CITY COUNCIL
SERVICES REQUEST No.



90586

APPROVED BUILDING
CONSENT DOCUMENTS

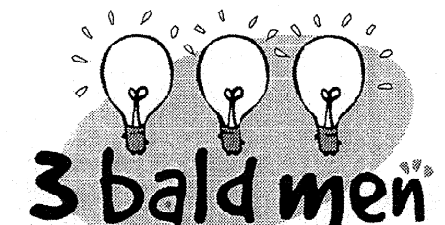

66 mandeville street . p o box 36210 . christchurch . new zealand
ph 64 3 343 6556 . fax 64 3 343 6566 . email info@3baldmen.co.nz

CONTRACTOR SHALL CHECK ALL DIMENSIONS PRIOR TO COMMENCING WORK
THIS DRAWING IS CONFIDENTIAL FOR SECURITY & COPYRIGHT

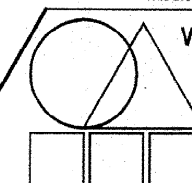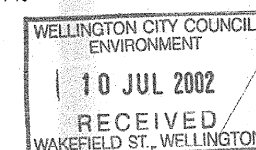

WARREN ARCHITECTURAL DESIGN
DIRECTOR :
PHONE/FAX :
EMAIL :
ADDRESS :
GEOFF WARREN NZC(ARCH) ADNZ
PHONE / FAX: (03) 365 9993
warrenarchitectural@clear.net.nz
FIRST FLOOR, 187 LICHFIELD STREET
CNR LICHFIELD & BARBADOS STS.
P.O. BOX 8876 CHRISTCHURCH


SCALE : 1:20 1:10
DATE : JUNE 2002
FILE : 0140

A5C


SHED 22 - WELLINGTON

REVISION / DESCRIPTION

DATE

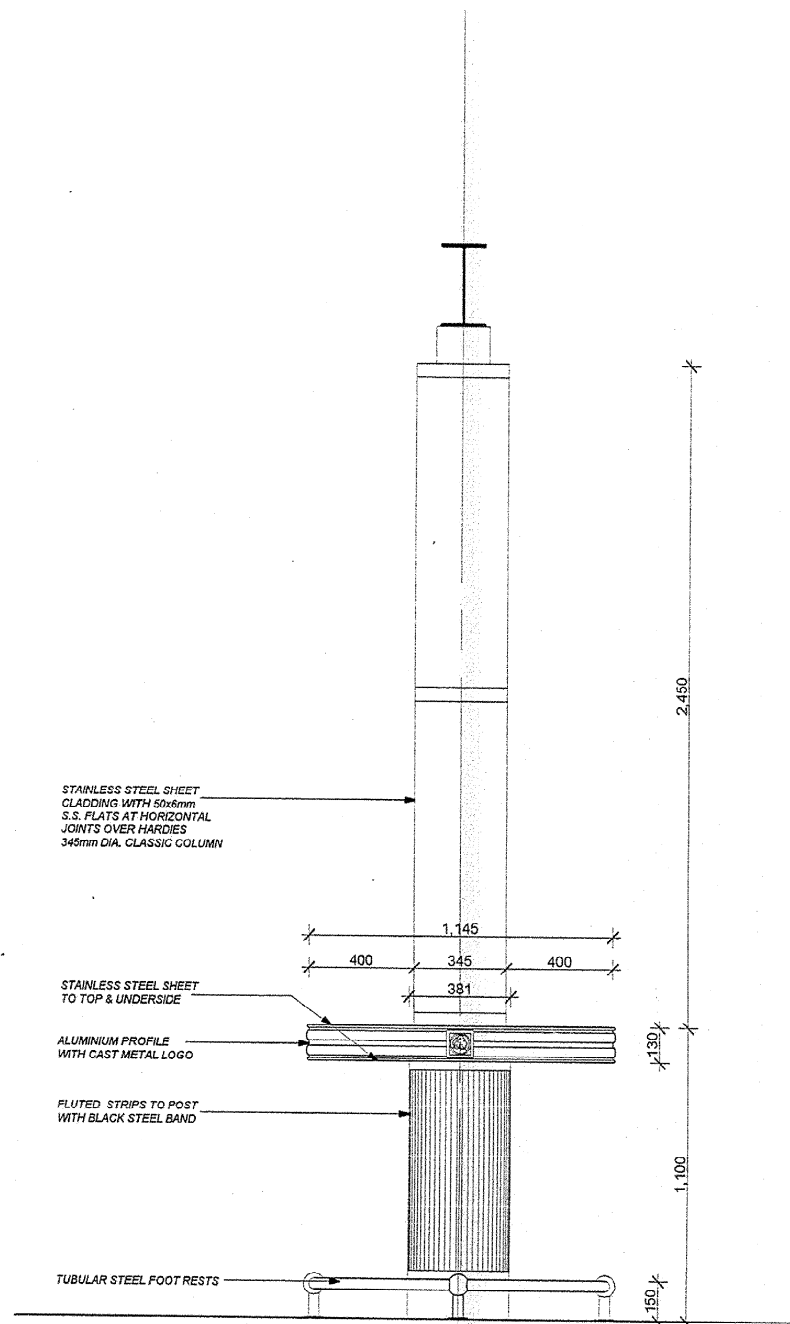

ELEVATION OF LEANER D SCALE 1:20

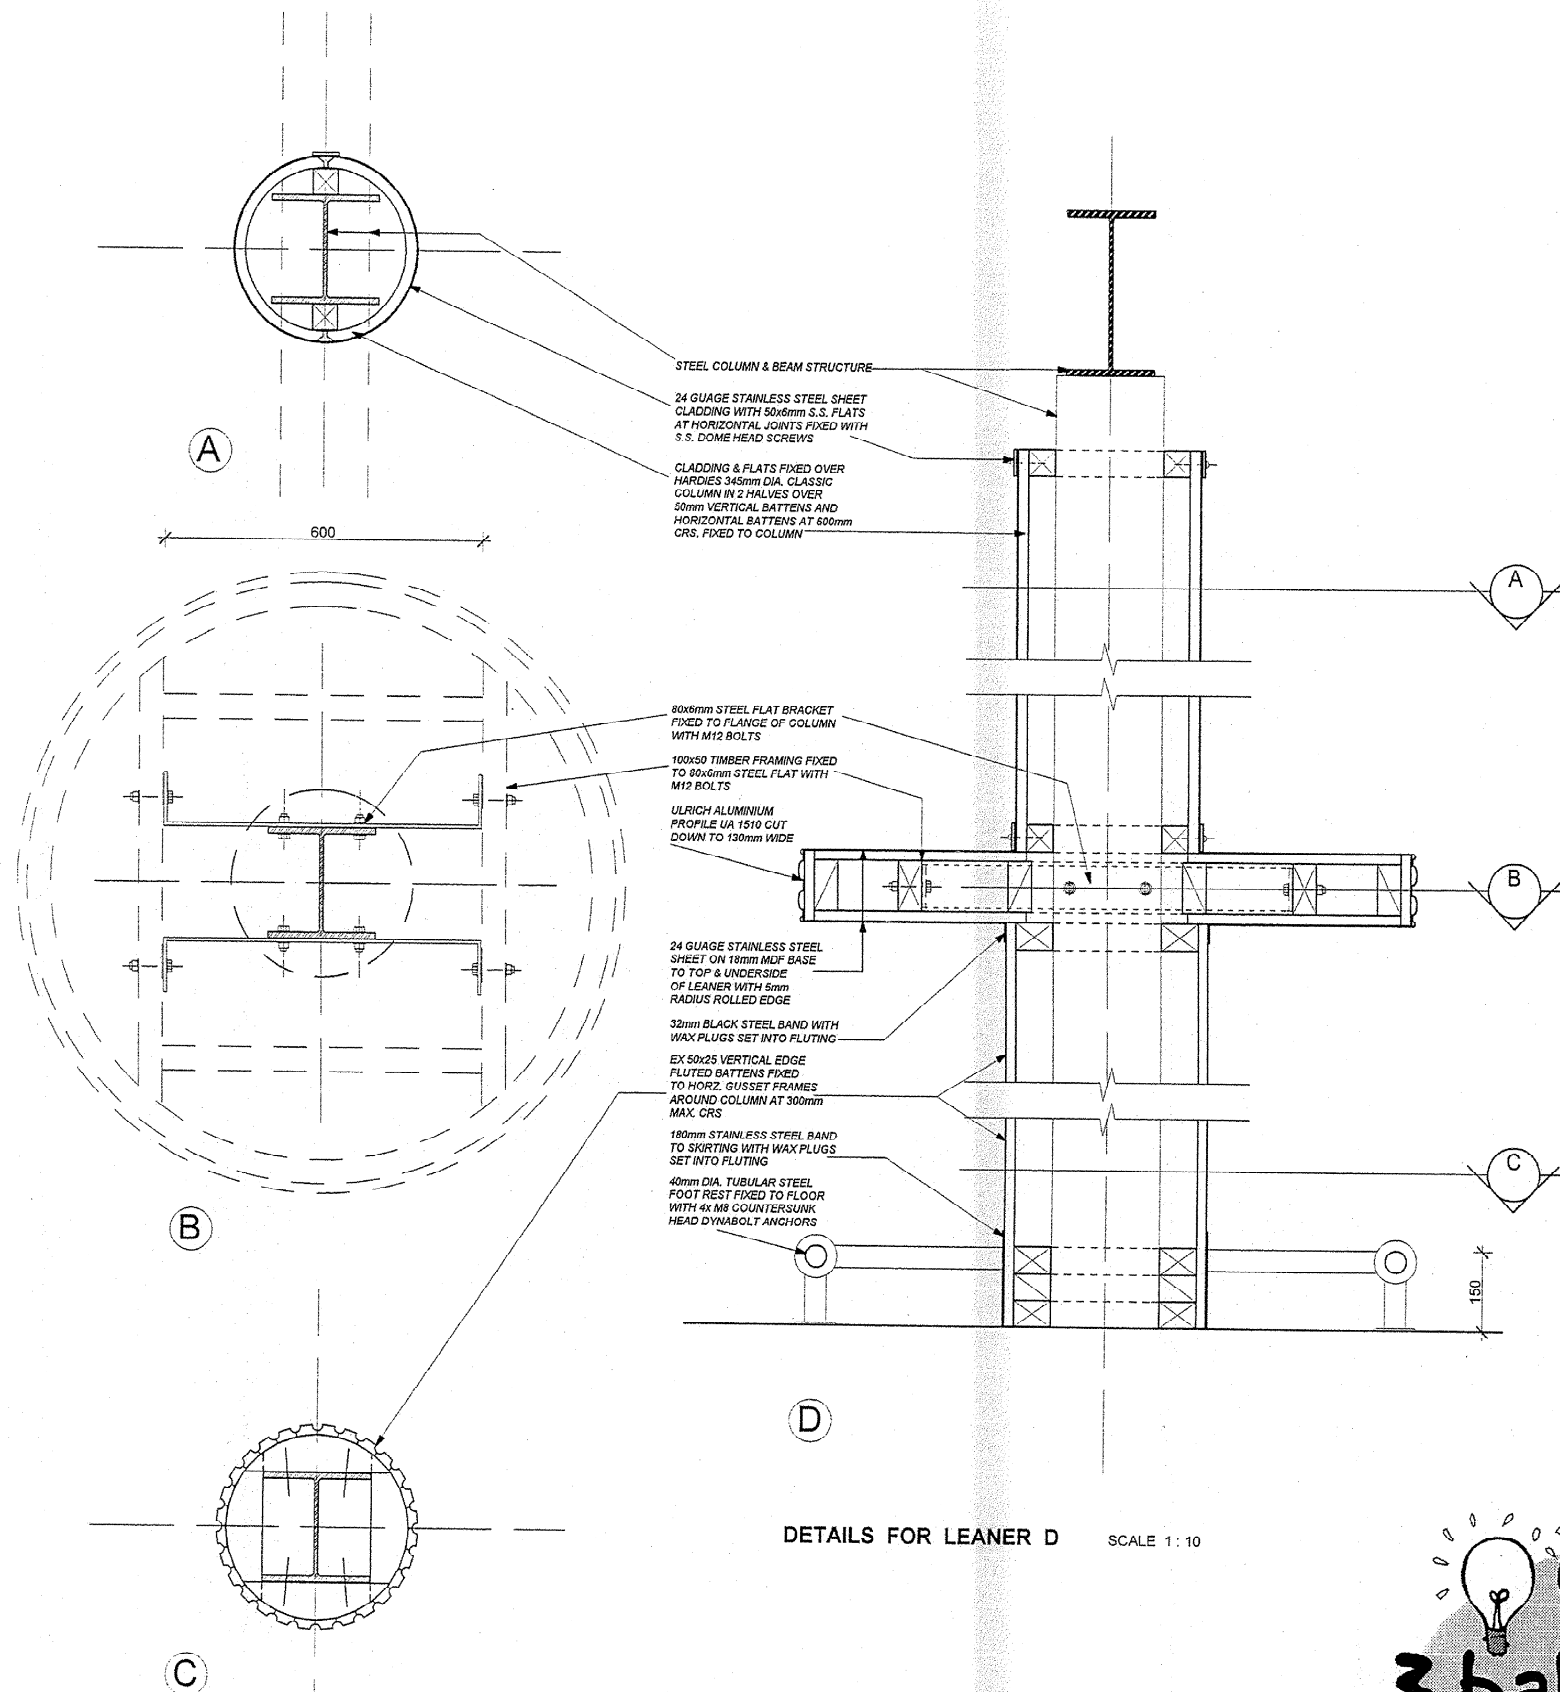


DETAILS FOR LEANER D SCALE 1:10

WELLINGTON CITY COUNCIL
SERVICES REQUEST No.

90586

APPROVED BUILDING
CONSENT DOCUMENTS

W.C.C.
RECORDS

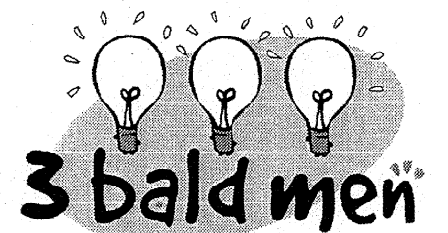

66 mandeville street . p o box 36210 . christchurch . new zealand
ph 64 3 343 6556 . fax 64 3 343 6566 . email info@3baldmen.co.nz

CONTRACTOR SHALL CHECK ALL DIMENSIONS PRIOR TO COMMENCING WORK
THIS DRAWING IS CONFIDENTIAL FOR SECURITY & COPYRIGHT

WARREN ARCHITECTURAL DESIGN

DIRECTOR :
PHONE/FAX : (03) 355 9993
EMAIL :
ADDRESS :
GEOFF WARREN NZCD(ARCH) ADNZ
FIRST FLOOR, 187 LICHFIELD STREET
CNR. LICHFIELD & BARBADOS STS.
P.O. BOX 8076 CHRISTCHURCH


SCALE : 1:20 1:10
DATE : JUNE 2002
FILE : 0140


A5d

SHED 22 - WELLINGTON

REVISION/ DESCRIPTION

DATE

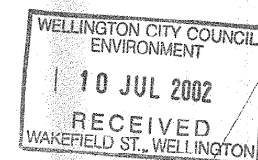


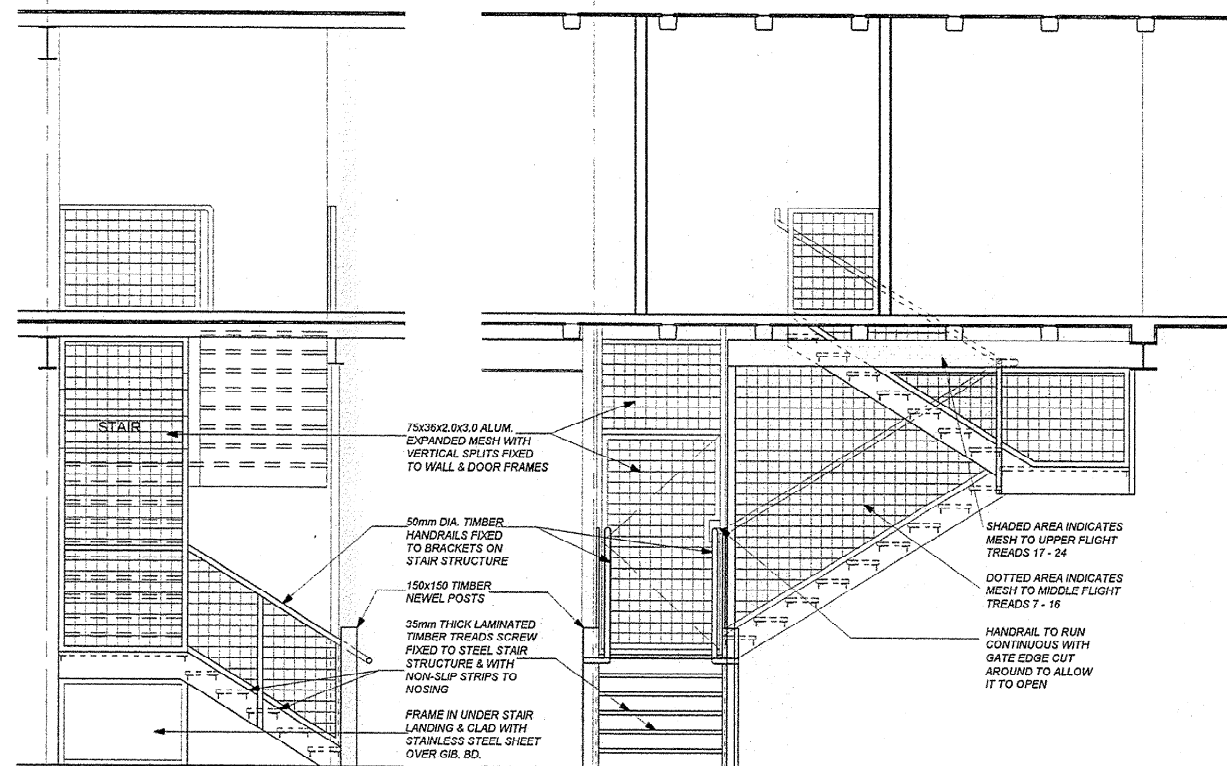


ELEVATION A

ELEVATION B

NOTE:
CONFIRM ALL STAIR
DIMENSIONS WITH
STRUCT. ENGINEERS

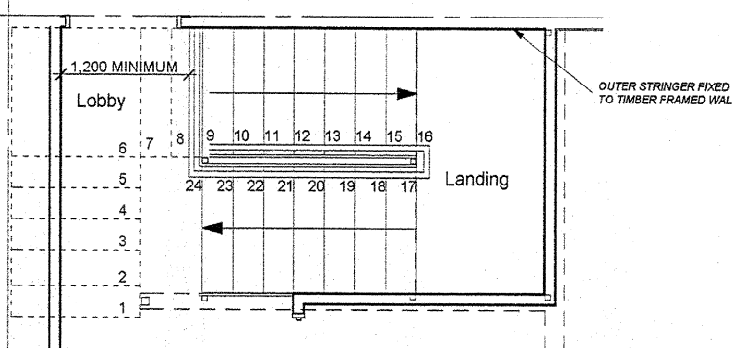

FIRST FLOOR PLAN

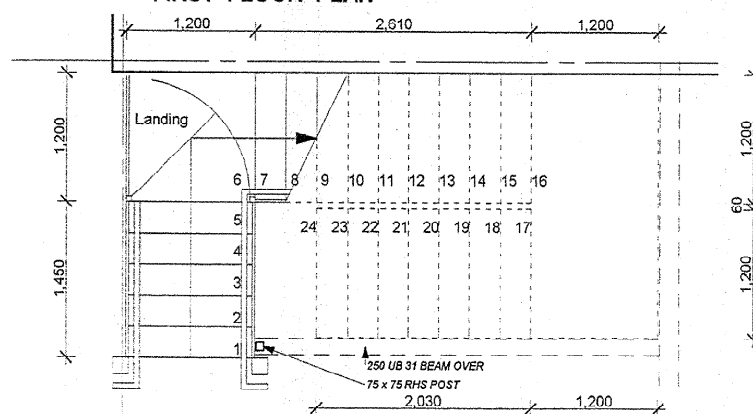

GROUND FLOOR PLAN


SCALE 1:50

ACCESS STAIR TO
FIRST FLOOR
VIEWING GALLERY

**W.C.C.
RECORDS**


WELLINGTON CITY COUNCIL
SERVICES REQUEST NO.

90586

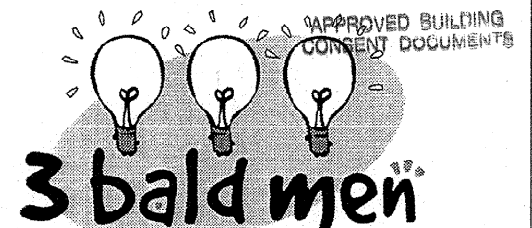

66 Māndeville Street, P.O. Box 36210, Christchurch, New Zealand
Ph 64 3 343 6556, Fax 64 3 343 6566, email info@3baldmen.co.nz

CONTRACTOR SHALL CHECK ALL DIMENSIONS PRIOR TO COMMENCING WORK
THIS DRAWING IS CONFIDENTIAL FOR SECURITY & COPYRIGHT

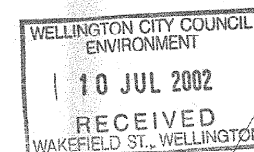

WARREN ARCHITECTURAL DESIGN

DIRECTOR: GEOFF WARREN NZCD(ARCH.) ADNZ
PHONE/FAX: (03) 355 9993
EMAIL: warrenarchitectural@clear.net.nz
ADDRESS: FIRST FLOOR, 187 LICHFIELD STREET
CNR. LICHFIELD & BARBADOS STS.
P.O. BOX 8876 CHRISTCHURCH


SCALE: 1:50
DATE: MAY 2002
FILE: 0140

A6

SHED 22 - WELLINGTON


1 ADD NOTES
REVISION/ DESCRIPTION

21/05/02
DATE

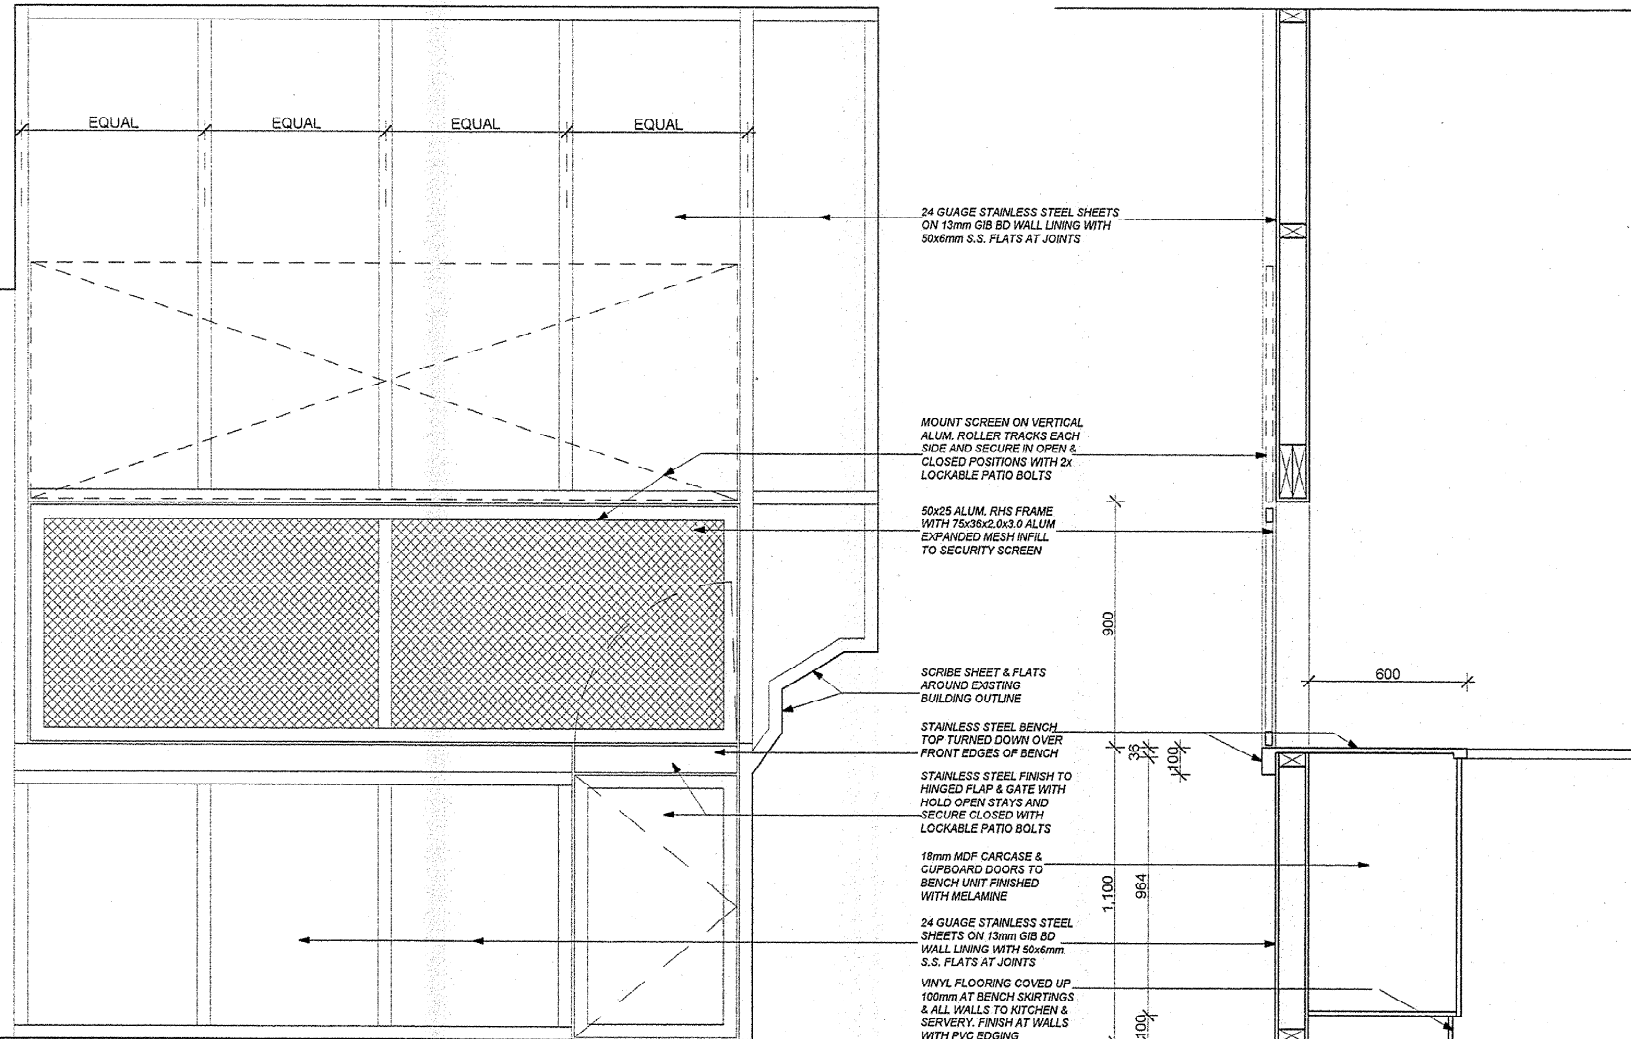


ELEVATION OF OUTDOOR SERVERY SCALE 1:20

SECTION THROUGH OUTDOOR SERVERY

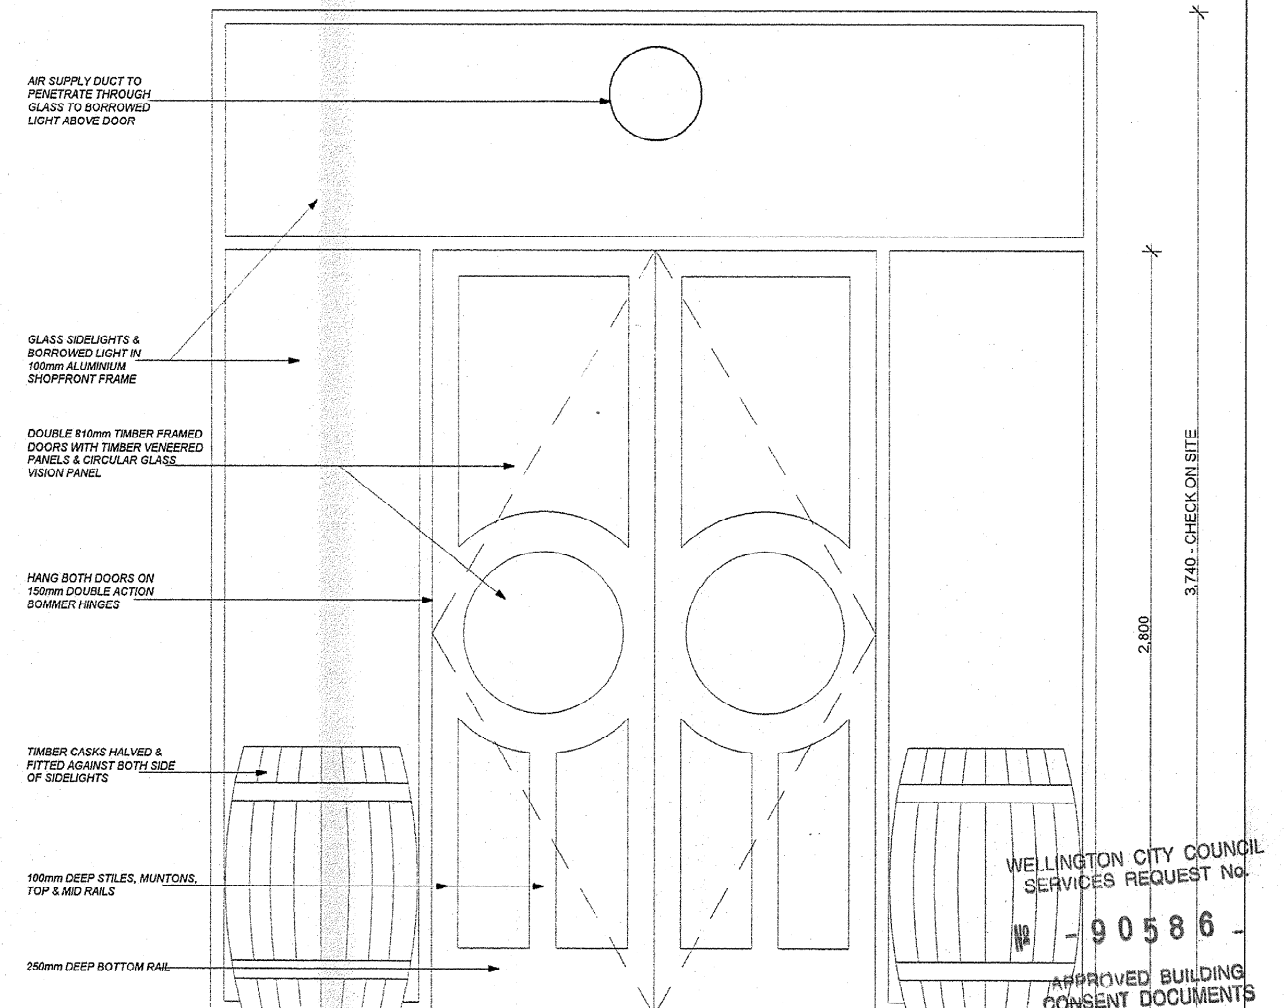


ELEVATION OF DOORS TO SERVERY SCALE 1:20

SHED 22 - WELLINGTON

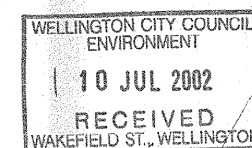

66 mandeville street . p o box 36210 . christchurch . new zealand
ph 64 3 343 6556 . fax 64 3 343 6566 . email info@3baldmen.co.nz

CONTRACTOR SHALL CHECK ALL DIMENSIONS PRIOR TO COMMENCING WORK
THIS DRAWING IS CONFIDENTIAL FOR SECURITY & COPYRIGHT

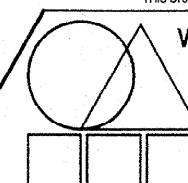

WARREN ARCHITECTURAL DESIGN


DIRECTOR :
PHONE/FAX :
EMAIL :
ADDRESS :
GEOFF WARREN NZCD(ARCH) ADNZ
PHONE / FAX : (03) 365 9993
warrenarchitectural@clear.net.nz
FIRST FLOOR, 187 LICHFIELD STREET
CNR. LICHFIELD & BARBADOS STS.
P.O. BOX 8076 CHRISTCHURCH

SCALE :
DATE :
FILE :
1:20
JUNE 2002
0140


A6a

REVISION / DESCRIPTION


DATE

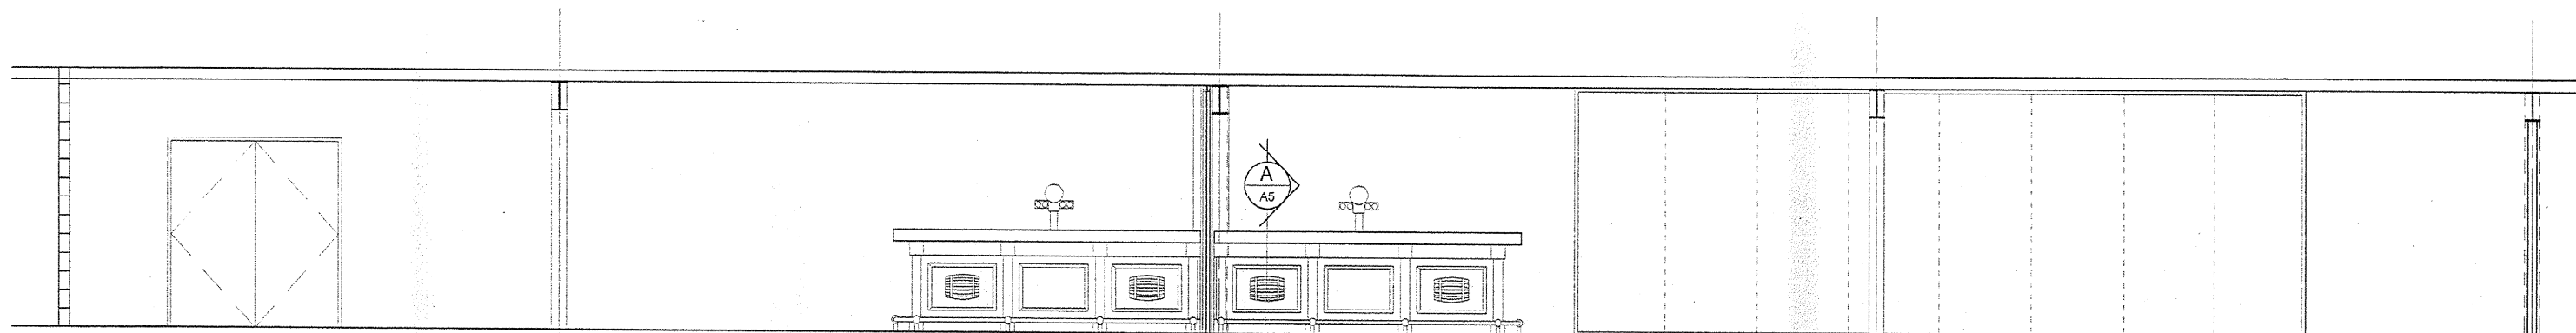


ELEVATION OF BAR & CONFERENCE ROOM

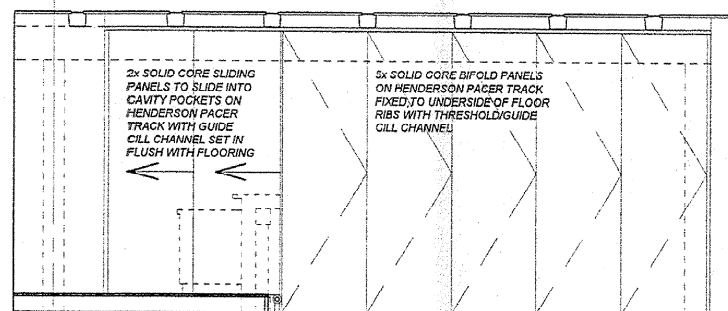


SLIDING / BIFOLD DOOR ELEVATION

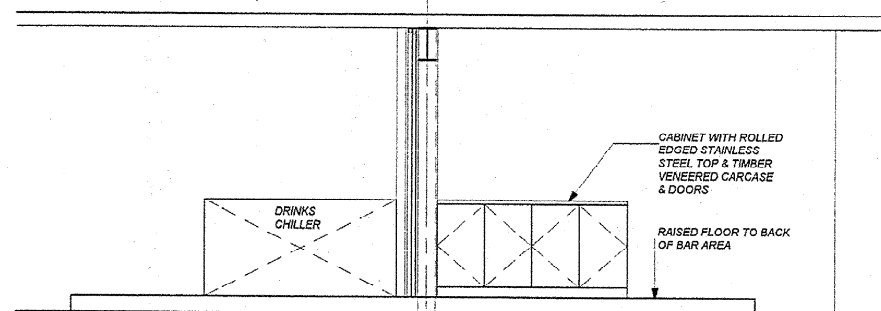

ELEVATION OF BACK OF BAR

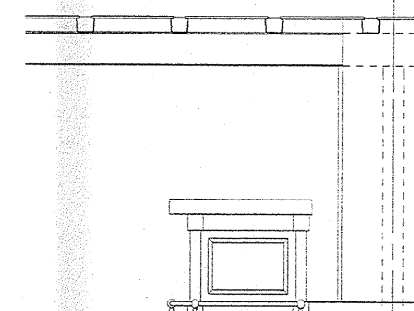


SIDE ELEVATION OF BAR

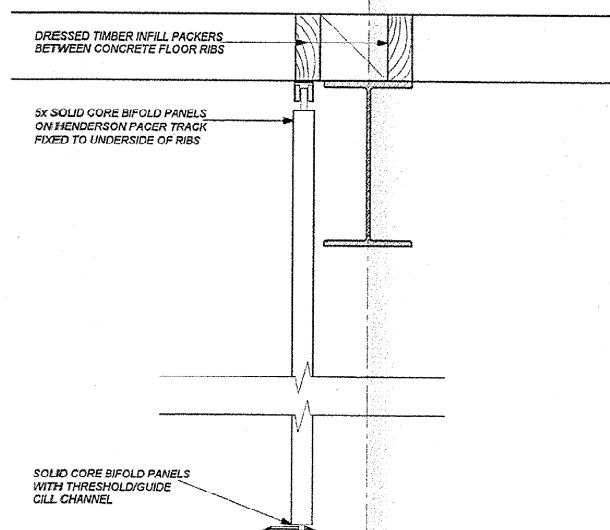

DETAIL AT BIFOLD DOOR

SCALE 1:10

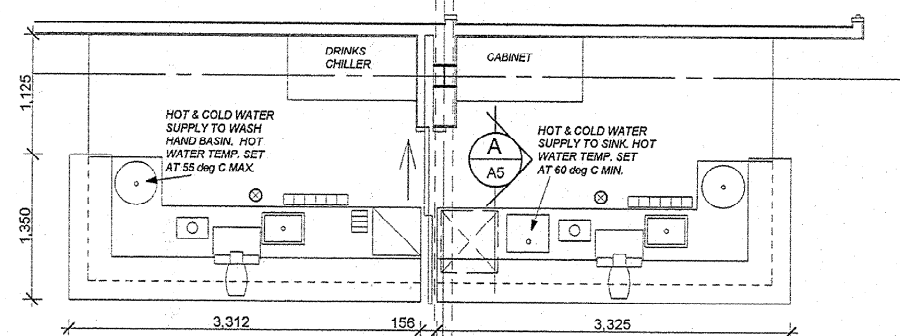

PLAN OF BAR SCALE 1:50

FIRST FLOOR BAR / CONFERENCE ROOM

BAR LEGEND

- STAINLESS STEEL SINK UNIT
- HAND BASIN
- GLASSWASHER
- PURPOSE MADE GLASS RINSER
- CASH REGISTER
- EFTPOS TERMINAL

- BEER DISPENSER WITH DRIP TRAY
- 6 SPIRIT BOTTLE SPEED RACK
- ICE BIN
- POSTMIX GUNS TO CONNECT TO REMOTE STORAGE IN COOL ROOM

NOTE:
CONFIRM SIZES & CLEARANCES
REQUIRED FOR ALL FITTINGS &
APPLIANCES PRIOR TO STARTING
CONSTRUCTION OF JOINERY UNITS

**W.C.C.
RECORDS**

WELLINGTON CITY COUNCIL
SERVICES REQUEST NO


90586

APPROVED BUILDING
CONSENT DOCUMENTS



66 mandeville street . p o box 36210 . christchurch , new zealand
ph 64 3 343 6556 . fax 64 3 343 6566 . email info@3baldmen.co.nz

CONTRACTOR SHALL CHECK ALL DIMENSIONS PRIOR TO COMMENCING WORK
THIS DRAWING IS CONFIDENTIAL FOR SECURITY & COPYRIGHT

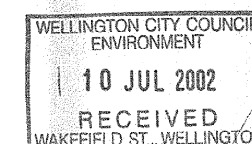

WARREN ARCHITECTURAL DESIGN

DIRECTOR:
PHONE/FAX: GEOFF WARREN NZQA(ARCH) ADNZ
EMAIL: (03) 365 9993
ADDRESS: warrenarchitectural@clear.net.nz
FIRST FLOOR, 187 LICHFIELD STREET
CNR LICHFIELD & BARBADOS STS.
P.O. BOX 8876 CHRISTCHURCH











SCALE: 1:50 1:10
DATE: MAY 2002
FILE: 0140

A6b

SHED 22 - WELLINGTON

1 ADD NOTES, DETAILS & DIMENSIONS. AMEND NUMBER
REVISION DESCRIPTION

        24/08/02
DATE

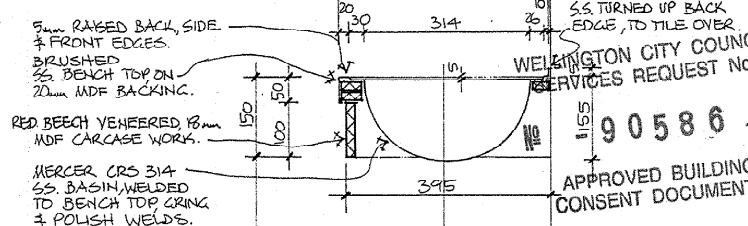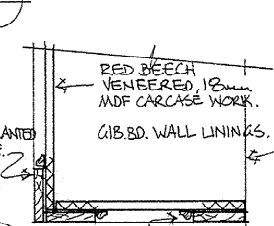

- W.C. PANS - MEACER S.S. W.C. PAN #301. • ACCESS
- W.C. SEATS - CAROMA TRIDENT, WHITE. #30104. • TOILE
- W.C. CISTERNS - CAROMA GLT WATER WAFER #227001 & KIT #227102 CS. • HOT
- URINALS - SISSONS S.S. RDB URINAL #22 0494N. • ACCESS
- URINAL FLUSH CONTROL - PAREX WATER SAVER SOLENOID #NG-FM. • VALV
- ACCESSABLE W.C. PAN - MEACER S.S. W.C. PAN. #GT. • FLO
- ACCESSABLE W.C. SEAT - CAROMA COLANI, WHITE. #815100. •
- ACCESSABLE W.C. CISTERN - CAROMA SOVEREIGN, WHITE. #127120 & KITS #405067 & #43276. •
- ACCESSABLE W.C. RAIL - JAEKO S.S. GRAB RAIL #GR 750 X 750. •
- ACCESSABLE SHOWER RAIL - JAEKO S.S. GRAB RAIL #GR 750 X 750. •
- ACCESSABLE SHOWER MIXER - METHVEN FUTURA MIXER #FU 2D10 CP. •
- ACCESSABLE SHOWER SLIDE - METHVEN VERDI SLIDE & COUPLING SET #SHRY. & HANSGROHE #28346000. •

- METAL MACHINISTS SHOWER SEAT
 - * C07/304/PL1 900mm x 400mm
- ESCO ESPRIMO HOLDER
- #E10000 CHROME
- PENSIVE SUPREME DRIVER
- #E 2002 BRUSHED ALUMINIUM.
- INDA HOTEL ERJE //METRIX BOTTLE TRAP
- #B01ZLX322
- PLUMB LINE, PONSI, SINGLE HOLE MIXER, # 403 NS.
- STAINLESS STEEL CAPS TO FLOOR WASTES IN ATFIELD ARCHITECTS LIMITED BASE BUILDING SPEC.

WELLINGTON CITY COUNCIL
ENVIRONMENT
10 JUL 2002
RECEIVED
WAKFIELD ST., WELLINGTON

THIS DRAWING IS CONFIDENTIAL FOR SECURITY & COPYRIGHT ©



WARREN ARCHITECTURAL DESIGN.

DIRECTOR: GEOFF WARREN, NZCD (ARCH), ADINZ.
PHONE: 343 9937 FAX: 343 9947
E-MAIL: warrenarchitectural@clear.net.nz.
ADDRESS: 2 KAURI STREET, RICCARTON
P.O. BOX 8876, CHRISTCHURCH


DATE: MAY 2002
SCALE: 1:50, 1:10
FUR-LIAD




Handwritten number 27 with stroke order arrows.

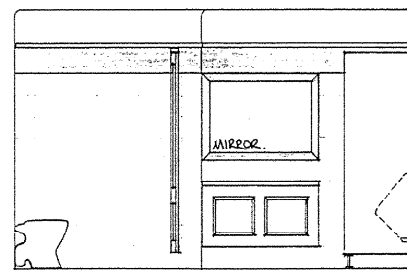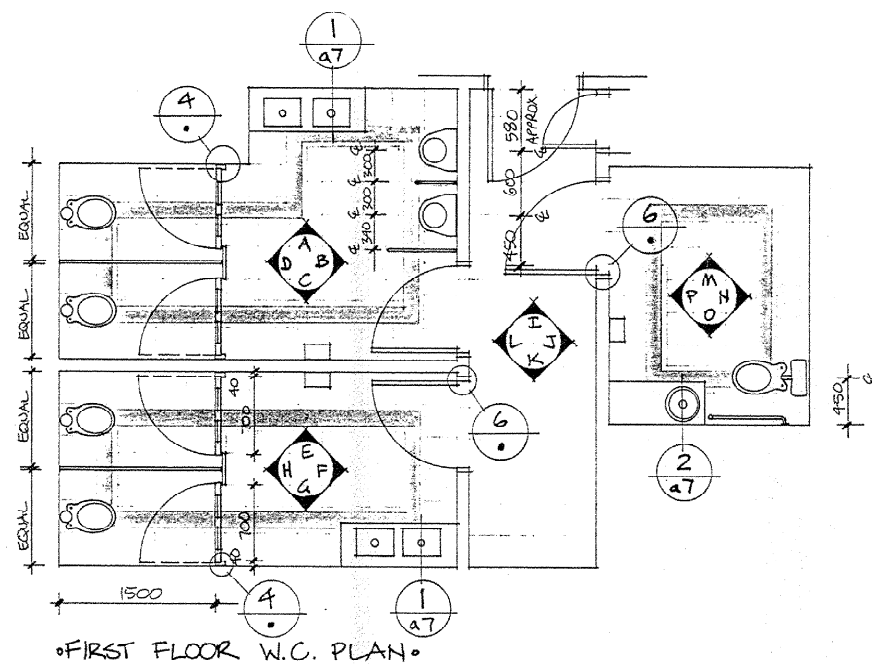


ELEVATION A

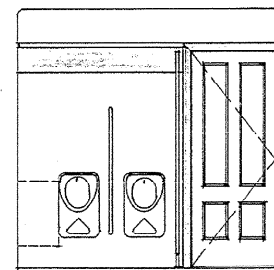


ELEVATION B

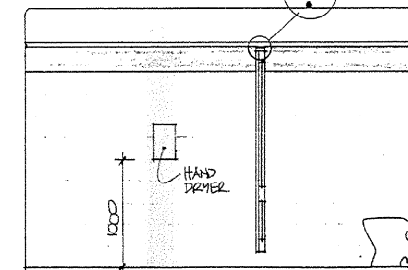


ELEVATION C

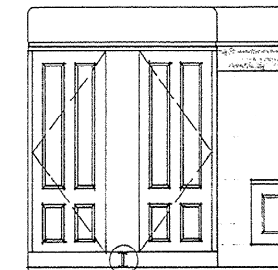


ELEVATION D

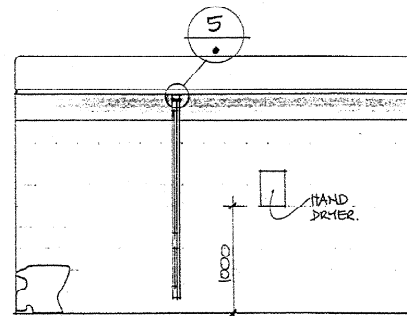


ELEVATION E

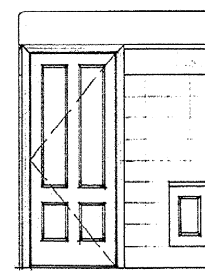




ELEVATION F

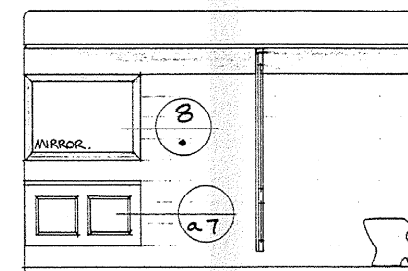


ELEVATION G

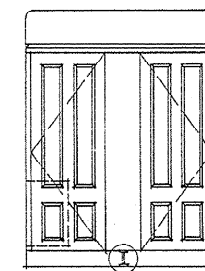


ELEVATION H

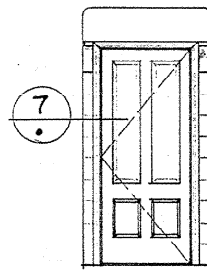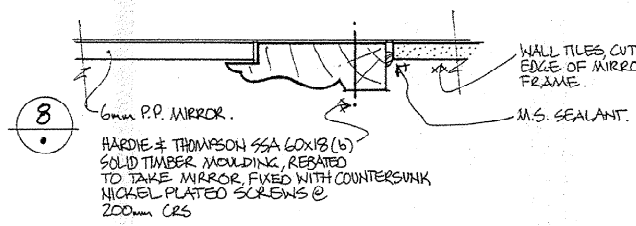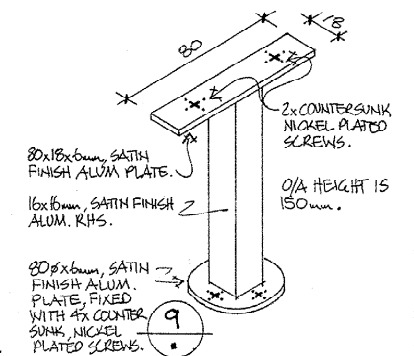


ELEVATION I

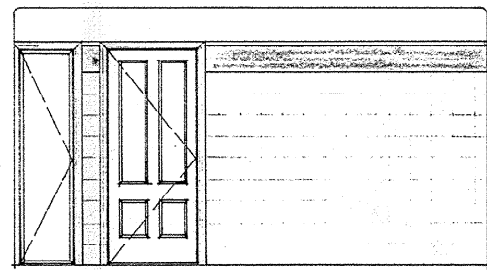


ELEVATION J

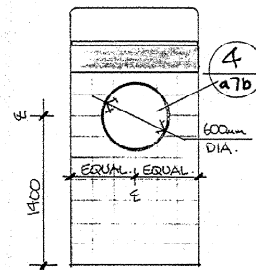


ELEVATION K

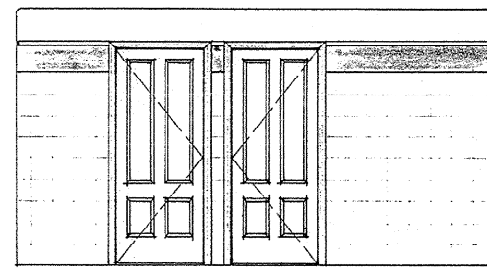


ELEVATION L

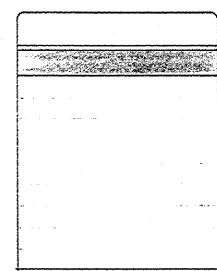


ELEVATION M

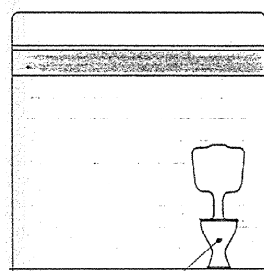


ELEVATION N

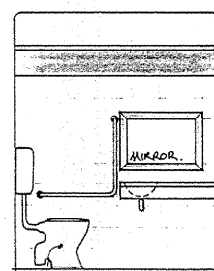


ELEVATION O

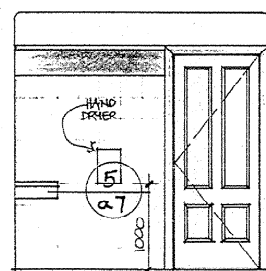


ELEVATION P

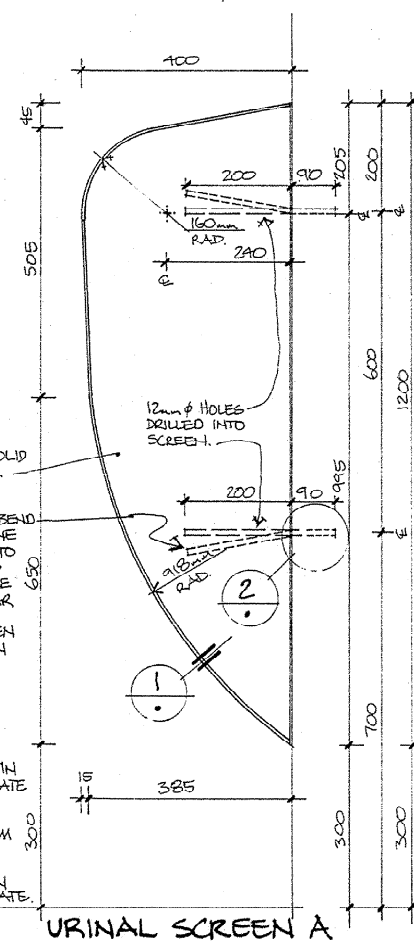

URINAL SCREEN A

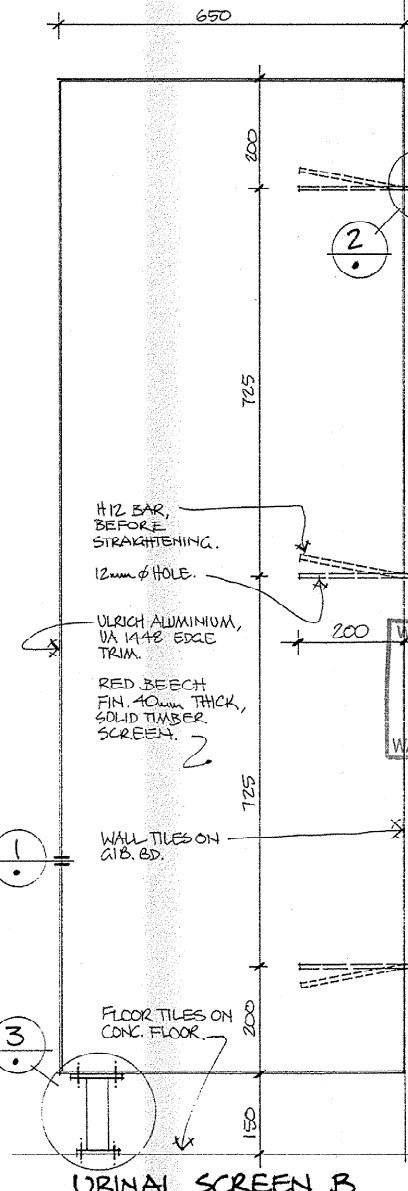

URINAL SCREEN B

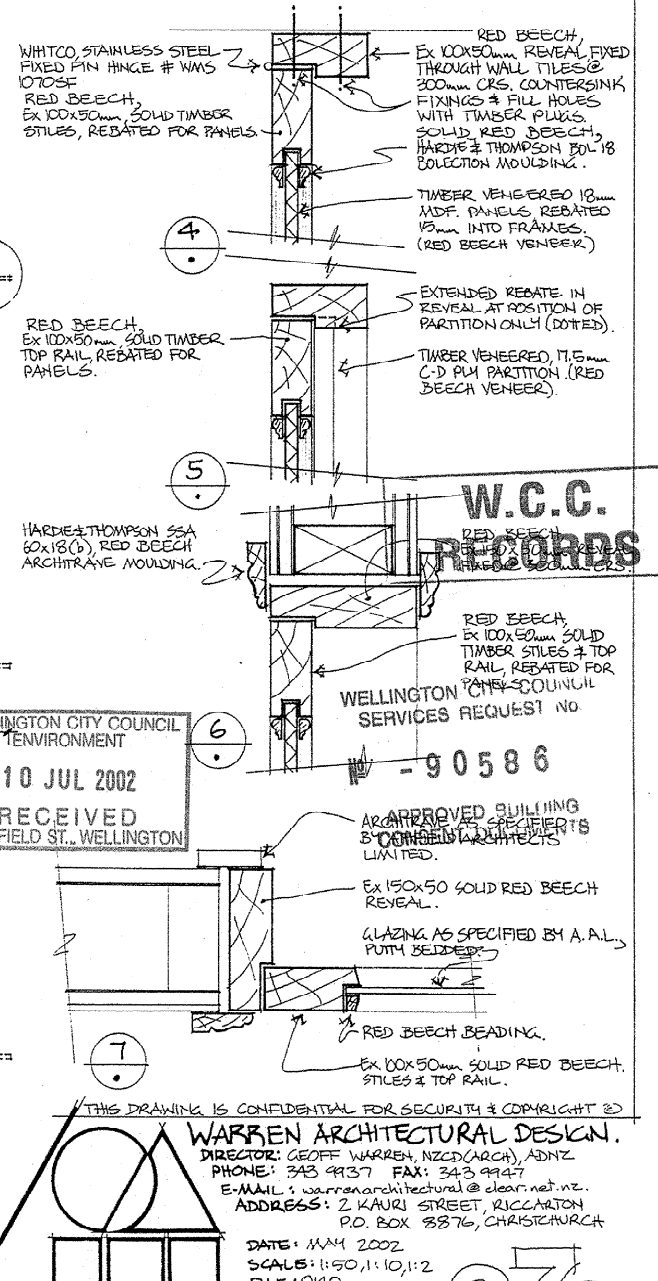


W.C.C. RECORDS


RECEIVED
10 JUL 2002
WAKEFIELD ST., WELLINGTON

THIS DRAWING IS CONFIDENTIAL FOR SECURITY & COPYRIGHT ©
WARREN ARCHITECTURAL DESIGN.
DIRECTOR: GEOFF WARREN NZCO (ARCH), ADMZ
PHONE: 343 9937 FAX: 343 9947
E-MAIL: warrenarchitectural@clear.net.nz
ADDRESS: 2 KAUAI STREET, RICCARTON
P.O. BOX 8876, CHRISTCHURCH
DATE: MAY 2002
SCALE: 1:50, 1:10, 1:2
FILE: 0140


a7a

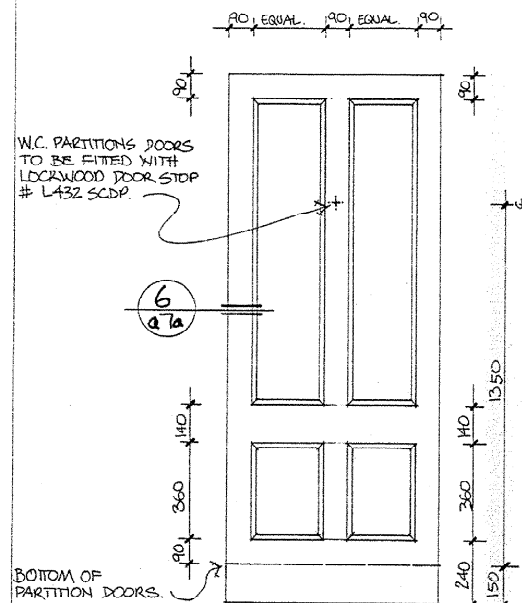


DOORS 1D05, 1D07, 1D08
W.C. PARTITION DOORS x 3

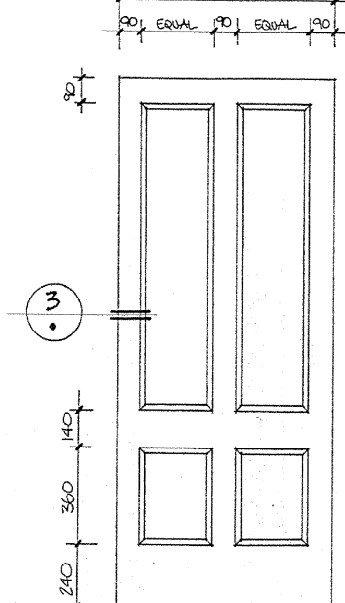

DOORS 1D12, 1D13,
1D14, 1D16

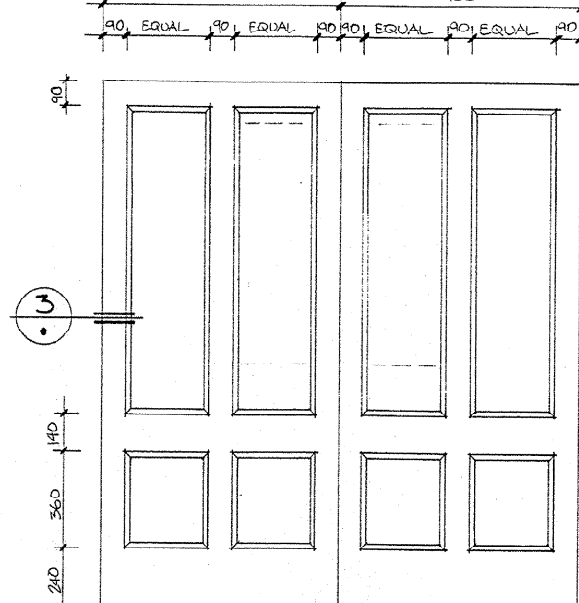


DOORS 1D15

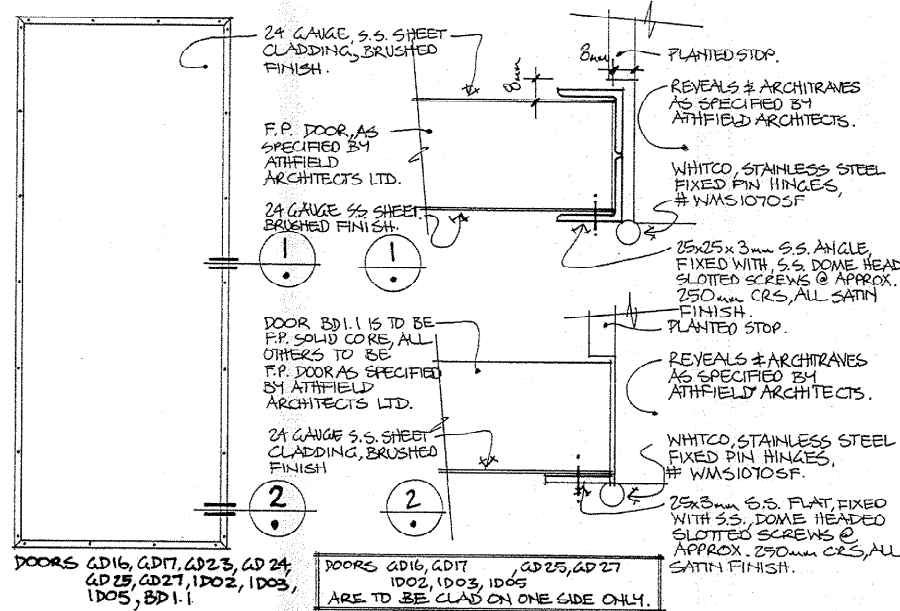


DOORS 1D16, 1D17, 1D23, 1D24,
1D25, 1D27, 1D02, 1D03,
1D05, 1D11

DOORS 1D16, 1D17, 1D23, 1D24,
1D25, 1D27, 1D02, 1D03,
1D05, 1D11
ARE TO BE CLAD ON ONE SIDE ONLY.


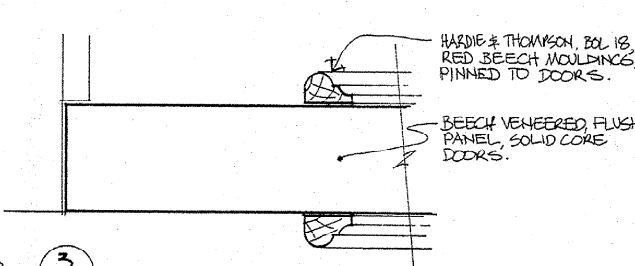


DOORS 1D13 & 1D16 TO BE
METAL CLAD ON ONE
SIDE, AS PER DETAIL 2
ON THIS PAGE.

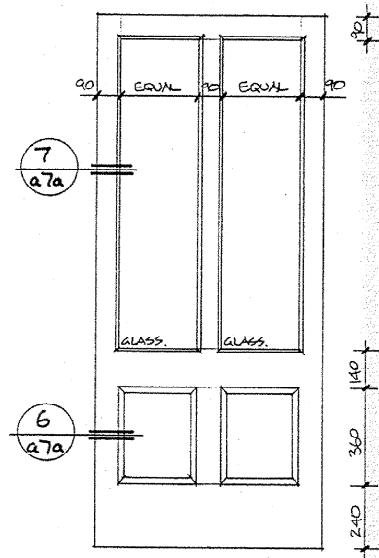

DOORS 1D18, 1D04

NOTE: ALL DOOR HARDWARE AS SPECIFIED
BY ATHFIELD ARCHITECTS LIMITED,
EXCEPT: 1) DOOR HINGES TO BE WHITECO
STAINLESS STEEL FIXED PIN
HINGE # WMS1070 SF
2) NOT SOPSERS PUSH PLATE,
USE SCHLAGE 8910 PUSH PLATE.

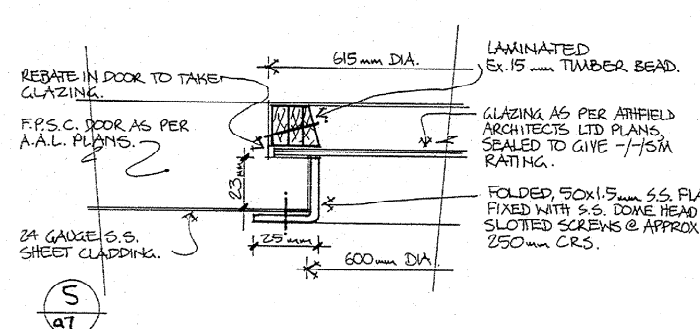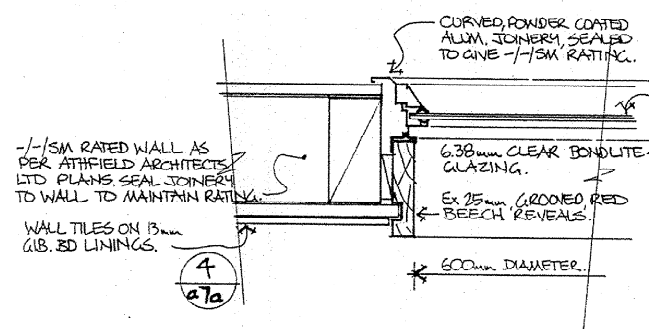

WELLINGTON CITY COUNCIL
SERVICES REQUEST

90586

APPROVED BUILDING
CONSENT DOCUMENTS


W.C.C.
RECORDS

WELLINGTON CITY COUNCIL
ENVIRONMENT
10 JUL 2002
RECEIVED
WAKEFIELD ST., WELLINGTON

THIS DRAWING IS CONFIDENTIAL FOR SECURITY & COPYRIGHT ©
WARREN ARCHITECTURAL DESIGN.
DIRECTOR: GEOFF. WARREN, NZCP(ARCH), ADNZ.
PHONE: 343 9937 FAX: 343 9947
E-MAIL: warrenarchitectural@clear.net.nz.
ADDRESS: 2 KAUHI STREET, RICCARTON,
P.O. BOX 8876, CHRISTCHURCH.
DATE: MAY 2002
SCALE: 1:20, 1:1
FILE: 0140



a7b

NORTH

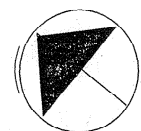

NOTE:

- CUT INTO MAIN (M.T.)
- NEW SPRINKLER ADDED
- SPRINKLER RELOCATED

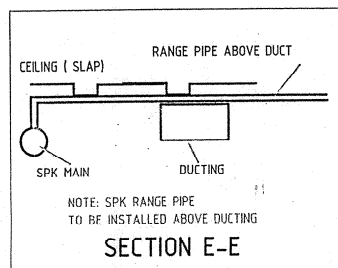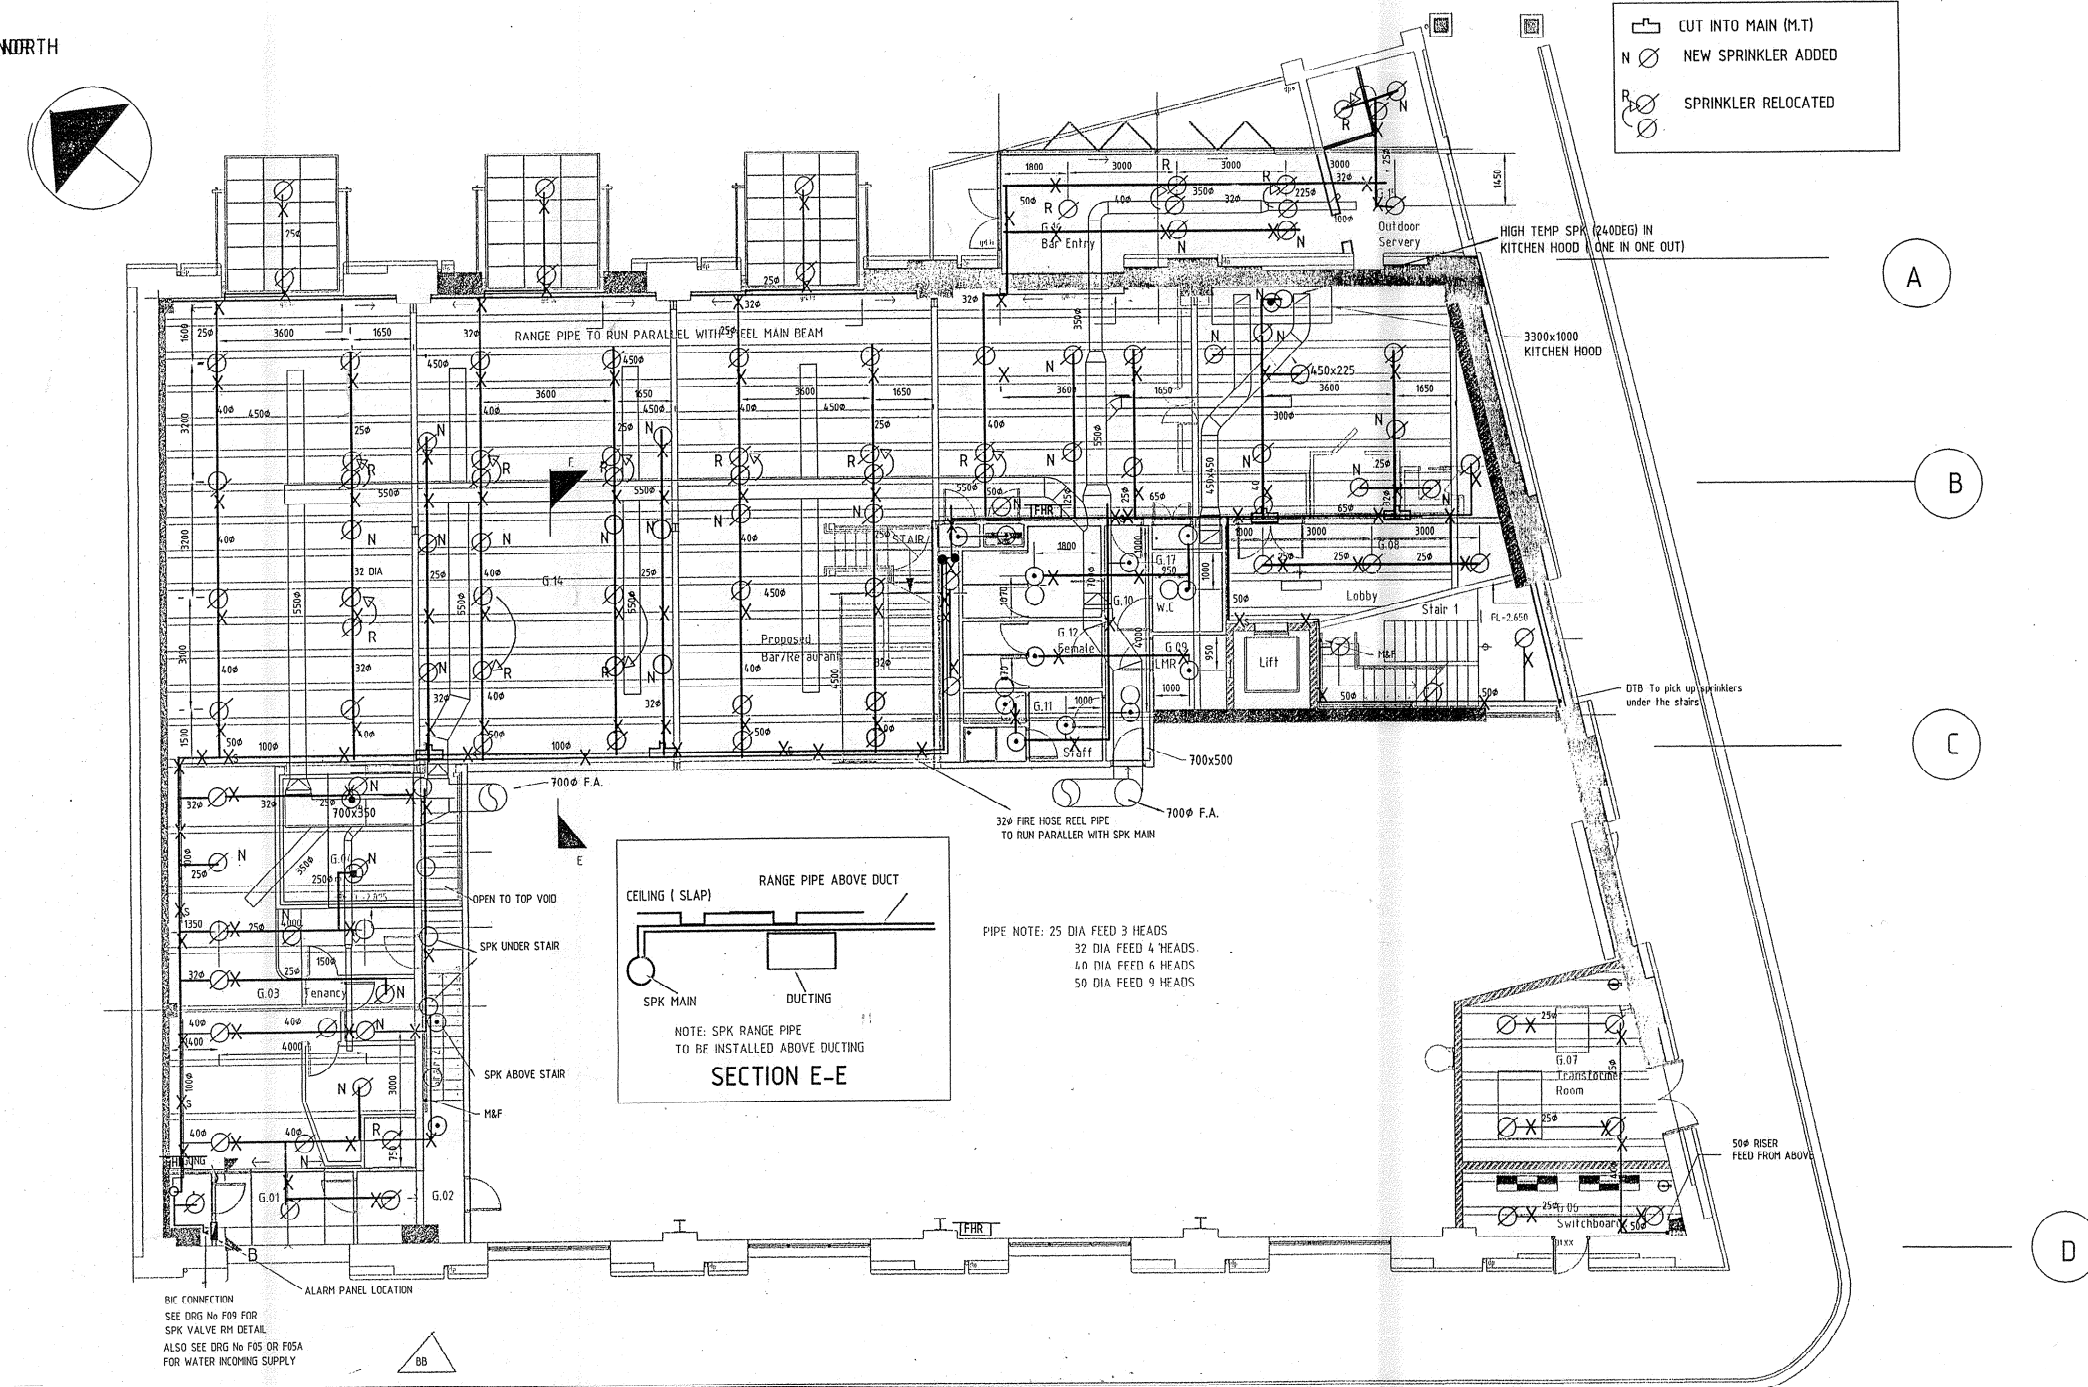

PIPE NOTE: 25 DIA FEED 3 HEADS
32 DIA FEED 4 HEADS
40 DIA FEED 6 HEADS
50 DIA FEED 9 HEADS

CABLE STREET

LEGEND

	PIPE HANGER AS SHOWN		CEILING SPACE SPK 15MMX93 DEG BRASS
	SEISMIC PIPE HANGER		SPK MOUNTED ON PIPE 15MMX68 DEG BRASS
	SPK ON DROP 'C' 15MM X 68 DEG		FIRE EXTINGUISHER (MULTI PURPOSE 4.5 KG)
	DD SPK CHROME 15MM X 69 DEG		F.H.R. (GRINNELL 13MMX 25M RECESSED)

DRAWING DISTRIBUTION		ISSUE/DATE/INITIALS					ISSUE	DATE	REVISION		DRAWN	BRUCE LEE
DISTRIBUTED TO	COPIES	A	B	C	D	E	A	17/6/02	FOR APPROVAL		DATE	17/6/02
WORKSHOP											SCALE	1:100
SITE	3										DESIGN CHECK'D	
LT MCGUINNESS	3										APP'D	
OTHERS											JOB No	9911

SHED 22 TENANCY
CABLE ST

SPRINKLER LAYOUT GROUND FLOOR
FIRE PROTECTION

WELLINGTON CITY COUNCIL
SERVICES REQUEST No.

- 90586

APPROVED BUILDING
CONSENT DOCUMENTS

W.C.C.
RECORDS

WELLINGTON CITY COUNCIL
ENVIRONMENT
10 JUL 2002
RECEIVED
WAKEFIELD ST., WELLINGTON

19 JUN 2002
L. T. McGuinness

AQUAHEAT INDUSTRIES LIMITED
92-96 MAIN ROAD TAWA WELLINGTON
PH:(04) 232-5179 FAX:(04) 232-4170


DRAWING No

9911/FS1

ISSUE


A

NORTH

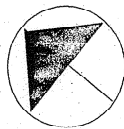

NOTE:

- PENETRATION THROUGH RIB
- CUT INTO MAIN (M.T)
- NEW SPRINKLER ADDED
- SPRINKLER RELOCATED
- NEW MCP
- NEW SIREN

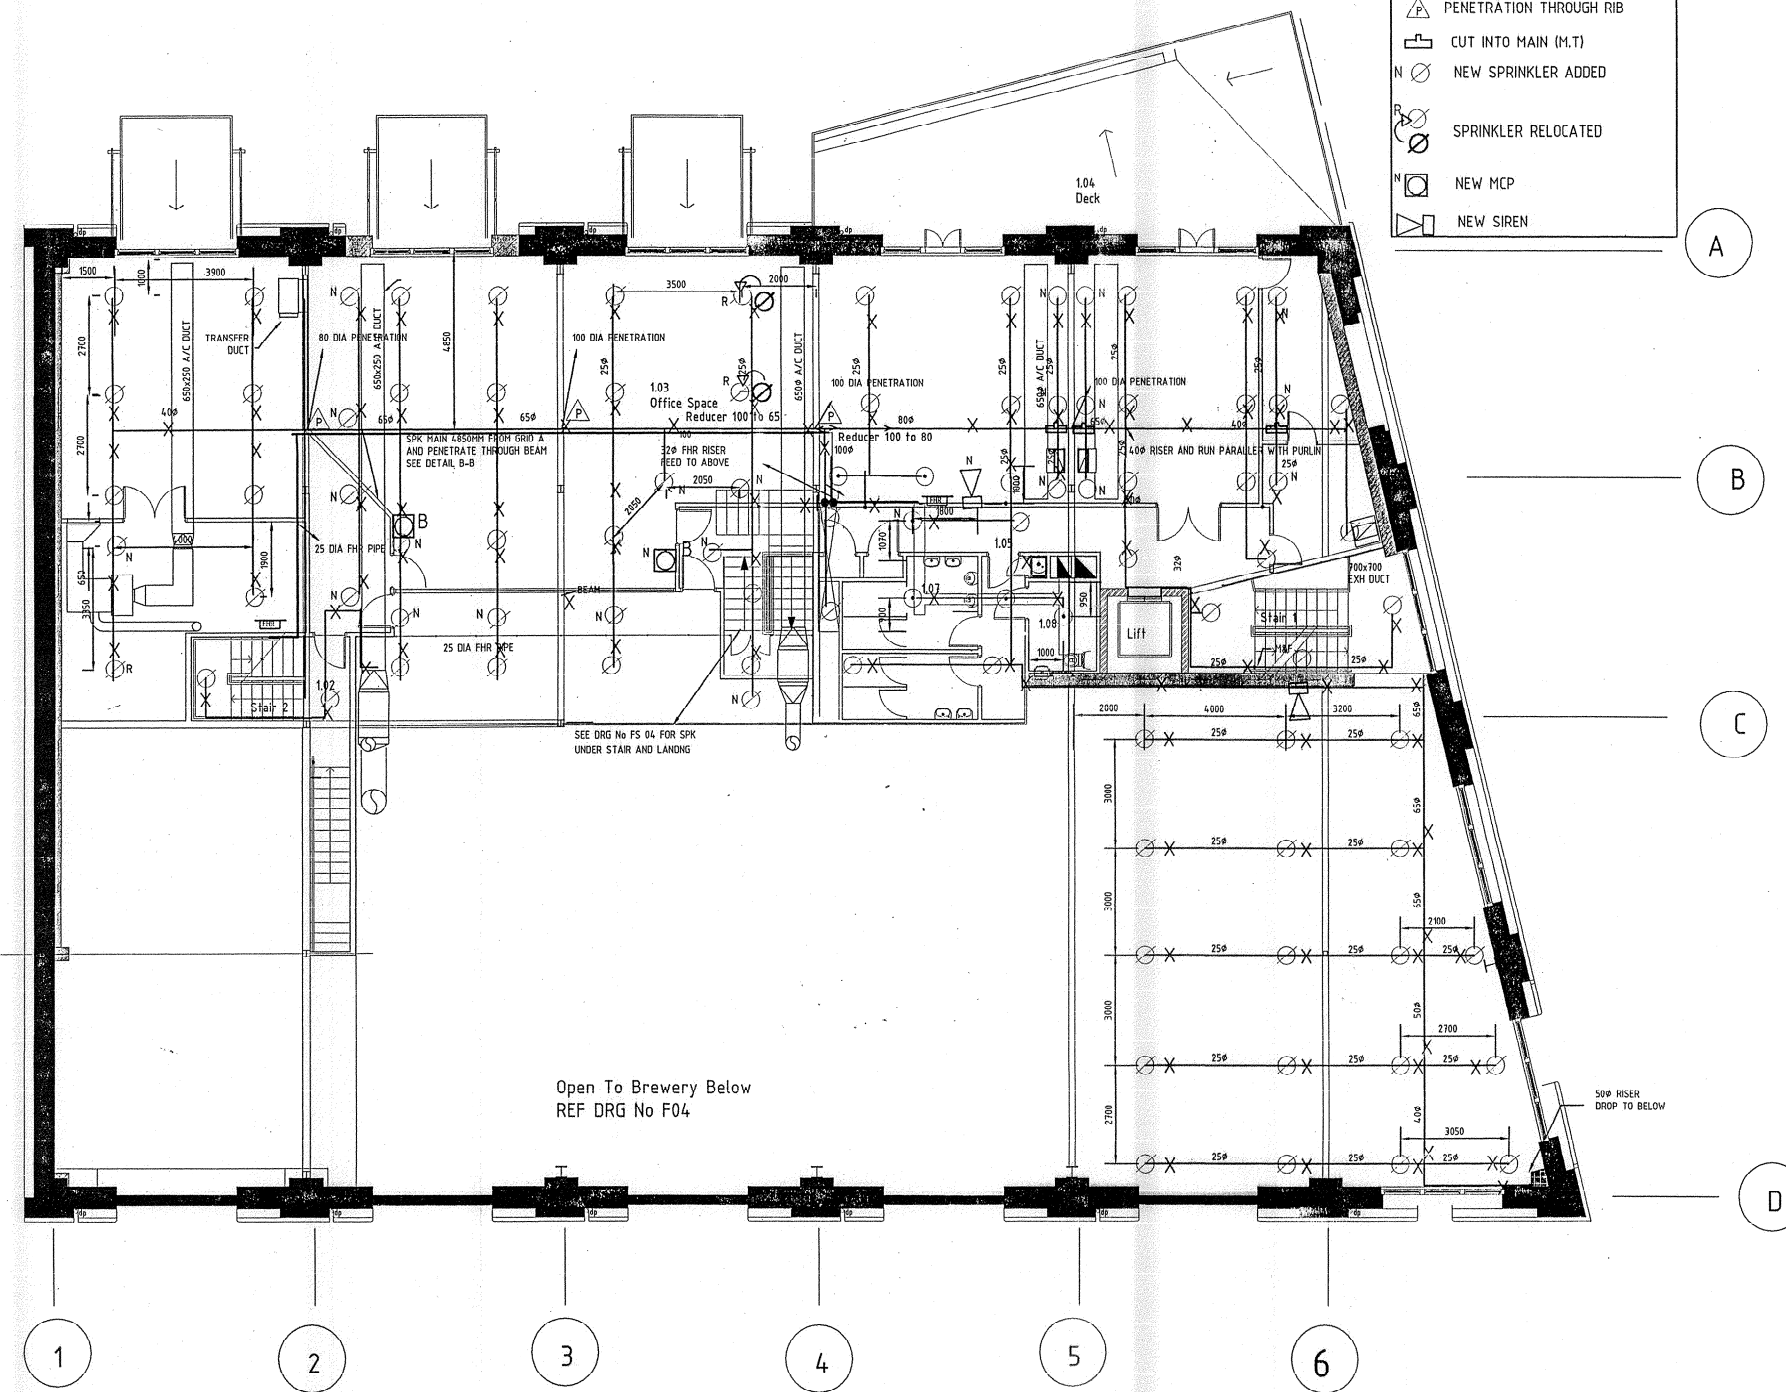

CABLE STREET

LEGEND

	PIPE HANGER AS SHOWN
	SEISMIC PIPE HANGER
	SPK ON DROP "C" 15MM X 68 DEG
	DD SPK CHROME 15MM X 69 DEG
	CEILING SPACE SPK 15MMX93 DEG BRASS
	SPK MOUNTED ON PIPE 15MMX68 DEG BRASS
	FIRE EXTINGUISHER(MULTI PURPOSE 4.5 KG)
	F. H. R. (GRINNELL 13MMX 25M RECESSED)

TOTAL

DRAWING DISTRIBUTION		ISSUE/DATE/INITIALS				
DISTRIBUTED TO	COPIES	A	B	C	D	E
WORKSHOP						
SITE	3					
LT. MCGUINNESS	3					
OTHERS						

ISSUE

DATE

12/12/01

FOR APPROVAL

REVISION

DRAWN

BRUCE LEE

DATE

17/6/02

SCALE

1:100

DESIGN CHECK'D

APP'D

JOB No

9911

SLED 22 TENANCY
CABLE ST

FIRST FLOOR
FIRE SYSTEMS

AQUAHEAT INDUSTRIES LIMITED
92-96 MAIN ROAD TAWA WELLINGTON
PH:(04) 232-5179 FAX:(04) 232-4170

DRAWING No

9911/FS2

ISSUE

A

WELLINGTON CITY COUNCIL
SERVICES REQUEST No.

- 90586


APPROVED BUILDING
CONSENT DOCUMENTS

**W.C.C.
RECORDS**

WELLINGTON CITY COUNCIL
ENVIRONMENT
10 JUL 2002
RECEIVED
WAKEFIELD ST., WELLINGTON

19 JUN 2002

NORTH

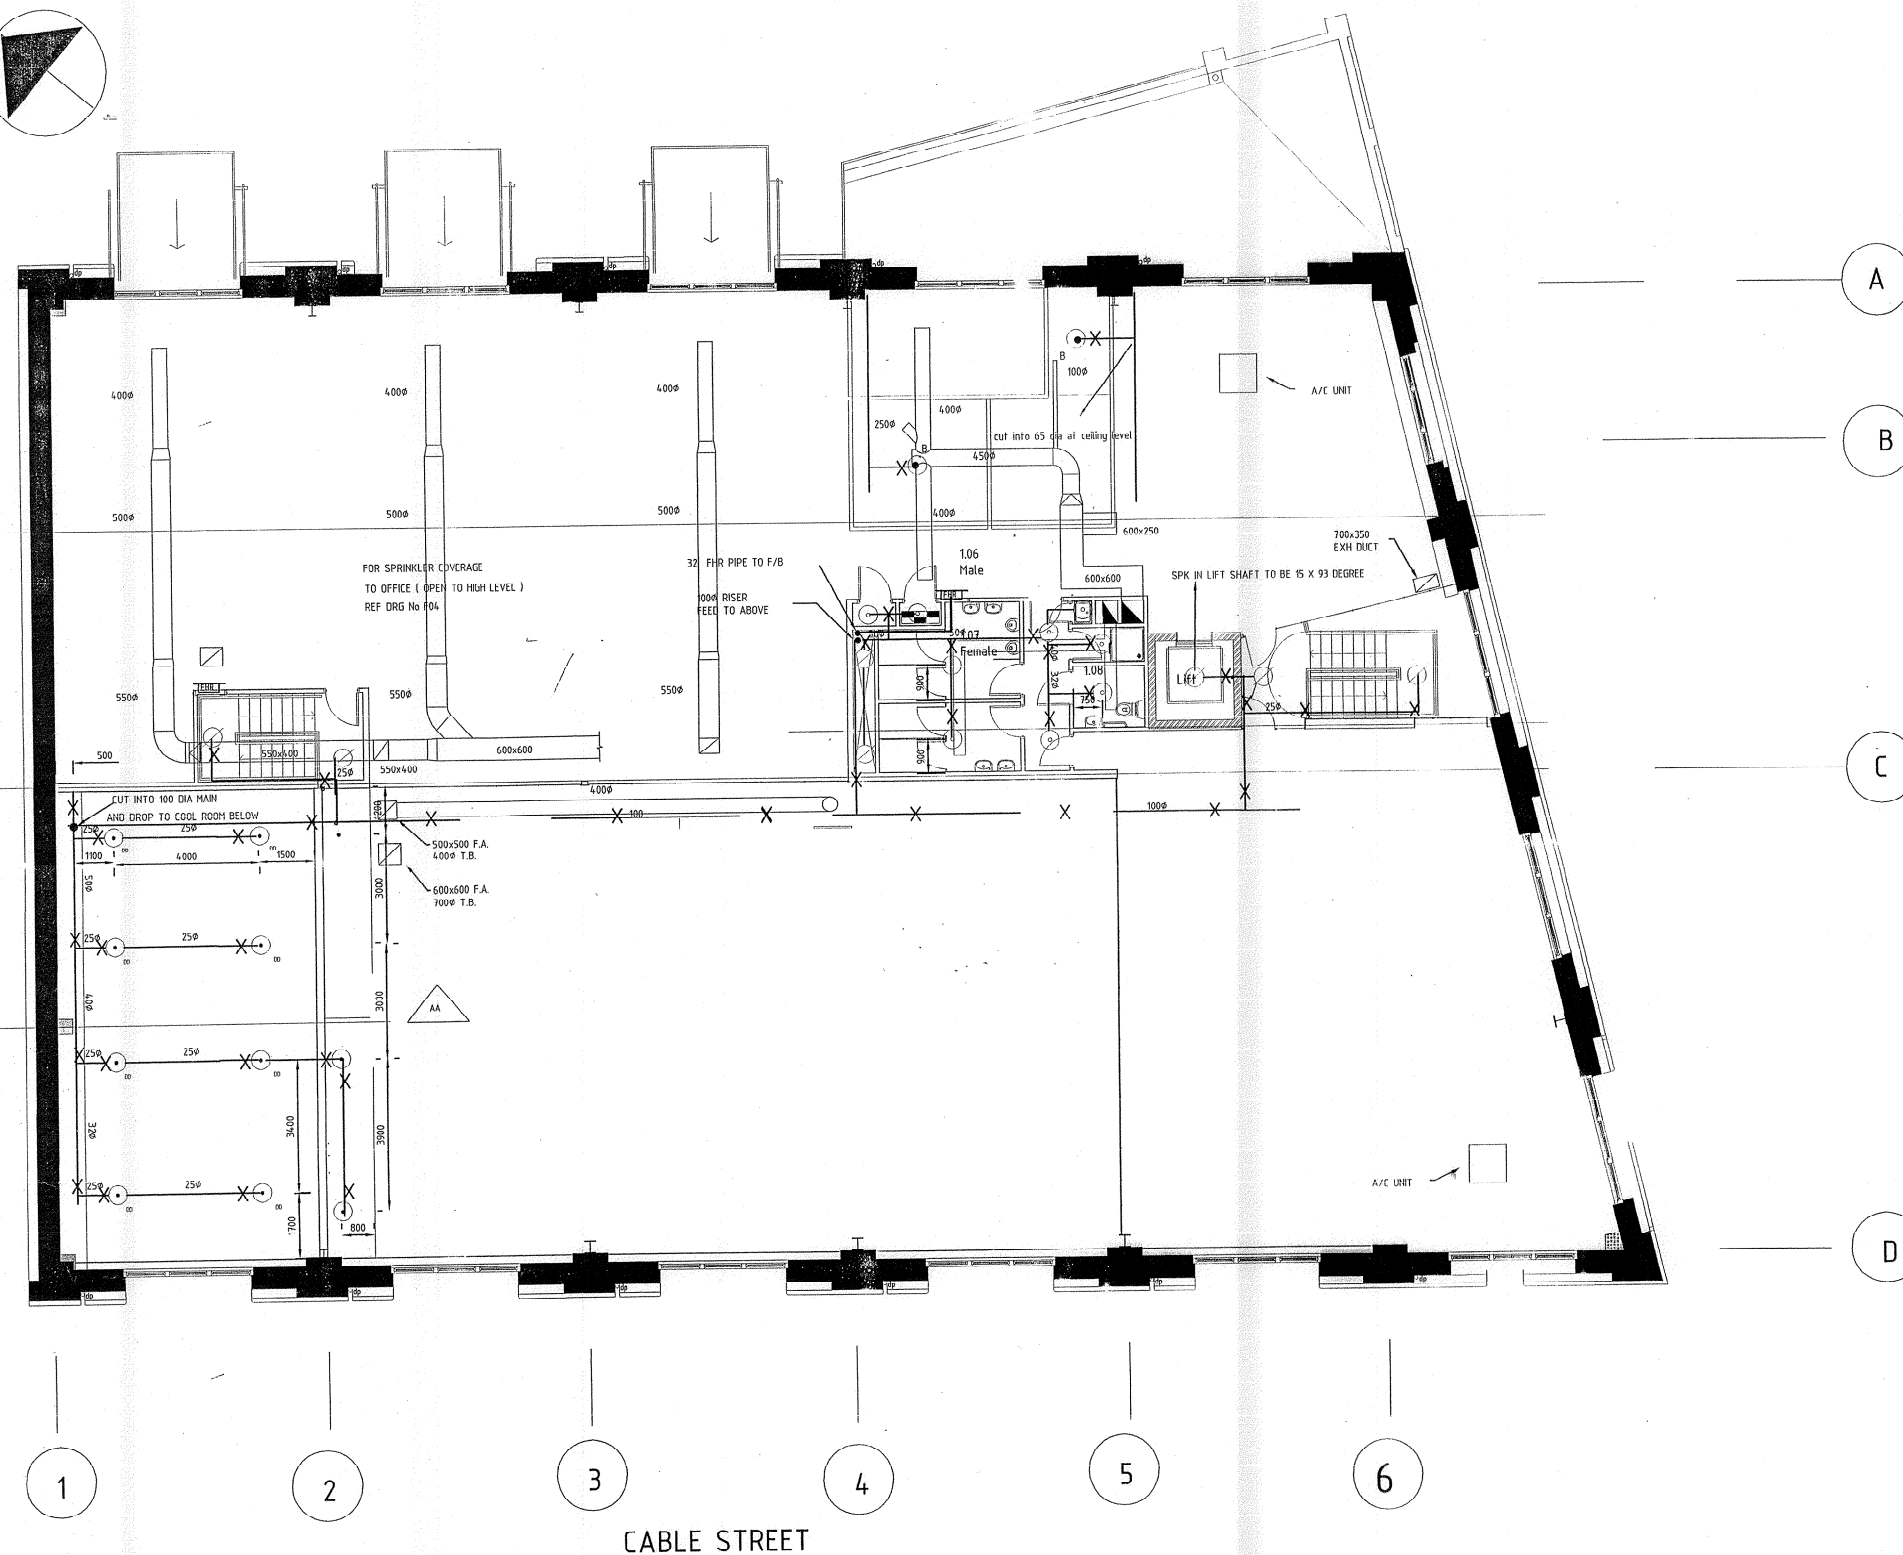

NOTES

- 1/ THIS DRAWING IS TO BE USED AS A GUIDE TO INSTALLATION. ALL DIMENSIONS ARE TO BE CHECKED ON SITE PRIOR TO MANUFACTURE OF PIPEWORK.
- 2/ SIZES OF SPRINKLER PIPE WORK THAT ARE NOT SHOWN ON THE DRAWING SHOULD BE TAKEN AS 25 ϕ PIPE

12 JUL 2002
53 GABRE 21
09A.37

WELLINGTON CITY COUNCIL
SERVICES REQUEST No.

W - 90586

APPROVED BUILDING
CONSENT DOCUMENTSW.C.C.
RECORDSWELLINGTON CITY COUNCIL
ENVIRONMENT
10 JUL 2002
RECEIVED
WAKEFIELD ST., WELLINGTONRECEIVED
19 JUL 2002
L. T. McGinness

LEGEND

SPK	SPRINKLER HEAD
X	SEISMIC PIPE HANGER
DD	SPK ON DROP 1/2" 15MM X 60 DEG
DD	DD SPK CHROME 15MM X 60 DEG

SPK	SPRINKLER HEAD 15MMX68 DEG BRASS
FE	FIRE EXTINGUISHER (MULTI PURPOSE 4.5 KG)
FE	F. H. R. (GRINNELL 13MMX 25M RECESSED)

DRAWING DISTRIBUTION		ISSUE/DATE/INITIALS				
DISTRIBUTED TO	COPIES	A	B	C	D	E
WELLINGTON	3					
LT MCGINNESS	3					
OTHERS						



REVISION	DATE	FOR APPROVAL
1	12/12/01	

DATE	18/8/02
SCALE	1:100
CHECK'D	
APP'D	
JOB No	9911

SHED 22 TENANT
CABLE ST WELLINGTON
SPRINKLER LAYOUT 2ND FLOOR
FIRE PROTECTION

AQUAHEAT INDUSTRIES LIMITED
92-96 MAIN ROAD TAWA WELLINGTON
PH: (04) 232-5179 FAX: (04) 232-4170
DRAWING No 9911/FS3 ISSUE A

WELLINGTON CITY COUNCIL
ENVIRONMENT
10 JUL 2002
RECEIVED
WAKEFIELD ST., WELLINGTON

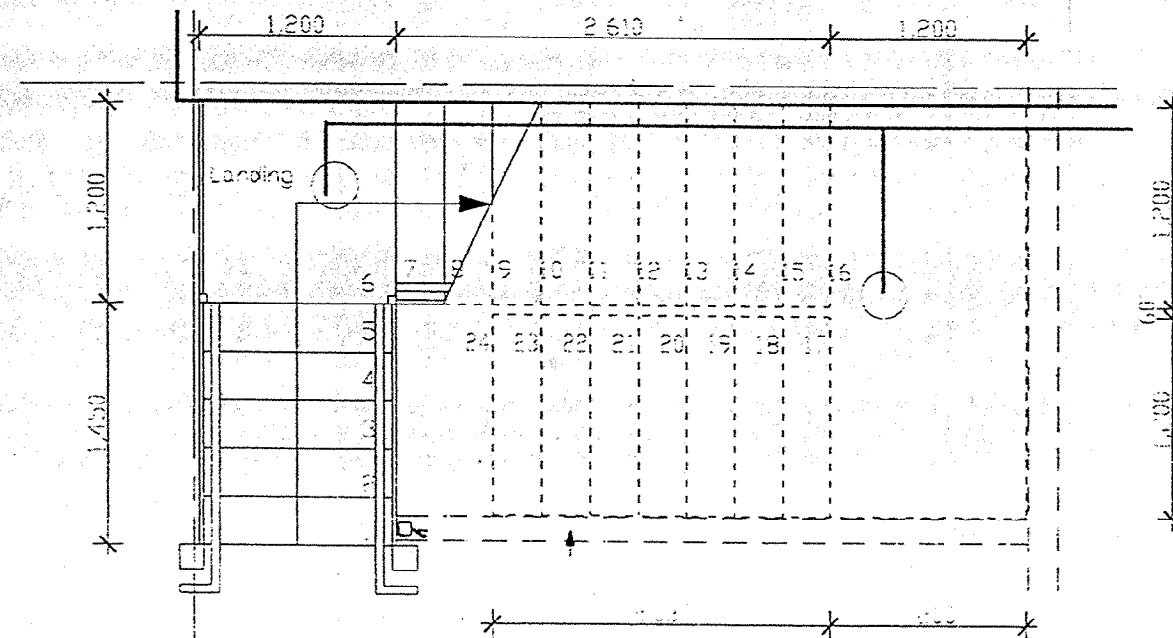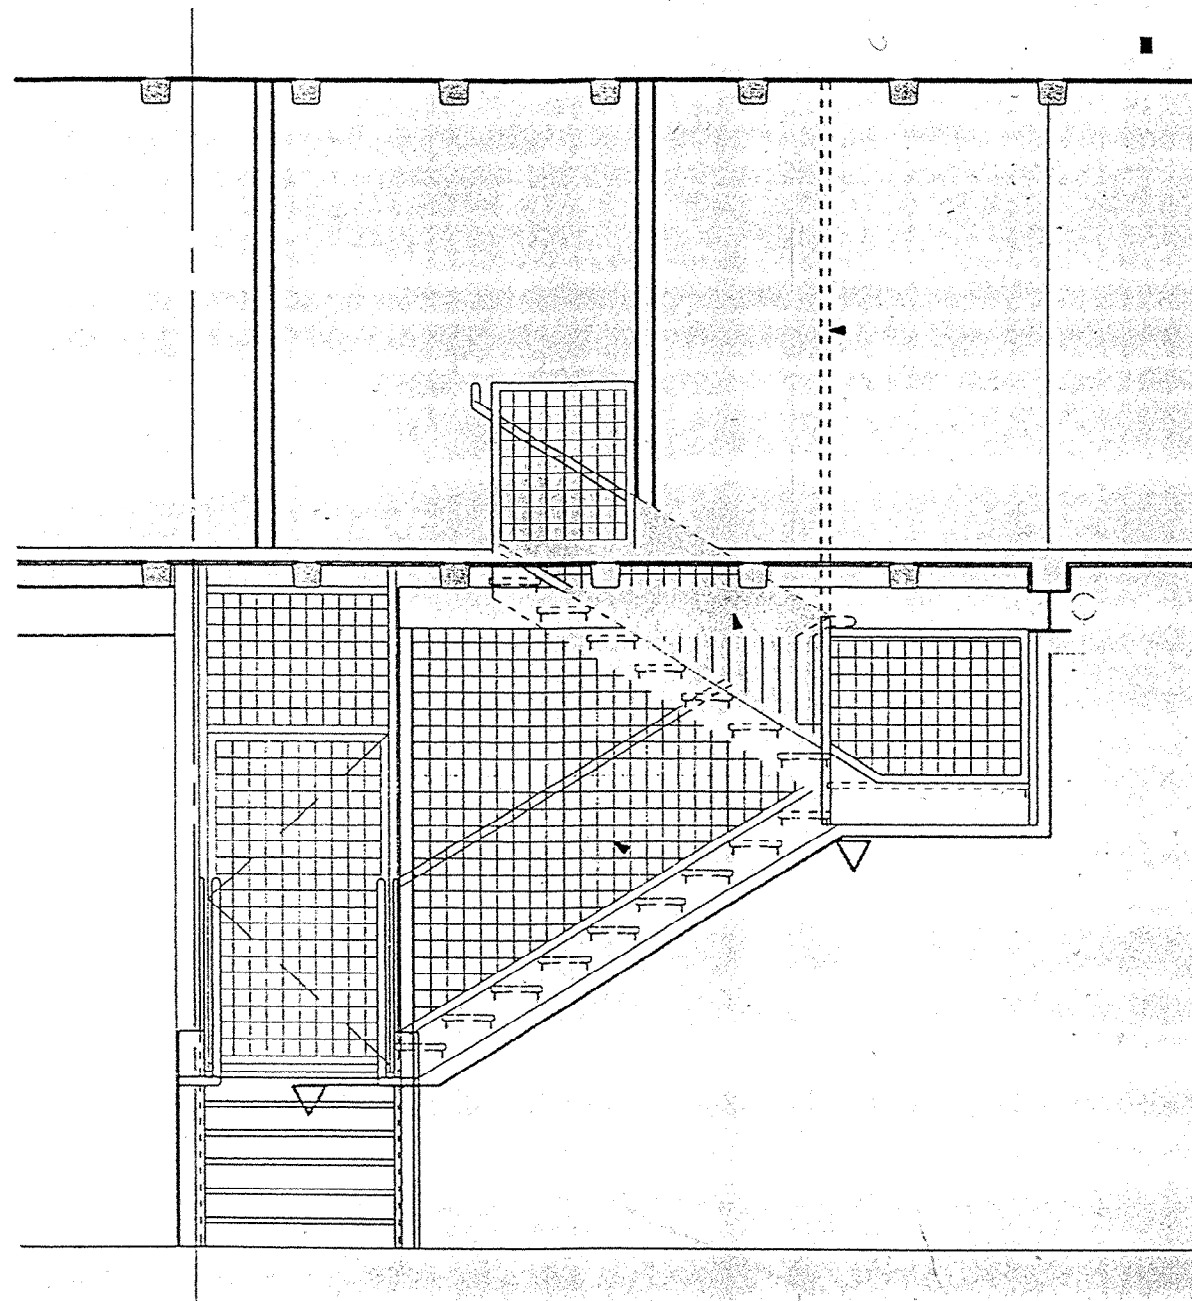

SPRINKLER UNDER STAIR
BUT NOT UNDER THE 3 4 8 4 0










WELLINGTON CITY COUNCIL
SERVICES REQUEST No.

№ - 90586 - 1
APPROVED BUILDING
CONSENT DOCUMENTS

RECEIVED
19 JUN 2002
L. T. McGuinness

LEGEND

☒ PIPE HANGER AS SHOWN	☐ CEILING SPACE SPK 10MMX68DEG BRASS	DRAWING DISTRIBUTION							ISSUE	DATE	REVISION	DRAWN	BRUCE LEE	SHED 22 TENANCY CABLE STREET WELLINGTON SPRINKLER UNDER STAIR FIRE PROTECTION	 AQUAHEAT INDUSTRIES LIMITED 92-96 MAIN ROAD TAWA WELLINGTON PH: (04) 232-5179 FAX: (04) 232-4170	DRAWING No.	9911/FS 4	ISSUE		
☒ SEISMIC PIPE HANGER	☒ SPK MOUNTED ON PIPE 15MMX58 DEG BRASS	DISTRIBUTED TO	COPIES	ISSUE/DATE/INITIALS					A	17/6/02	FOR APPROVAL	DATE	17/6/02						SCALE	1: 100
☒ SPK PENDENT 10MMX68 DEG (W)	☐ FIRE EXTINGUISHER (MULTI PURPOSE 4.5 KG)	WORKSHOP	3	A	B	C	D	E					DESIGN CHECKED							
☒ 2 PIECE ESC PLATE WHITE 114	☒ F. H. R. (GRINNELL 13MMX 25M RECESSED)	SITE	3										APP'D							
		CLIENT NAME	3										JOB No							
		OTHERS																		

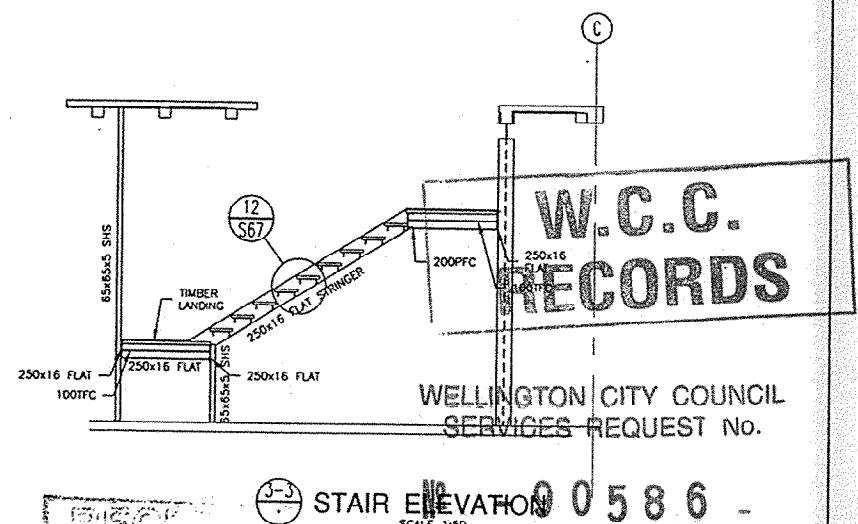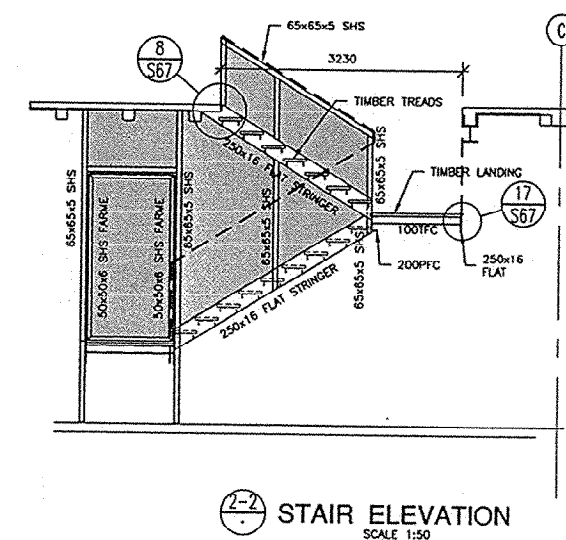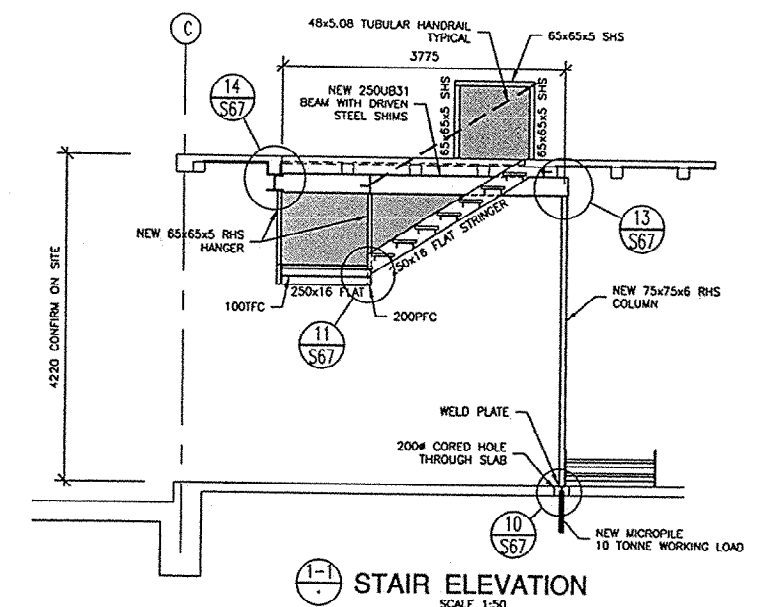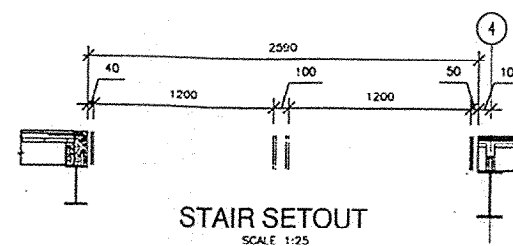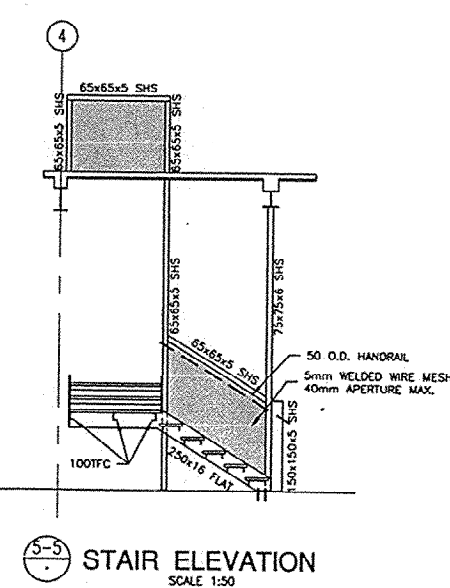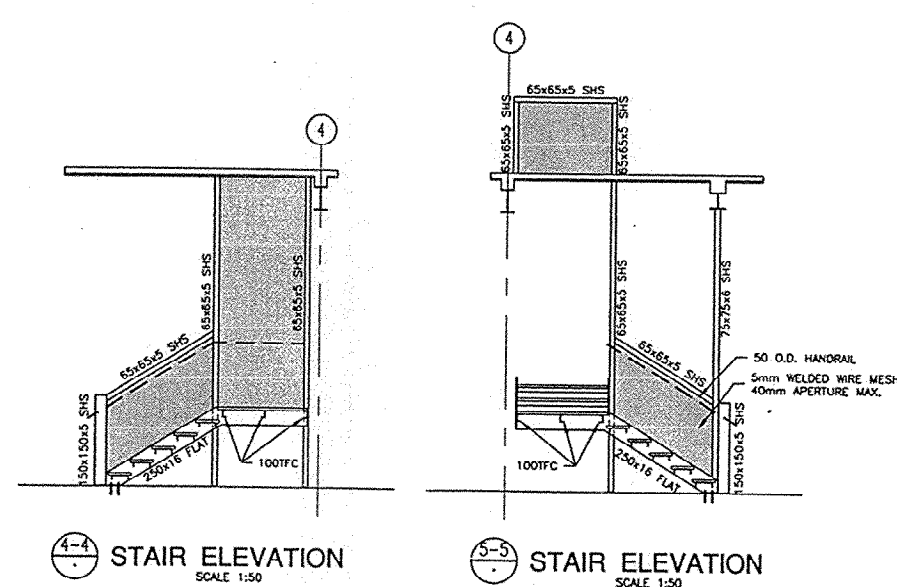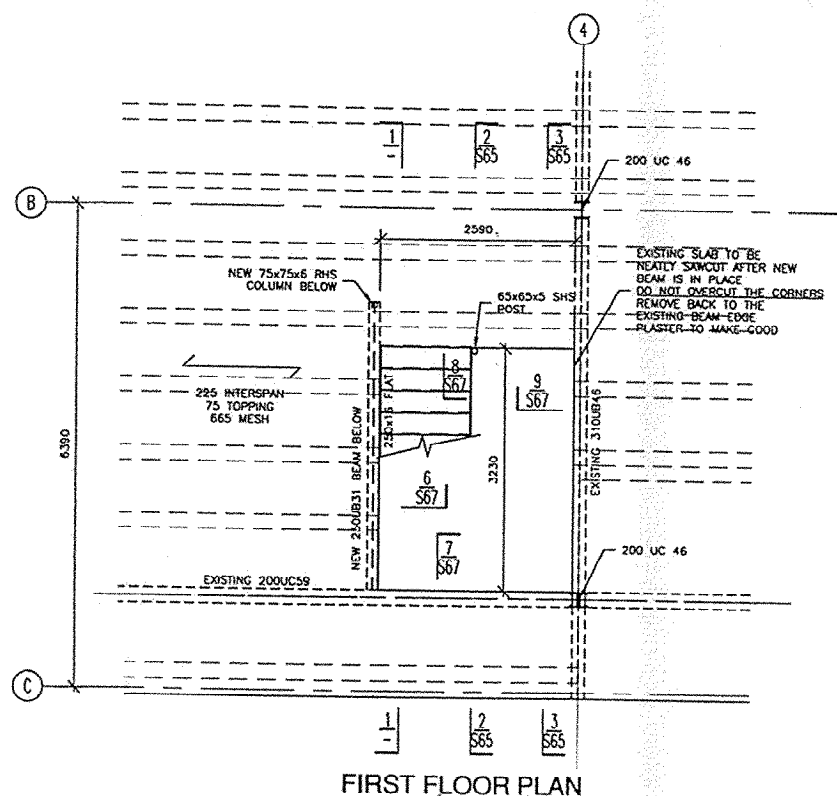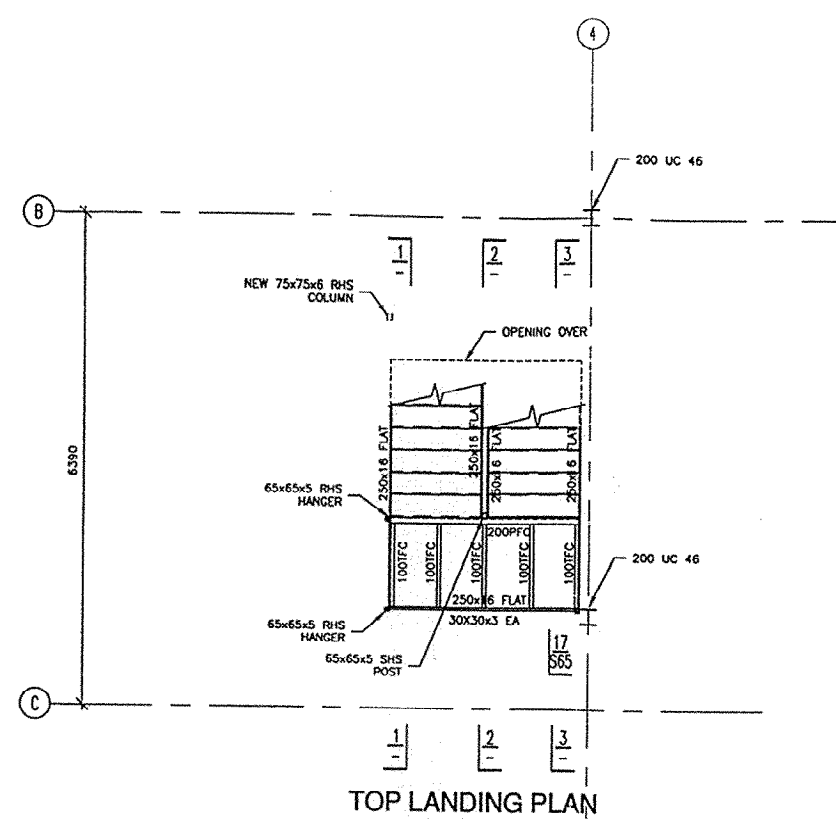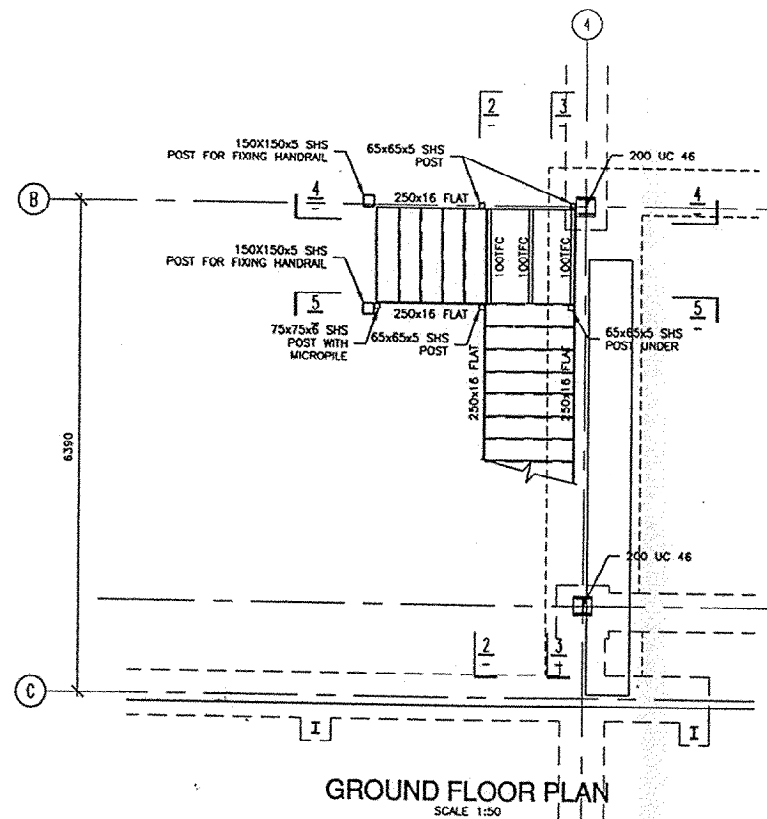

NOT FOR CONSTRUCTION

10 JUN 2002

APPROVED BUILDING
CONSENT DOCUMENTS

NOTES:

1: ALL EXISTING DIMENSIONS TO BE SITE MEASURED PRIOR TO FABRICATION

2: ALL STEEL/STEEL CONNECTIONS TO BE FULLY WELDED WITH 6mm FILLET ALL ROUND UNLESS NOTED OTHERWISE

athfield architects limited

po box 3354 Wellington
ph 04 499 1727
fax 04 499 1960
athfield@clear.net.nz

SHED 22
FOR
WILLIS BOND & Co

PROPOSED

ADDITIONAL STAIR
PLANS & ELEVATIONS

REVISIONS		
B	FOR PRICING	07-06-02
A	PRELIMINARY	6-22-02

Scales	1:25,1:50
A3 Scales	1:50,1:100
Designed	Loreta SALAZAR
Drawn	Martin WILLIAMS
CAD Reference	4495s65












Job Number
4495
Drawing Number
S65
Rev B



Dunning Thornton Consultants Ltd
Consulting Engineers

Phone (844) 385-0019
Fax (844) 385-0312
Box 27-153 Wellington, N.Z.
E-mail dctwgrt@dunningthornton.co.nz

The logo is a stylized, abstract graphic consisting of several overlapping, curved shapes that form a central, somewhat circular or diamond-like structure. The design is dark and appears to be a silhouette or a high-contrast print.

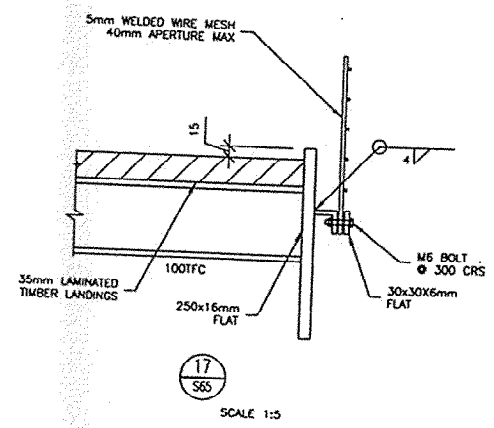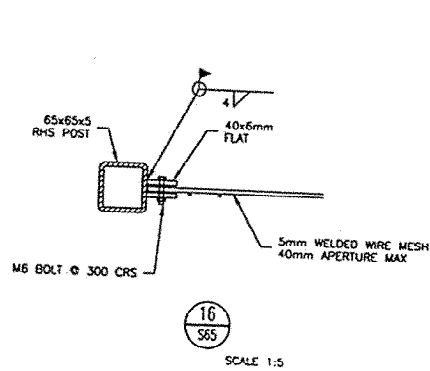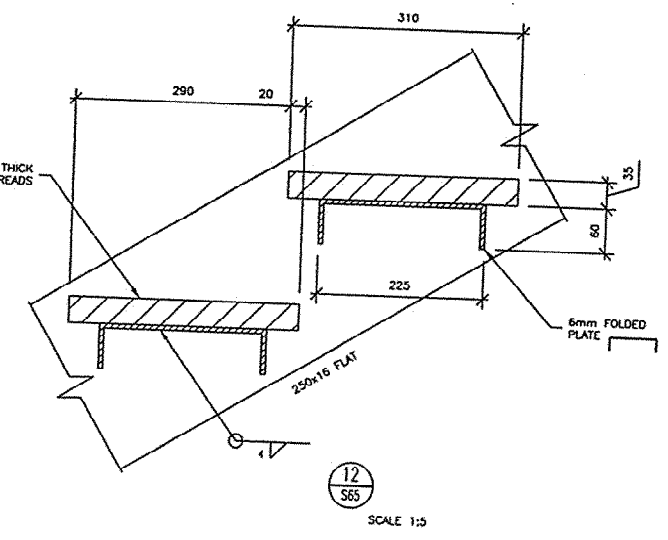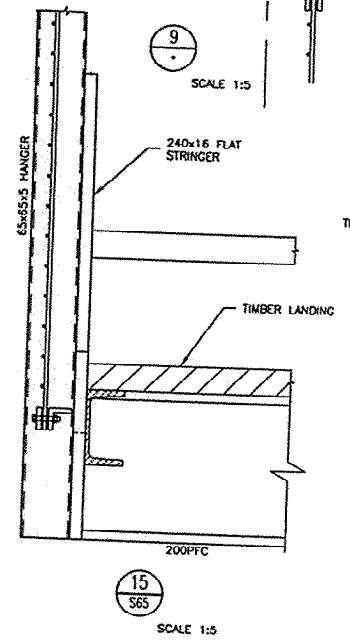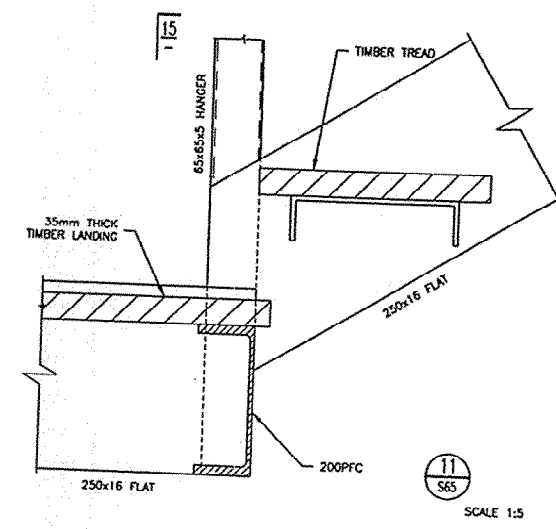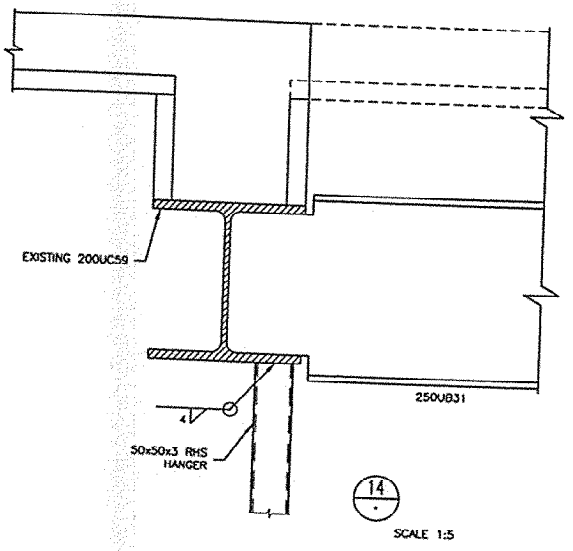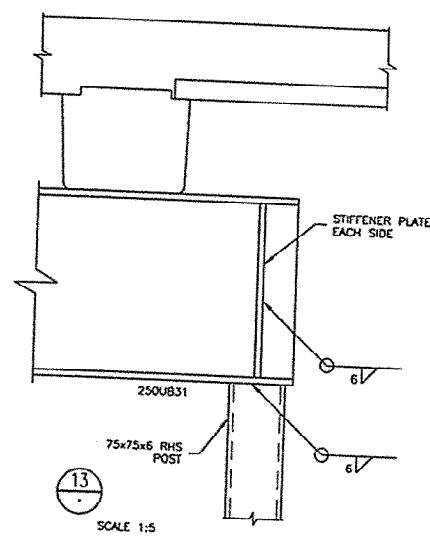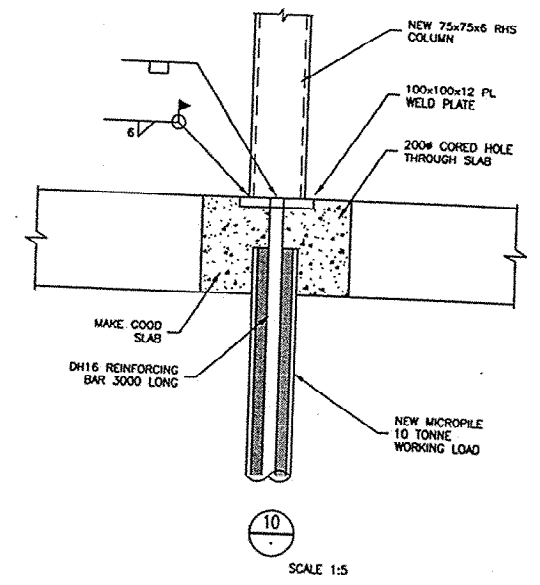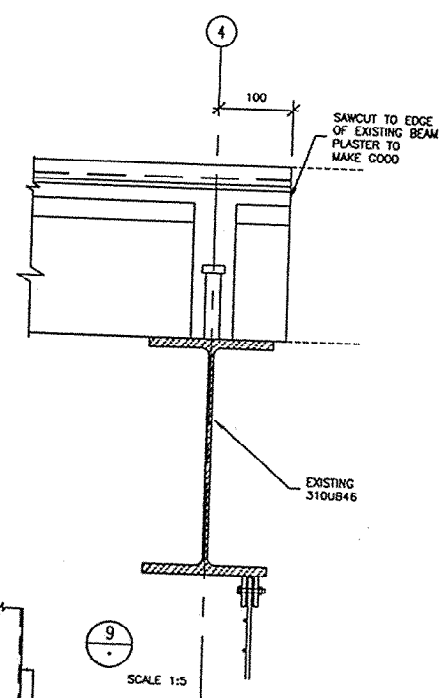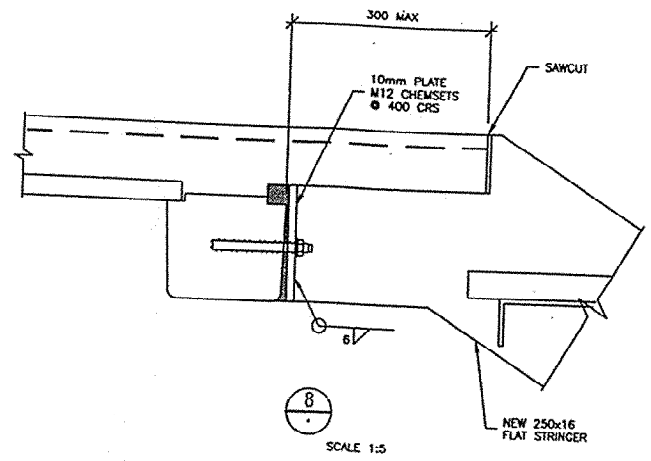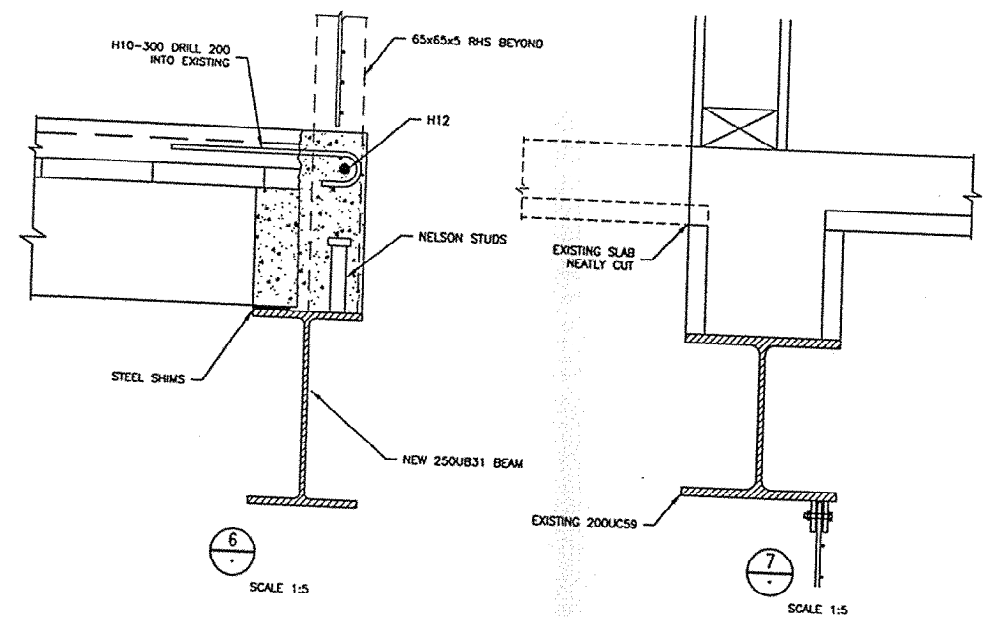

WELLINGTON CITY COUNCIL
SERVICES REQUEST No.

90586

APPROVED BUILDING
CONSENT DOCUMENTS

10 JUN 2002

L. T. McGuinness

NOT FOR CONSTRUCTION

W.C.C. RECORDS
NOTES:
1: ALL EXISTING DIMENSIONS TO BE SITE MEASURED PRIOR TO CONSTRUCTION.
2: ALL STEEL/STEEL CONNECTIONS TO BE FULLY WELDED WITH 6mm MINIMUM ROUNDOFF UNLESS NOTED OTHERWISE.

athfield architects limited

po box 3364 Wellington
ph 04 459 1737
fax 04 459 1550
athfield@clear.net.nz

SHED 22
FOR
WILLIS BOND & Co

PROPOSED
ADDITIONAL STAIR
DETAILS

REVISIONS	
B	FOR PRICING
A	PRELIMINARY
	07.06.02
	8.03.02

Scales 1:5
A3 Scales 1:10
Designed Loreta SALAZAR
Drawn Martin WILLIAMS
CAD Reference 4495s65

Job Number 4495
Drawing Number S67
Rev B





Dunning Thornton Consultants Ltd
Consulting Engineers
Phone (644) 385-0019
Fax (644) 385-0312
Box 27-153 Wellington, N.Z.
E-mail dtc@dtc.dunningthornton.co.nz

WELLINGTON CITY COUNCIL
SERVICE REQUEST NO. 90586
APPROVED BUILDING
CONSENT DOCUMENT

W.C.C.
RECORDS

WELLINGTON CITY COUNCIL
ENVIRONMENT
- 1 NOV 2002
RECEIVED

Variation
Drawings
25/9/2002

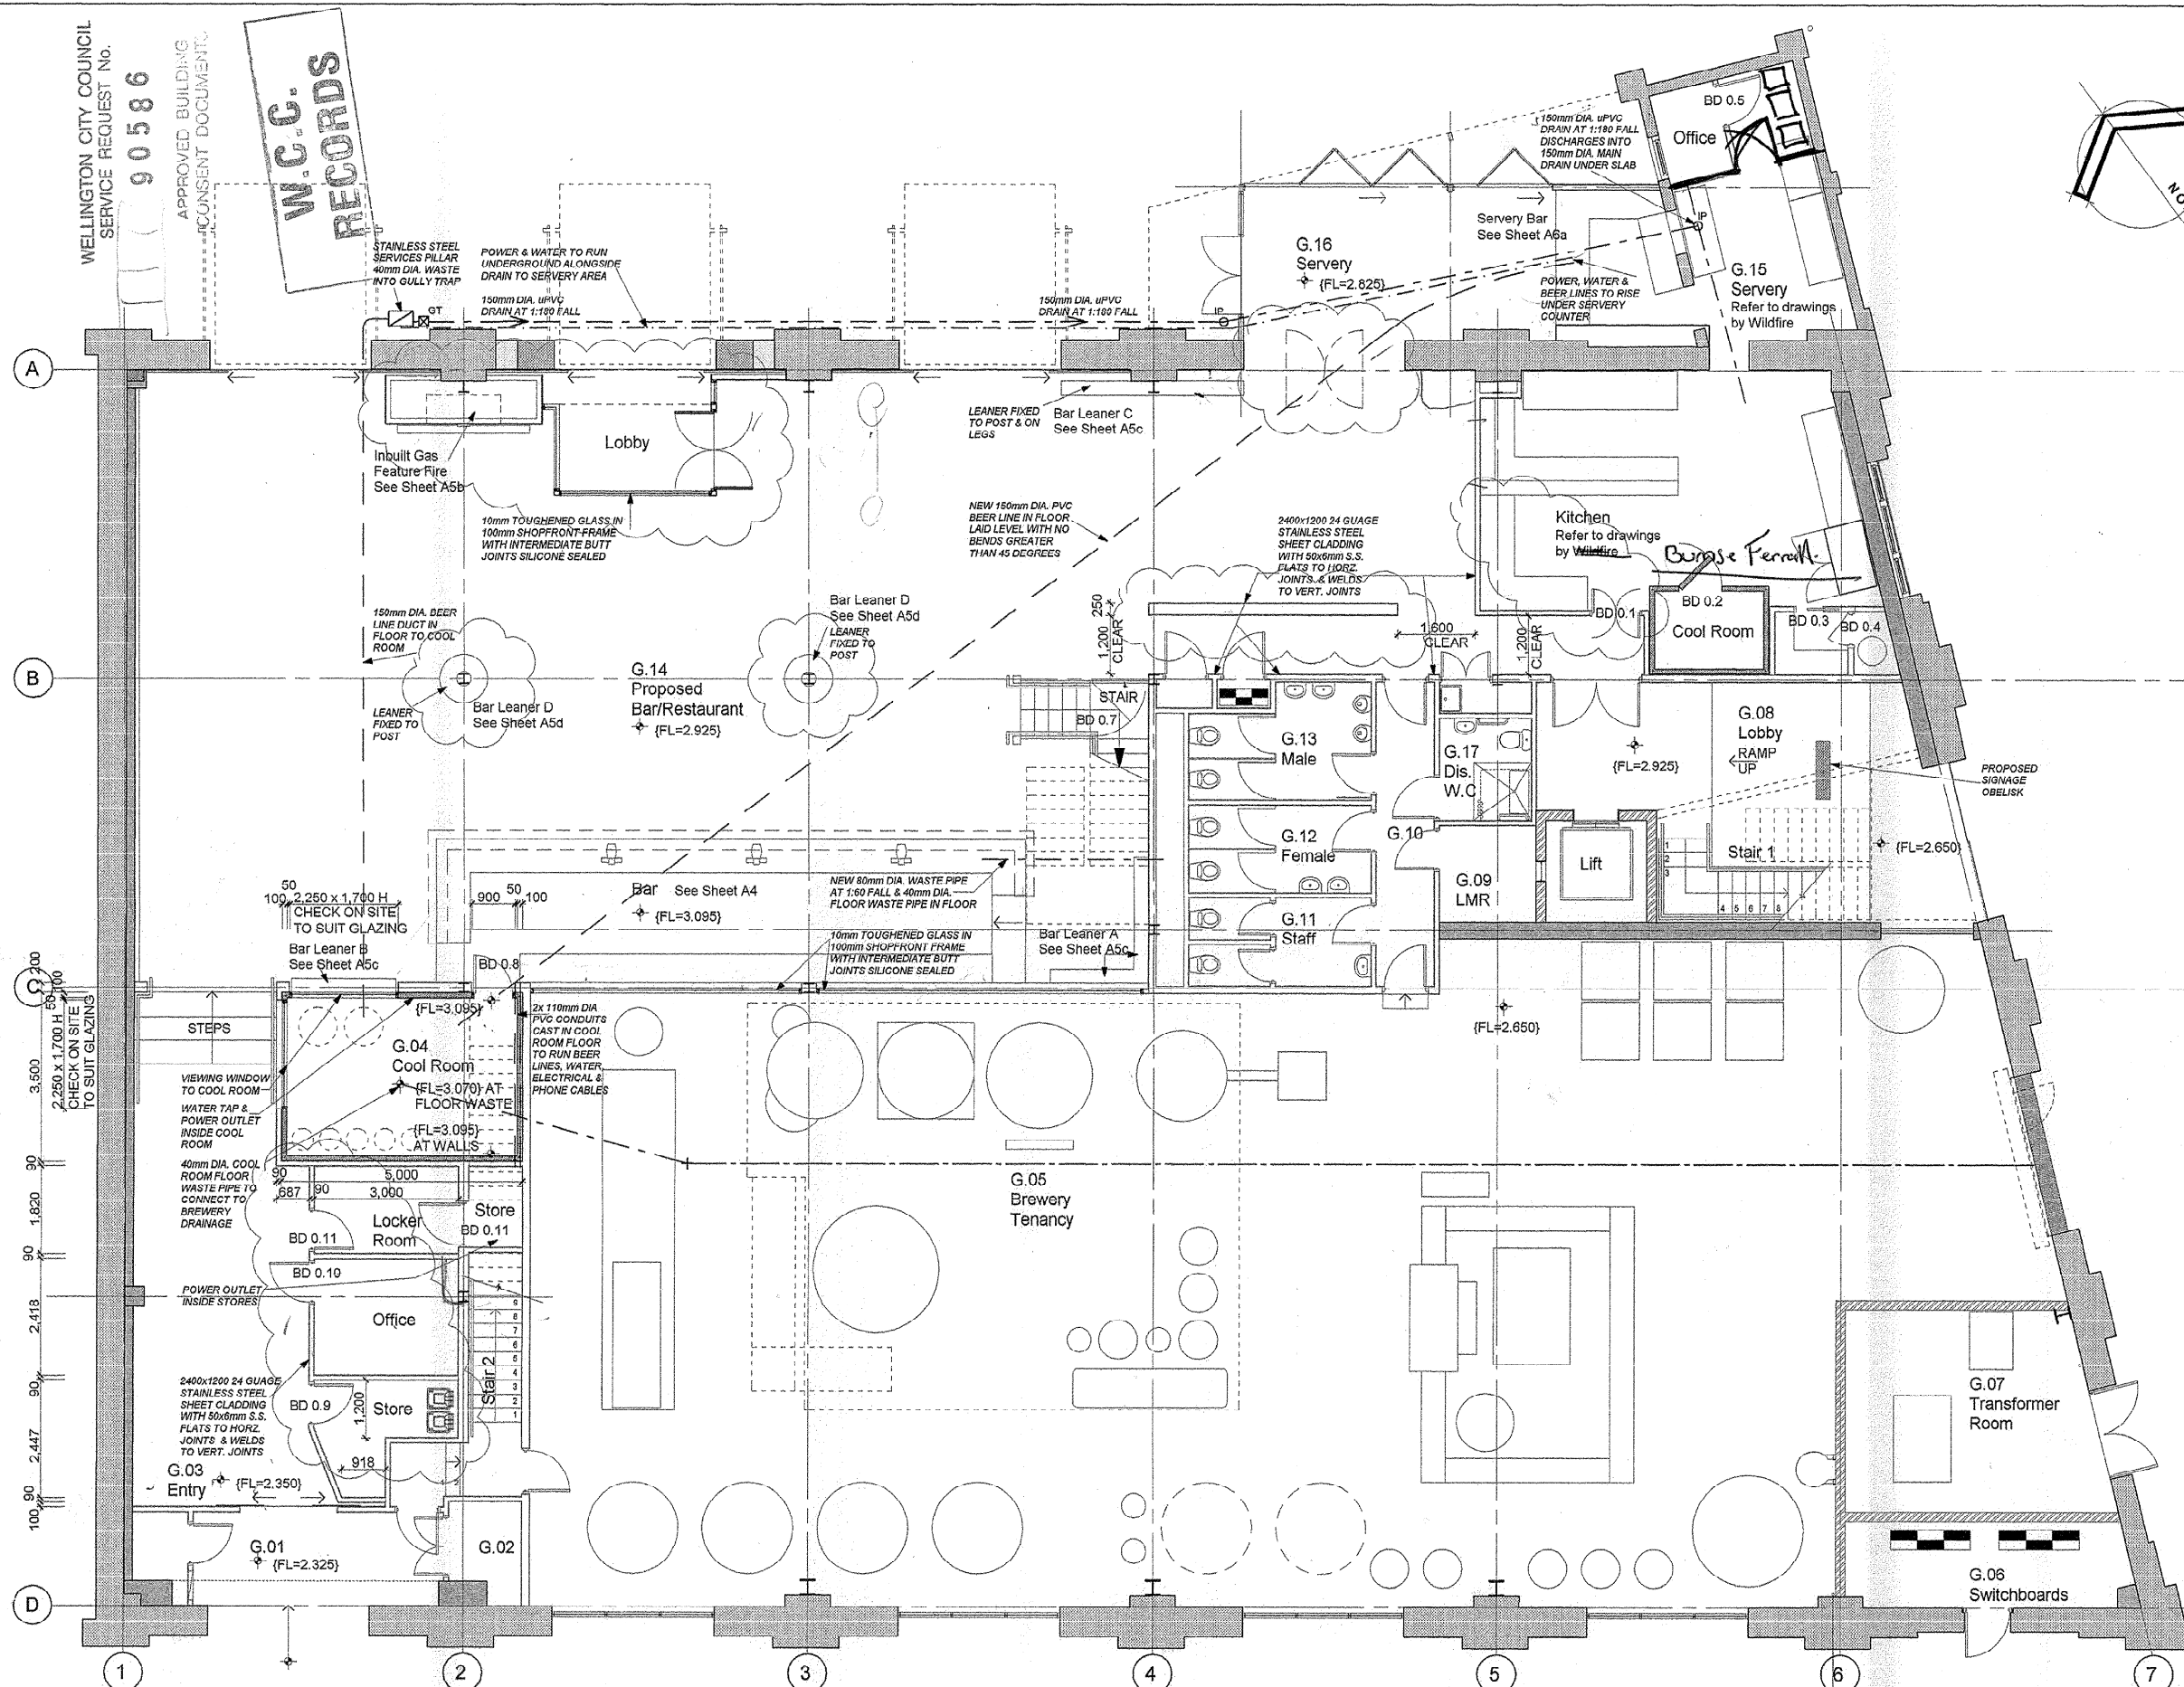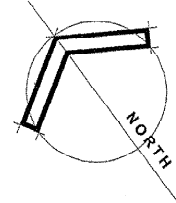

AMENDED
PLANS



GROUND FLOOR PLAN


SCALE 1:100

66 mandeville street . p o box 36210 . christchurch . new zealand
ph 64 3 343 6556 . fax 64 3 343 6566 . email info@3baldmen.co.nz

CONTRACTOR SHALL CHECK ALL DIMENSIONS PRIOR TO COMMENCING WORK
THIS DRAWING IS CONFIDENTIAL FOR SECURITY & COPYRIGHT

SHED 22 - WELLINGTON

REVISION	DESCRIPTION	DATE
7	ADD LOBBY, AMEND FIREPLACE, KITCHEN DOOR, OFFICES & SCREENS	24/09/02
6	ADD NOTES & WINDOW TO COOL ROOM, AMEND STEPS	24/09/02
5	AMEND BRICK WALLS, REMOVE RAMP, SEATING & STAGE	04/06/02
4	ADD STAIR HANDRAILS, AMEND SEATING & COOL RM WINDOW	30/04/02
3	ADD GRIDS, AMEND WINDOW WALL	15/04/02
2	ADD STAIR & BREWERY, AMEND BAR LENGTH & COOL RM WINDOWS	09/04/02
1	ADD DIMENSIONS & NOTES, AMEND BAR WALL, BREWERY & KITCHEN	06/03/02

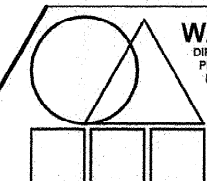

WARREN ARCHITECTURAL DESIGN

DIRECTOR :
PHONE/FAX :
EMAIL :
ADDRESS :

SCALE :
DATE :
FILE :

A1